



City of Tampa
Jane Castor, Mayor

Contract Administration
Michael W. Chucran, Director
306 East Jackson Street, 4N
Tampa, FL 33602
Office (813) 274-8116
Fax: (813) 274-7368

ADDENDUM 1
Via E-Mail
DATE: May 26, 2022

Contract: 22-C-00015; Kennedy Blvd Gravity Sewer Rehabilitation by CIPP

Bidders on the above referenced project are hereby notified that the following addendum is made to the Contract Documents. BIDS TO BE SUBMITTED SHALL CONFORM TO THIS NOTICE.

Item 1: The bid date is hereby changed to June 14, 2022.

Item 2: Replace Proposal page P-2 with the attached Proposal page P-2R.

Item 3: Insert the attached As-Built Drawing sheets 7, A-1, R-6, XE13-15, XE13-17, XE13-23, SS-4, SS-5, 147-44, 5, 3, 1of 3, 1of 2, C1.2, C1.4, WW 1.1 and SPE-650.


All other provisions of the Contract Documents and Specifications not in conflict with this Addendum shall remain in full force and effect. Questions are to be e-mailed to ContractAdministration@tampagov.net.

Jim Greiner


Jim Greiner, P.E., Contract Management Supervisor

**Kennedy Blvd Gravity Sewer Rehabilitation by CIPP
Contract 22-C-00015**

Item No.	Item	Quantity	Unit	Unit Price in Words	Unit Price	Total
100	Contingency	1	LS	One Hundred Thousand Dollars	\$100,000.00	\$100,000.00
102	Maintenance of Traffic	1	LS	Ten Thousand Dollars	\$10,000.00	\$10,000.00
0408.2360	Cured in Place Pipe for 8" Dia. Gravity Sewer (.236 inch thick)	8,371	LF			
0410.2950	Cured in Place Pipe for 10" Dia. Gravity Sewer (.295 inch thick)	342	LF			
0415.2950	Cured in Place Pipe for 15" Dia. Gravity Sewer (.295 inch thick)	1,605	LF			
0601.08	Hydraulic Cleaning & Inspection of 8" Dia. Gravity Sewer	7,265	LF			
0601.10	Hydraulic Cleaning & Inspection of 10" Dia. Gravity Sewer	342	LF			
0601.15	Hydraulic Cleaning & Inspection of 15" Dia. Gravity Sewer	1,605	LF			
9000	Sewer Bypass with Tanker Truck	500	Hrs			
9050.08	Sewage Bypass Pumping for 8" Dia. Sewer	21,424	LF			
9050.10	Sewage Bypass Pumping for 10" Dia. Sewer	327	LF			
9050.15	Sewage Bypass Pumping for 15" Dia. Sewer	74	LF			
0621.08	Cleaning & Inspection of Tuberculated Cast Iron or Ductile Iron Sewer , 8" Dia.	1,106	LF			
0621.10	Cleaning & Inspection of Tuberculated Cast Iron or Ductile Iron Sewer , 10" Dia.	50	LF			
0621.15	Cleaning & Inspection of Tuberculated Cast Iron or Ductile Iron Sewer , 15" Dia.	50	LF			
0602.08	Additional Mechanical Cleaning & Inspection of 8" Dia. Gravity Sewer	50	LF			
0602.10	Additional Mechanical Cleaning & Inspection of 10" Dia. Gravity Sewer	50	LF			
0602.15	Additional Mechanical Cleaning & Inspection of 15" Dia. Gravity Sewer	50	LF			
2050	Reconnect Service Connections	173	EA			
2051.08	Chemical Grout Unit - chemical grout lateral post liner install - 8-inch gravity pipe diameter	160	EA			
2051.10	Chemical Grout Unit - chemical grout lateral post liner install - 10-inch gravity pipe diameter	10	EA			
2052.10	Chemical Grout Unit - chemical grout lateral post liner install - 15-inch gravity pipe diameter	10	EA			
4800	Manhole Rehabilitation by Coating System min. 250 mils thickness	2,400	SF			
4600	Cast Iron Frame and Cover	12	EA			
700	Disposal of Debris	50	CY			
Total						

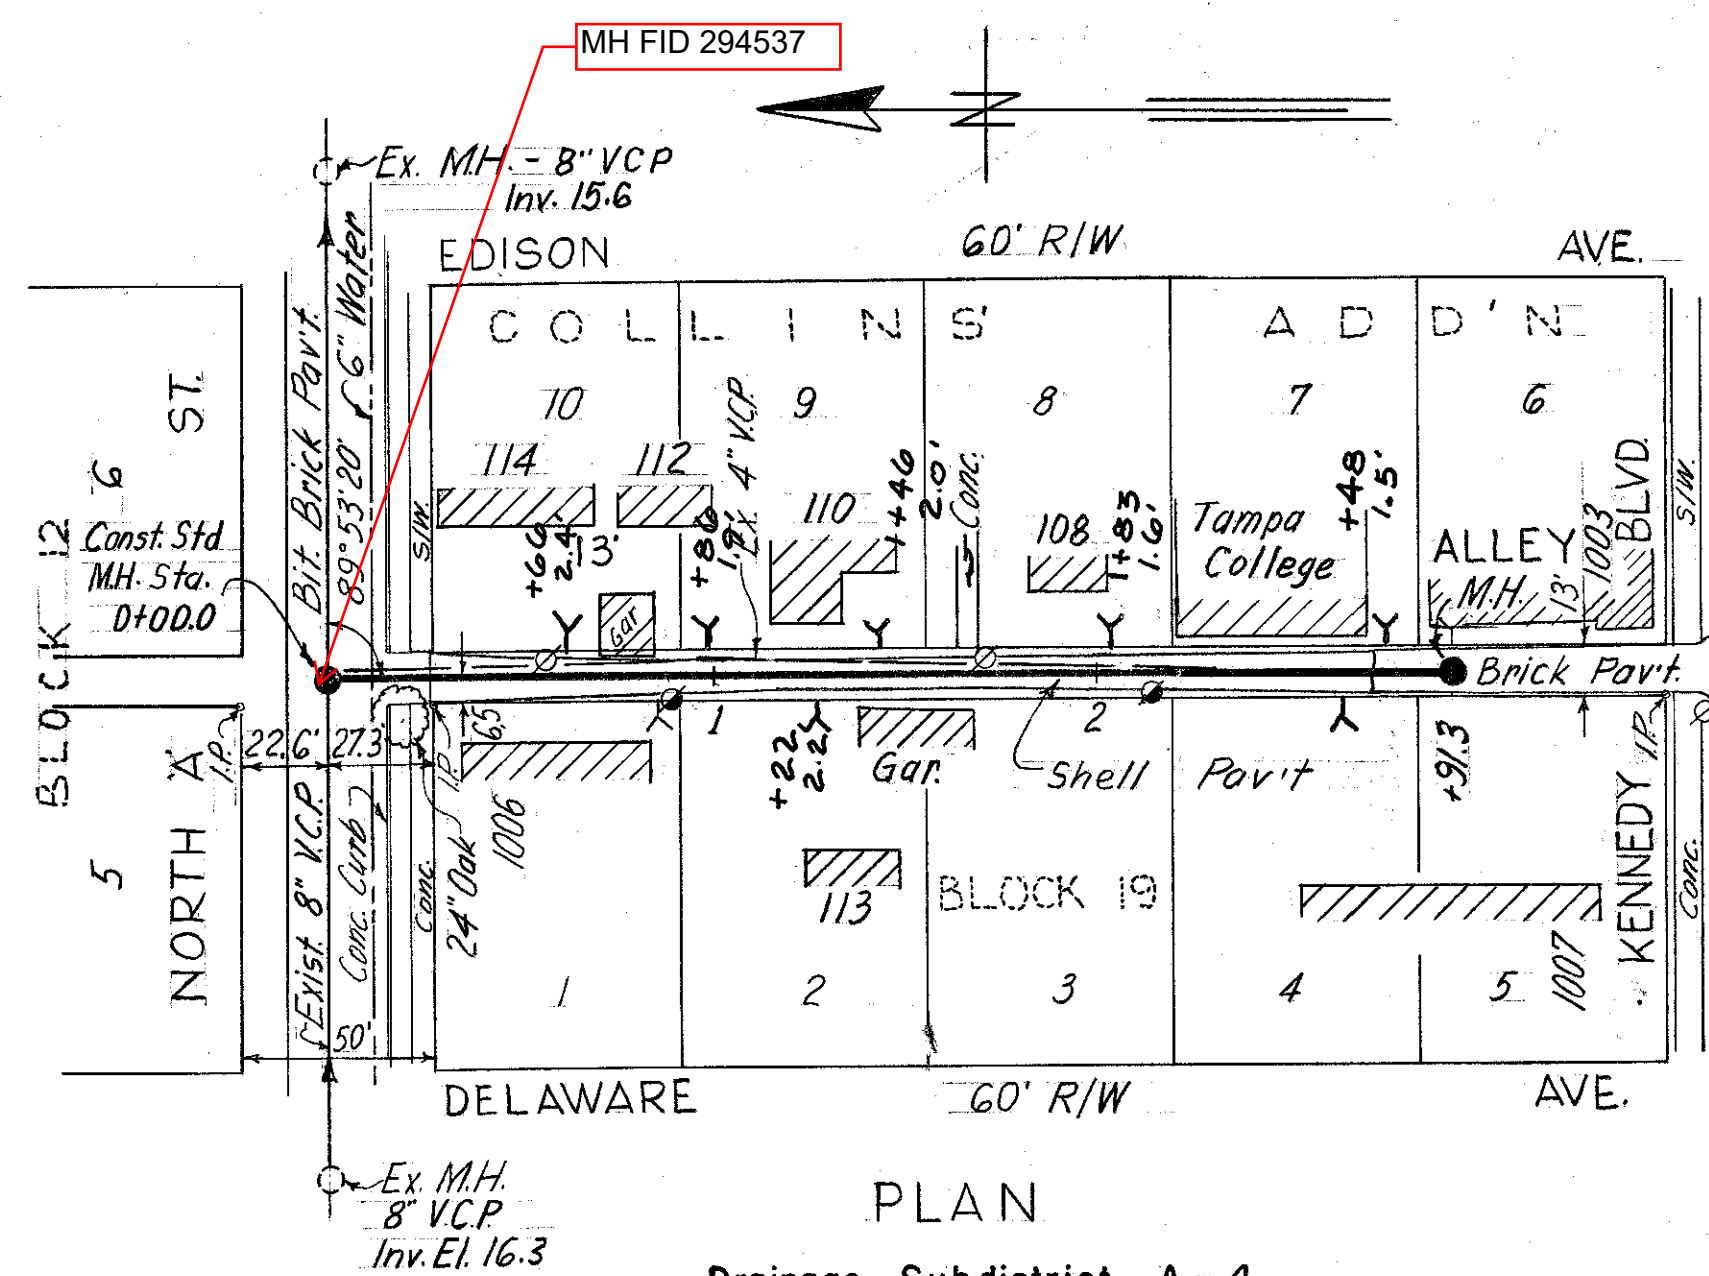


Drainage Subdistrict A-4

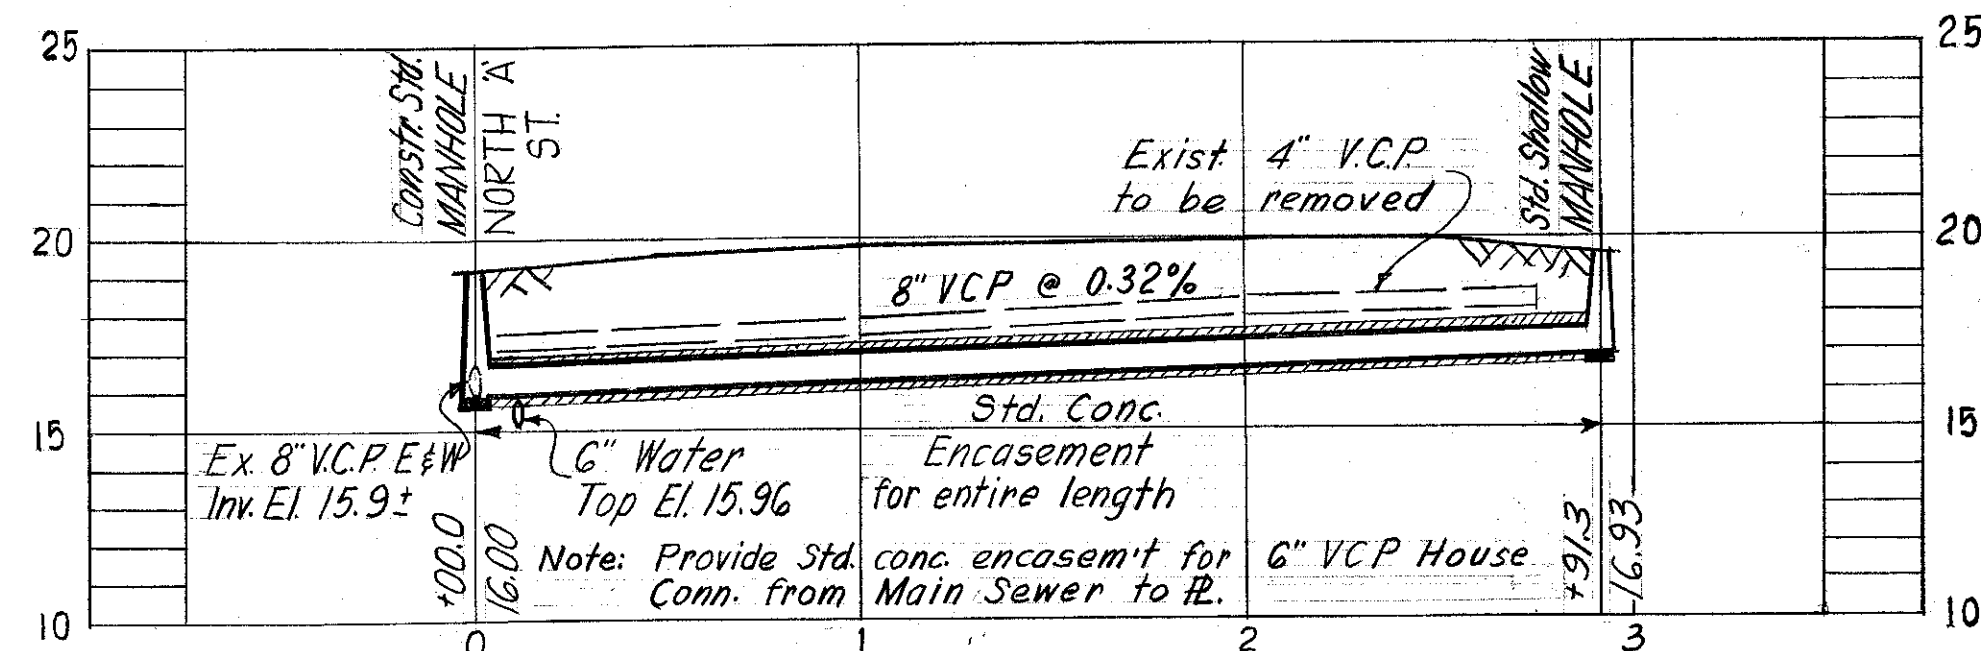


PROFILE
W.O. 1604

TBM. used: Elev. 19.804
Nail in root of 24\"/>

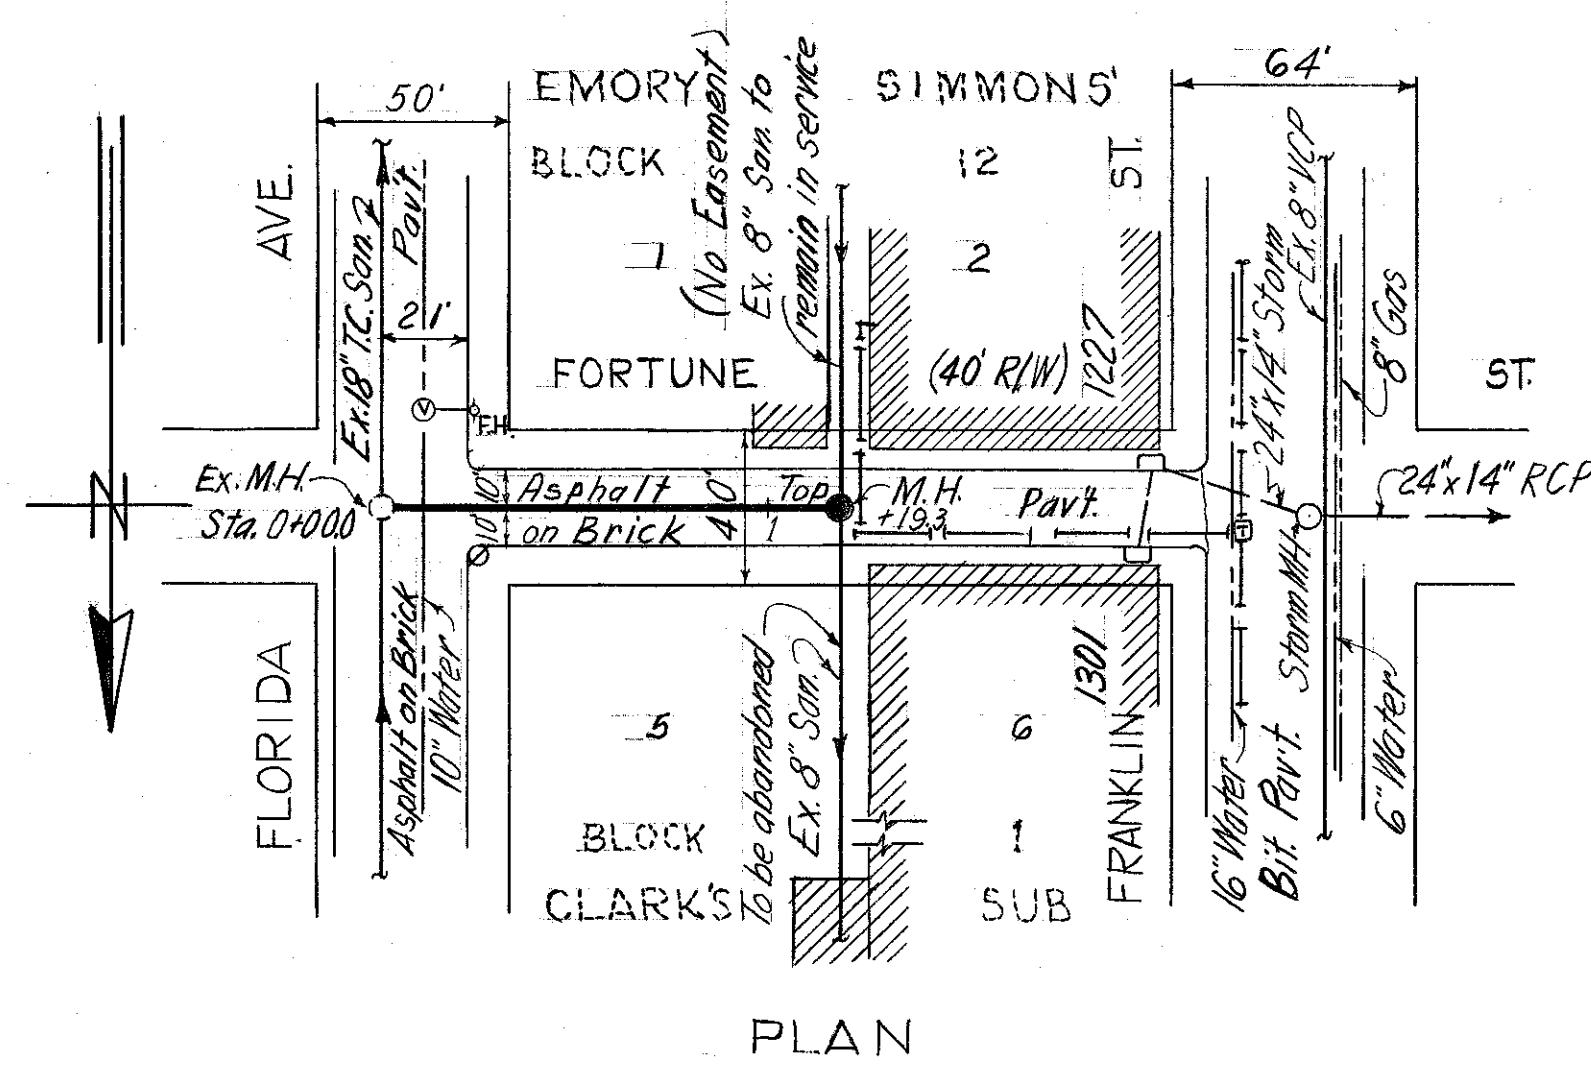


Drainage Subdistrict A-13

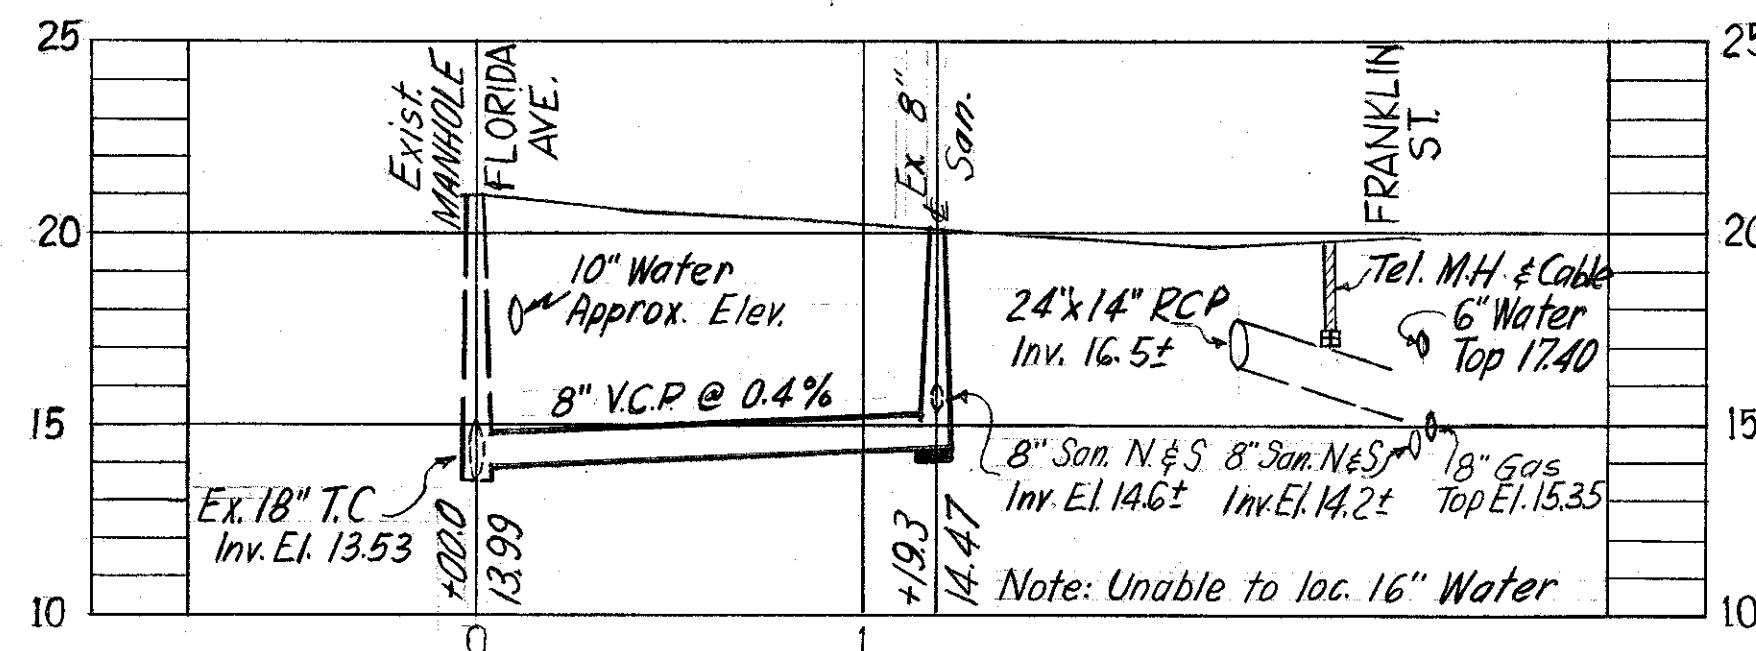

PROFILE
W.O. 1650

B.M. # 59 (G. & H.) Elev. 19.12
Sidewalk @ S.E. corner of
Florida Ave. & Constant St.


* Denotes house connections plugged at sewer.

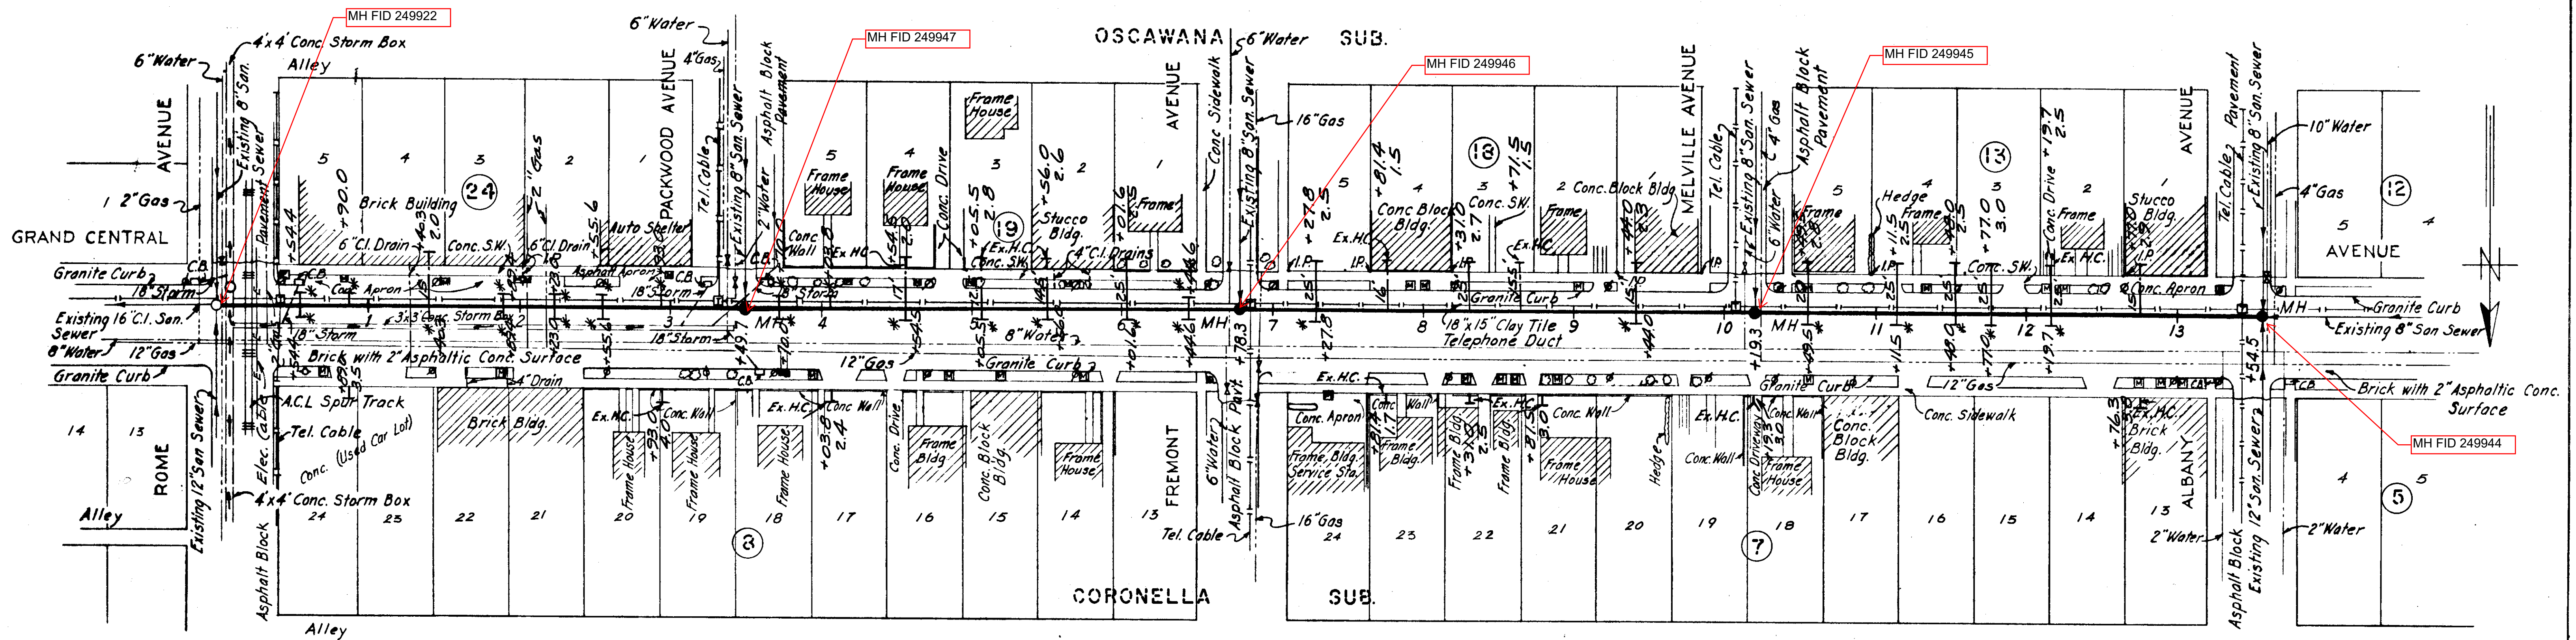

PLAN

AS-BUILT PLAN

Revised to show actual conditions according to construction records as of 1-6-53 (J.I.S. 1-9-53)

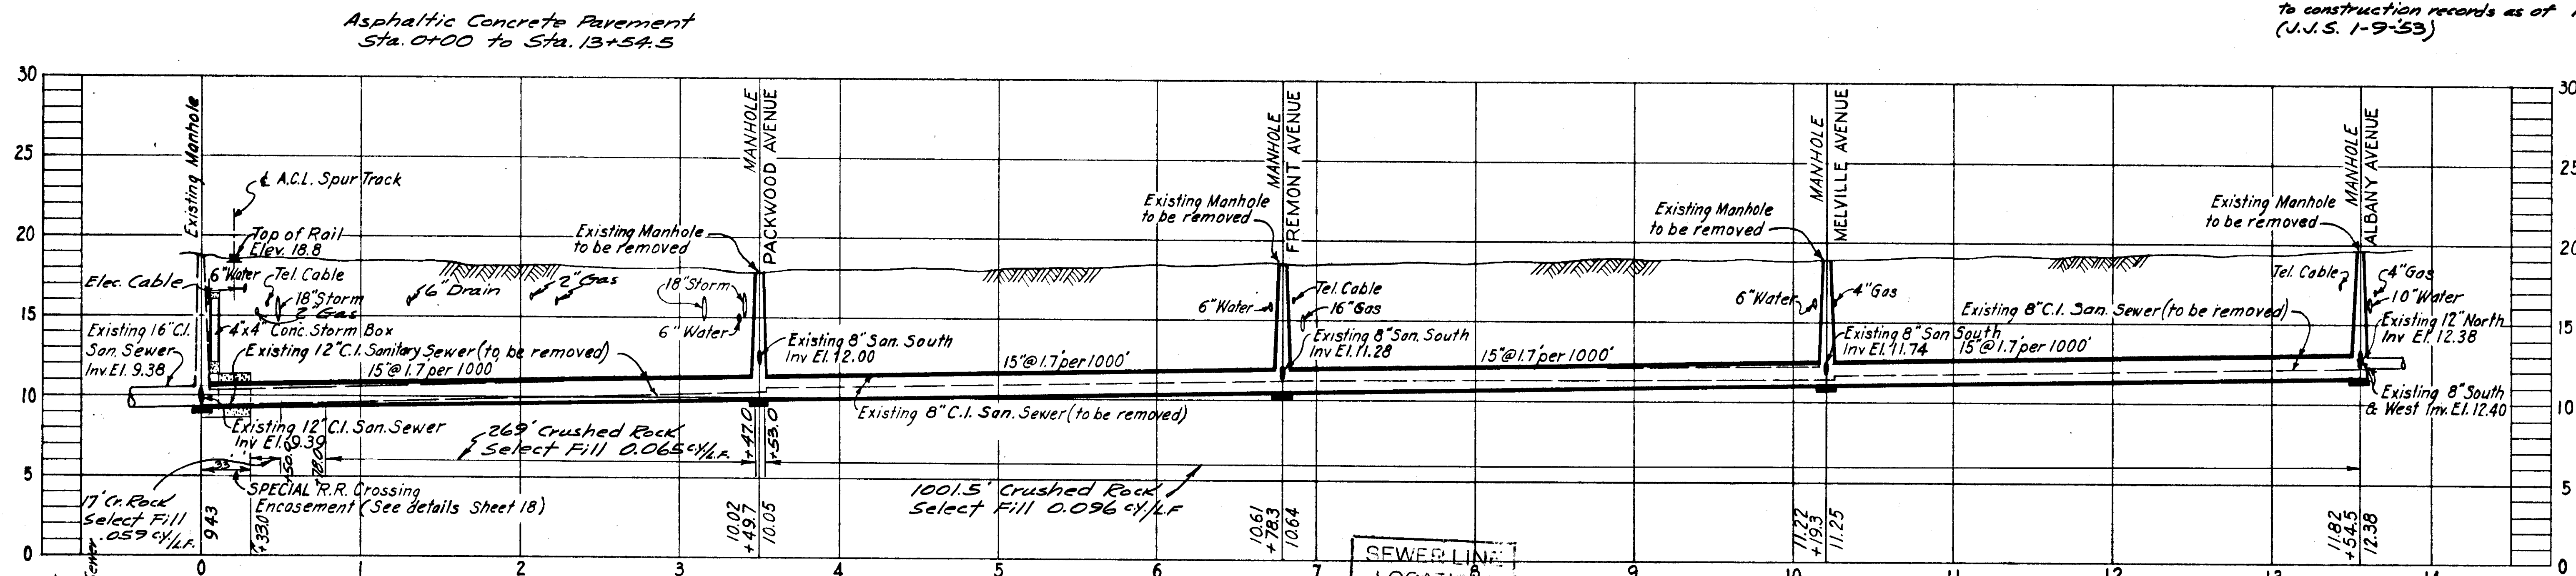

PROFILE R-6

SEC. MAP No.	LINE No.
1-11-31	

Existing live house connections at time of construction of new sewer.

STA.	Dir.	Address
0+89.0	N	1703- Gr. Central Ave.
1+40.3	S	1702- Gr. Central Ave.
2+93.0	N	1715- Gr. Central Ave.
4+03.8	N	1719-1727- Gr. Central Ave.
4+54.5	S	1804- Gr. Central Ave.
5+05.5	S	1806- Gr. Central Ave.
5+56.0	S	1808- Gr. Central Ave.
7+81.4	N	1903- Gr. Central Ave.
7+81.4	S	1904- Gr. Central Ave.
8+31.0	N	1905- Gr. Central Ave.
8+71.5	S	1908- Gr. Central Ave.
8+81.5	N	1907- Gr. Central Ave.
10+19.3	N	2001- Gr. Central Ave.
12+76.3	N	2019- Gr. Central Ave.

NOTE:

- Existing 8" & 12" san. sewers in Grand Central Ave. to be removed and replaced by 15" V.C. Pipe, and connections to the existing sewer to be reconnected to new sewer and all existing manholes to be removed and new manholes to be built as shown.
- All new 6" V.C. house connections on South side of street to be installed from new sewer to property line. Existing 4" house connections on South side of street to be removed and replaced with 6" V.C. pipe from new sewer to property line. All new 6" V.C. house connections on North side of street to be plugged at sewer. Existing 4" house connections on North side of street to be reconnected to new sewer, using 4"x6" V.C. increaser at end of undisturbed house connections.

3. Pavement to be replaced with 8-inch shell base and 2-inch cold-mix asphalt immediately after backfilling of trench. After final settlement occurs the surface is to be brought to original crown and cross-section with asphaltic concrete. Payment for the shell base and all asphaltic surfacing will be made under Contract Item 17d and 17b, respectively.

CITY OF TAMPA, FLORIDA
SEWER IMPROVEMENTS

GRAND CENTRAL AVENUE - REHABILITATION -

R-6





DES: A.T.W.
DP: A.T.W.
CKD: W.W.S.
DATE: AUG. 1951

SCALE
0 50 100 1"=50'

SHEET
16
OF 18

Note: See File No. 21-C

27-17

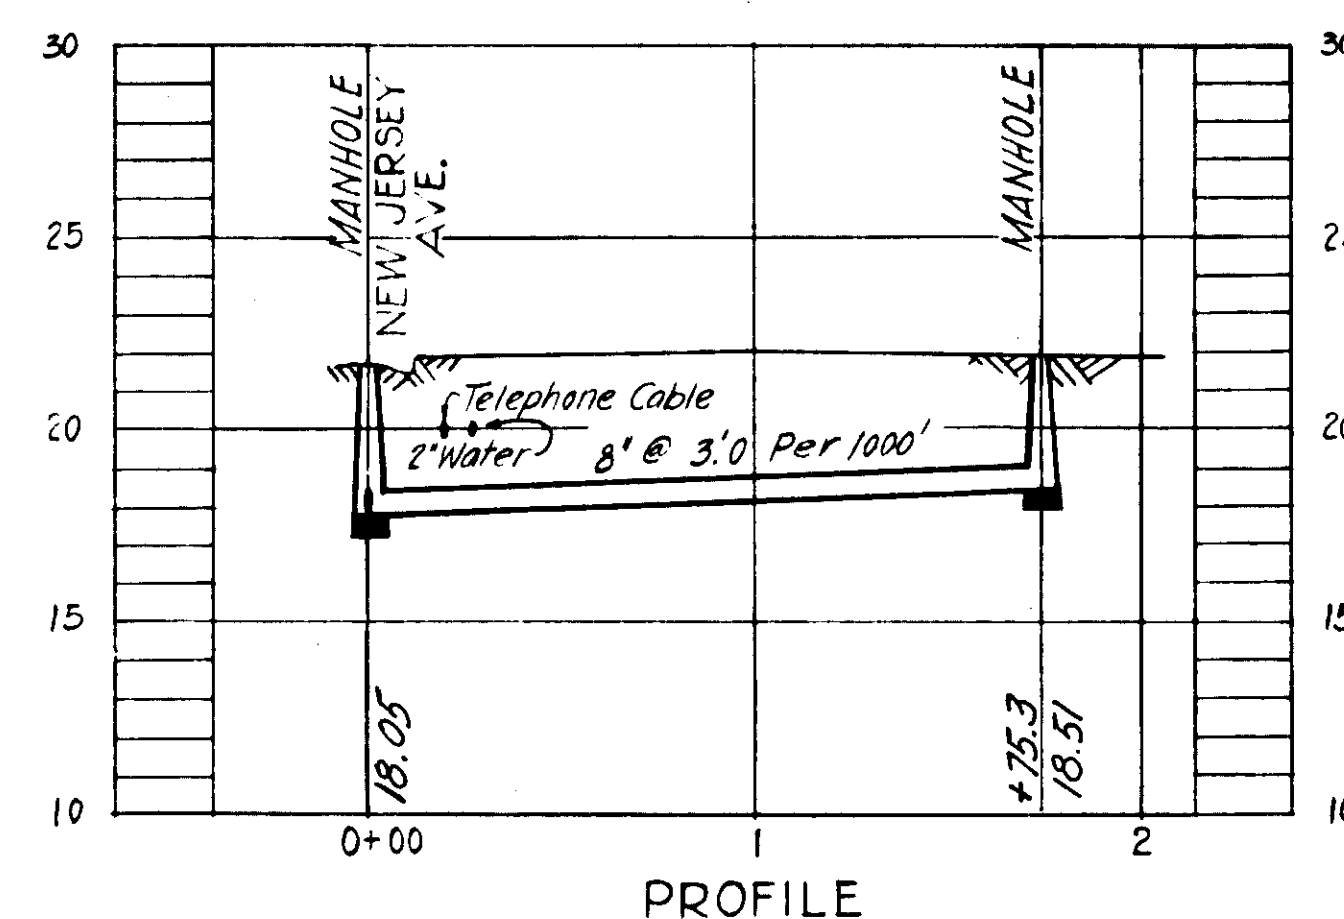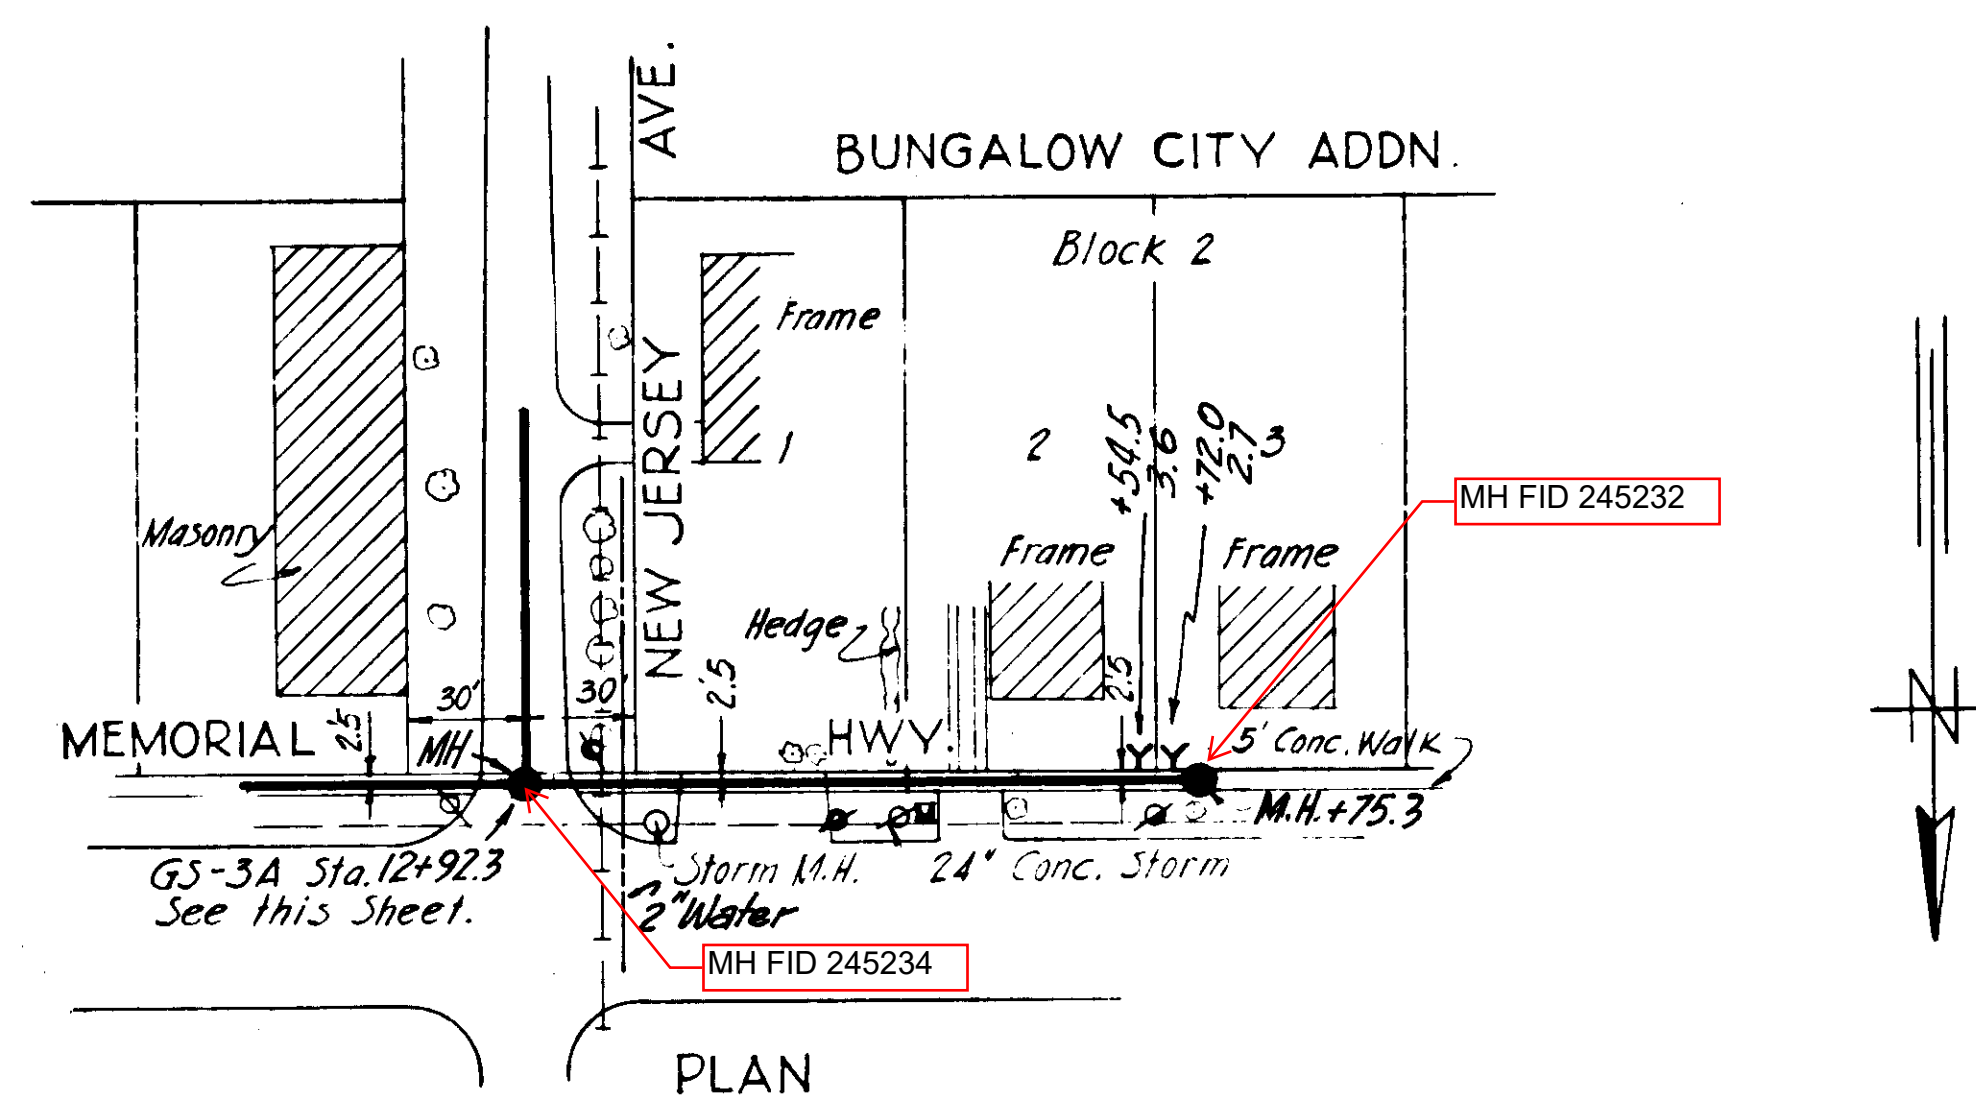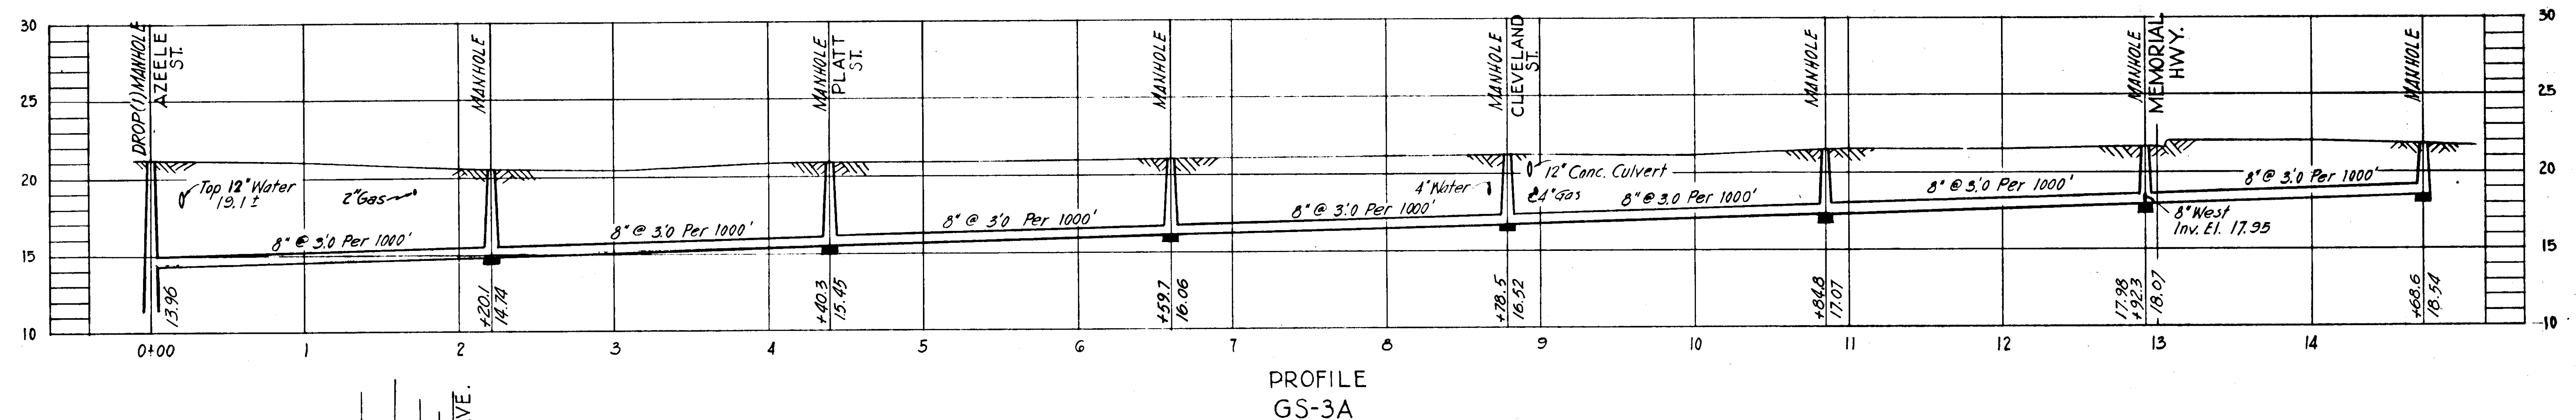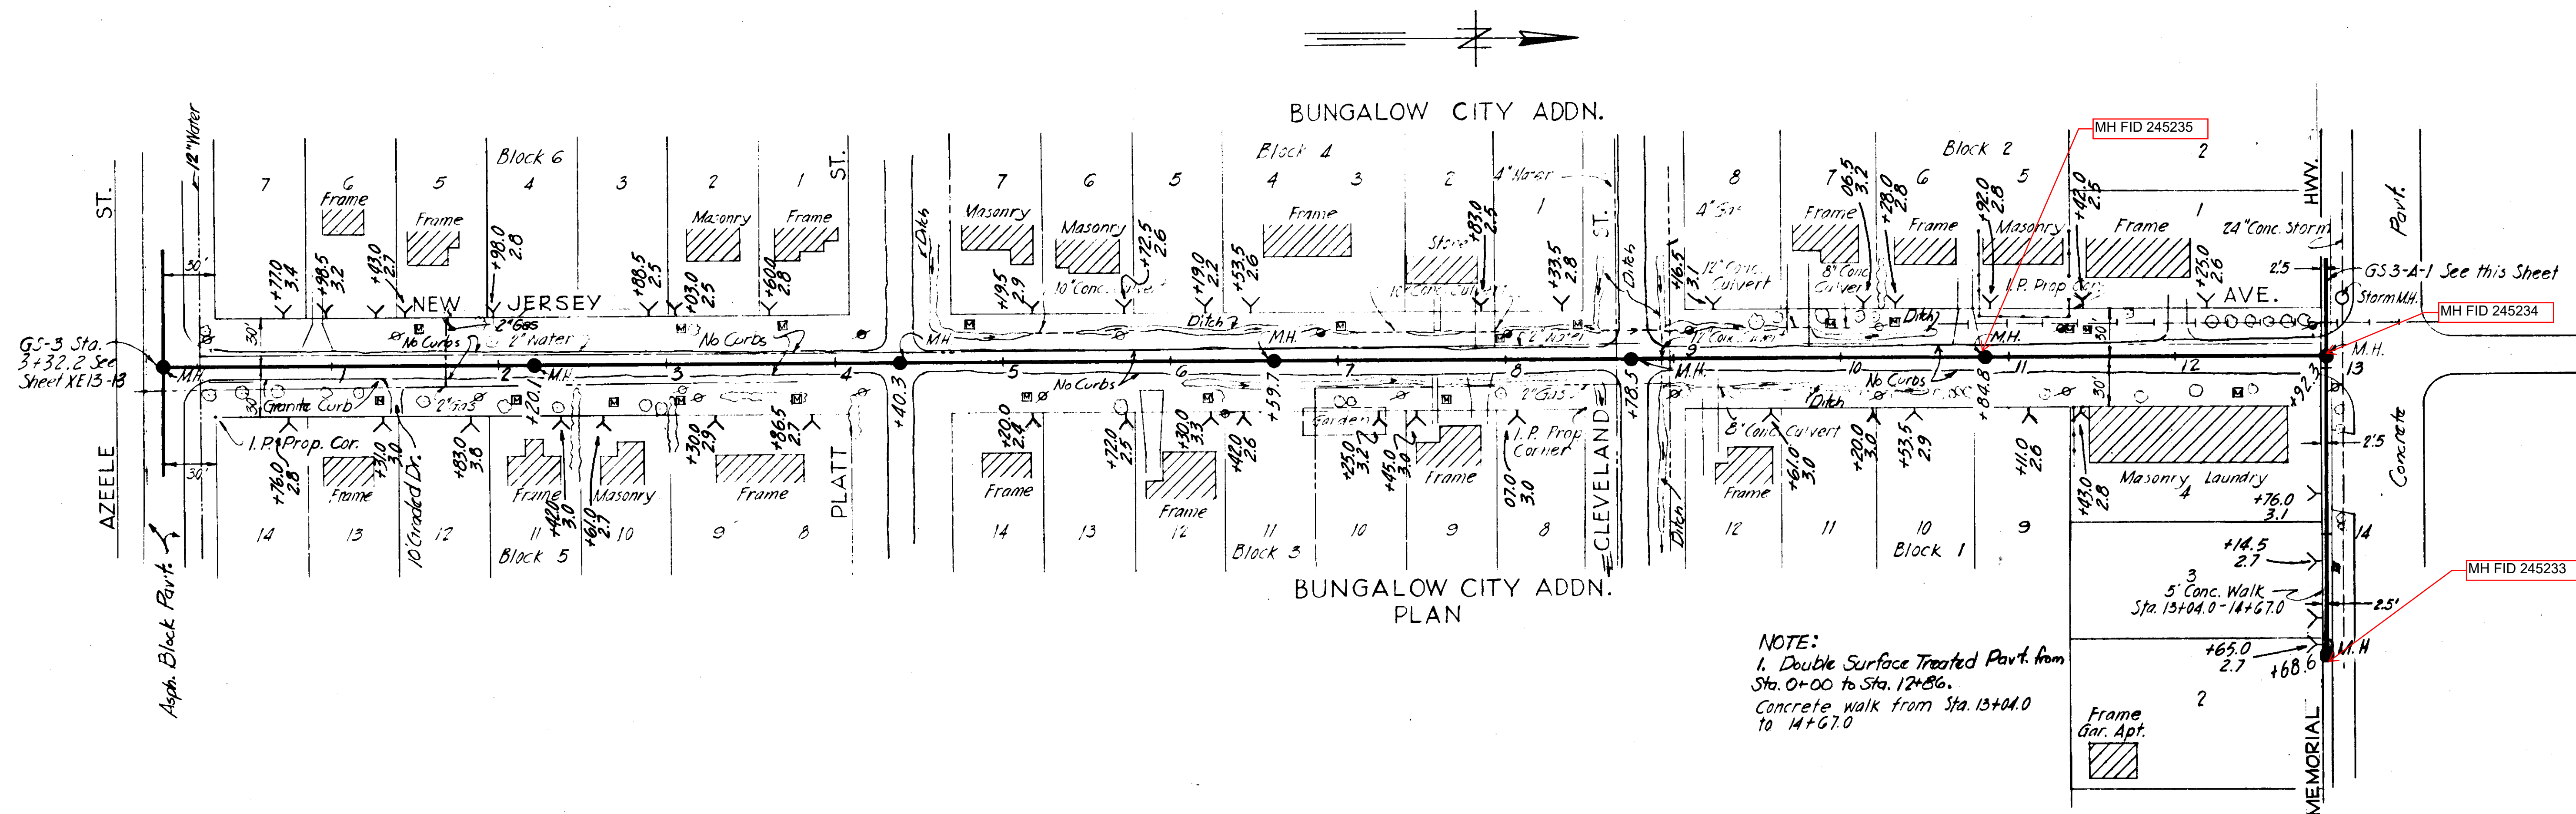

AS-BUILT PLAN
Revised to show actual conditions according to construction records as of (R.V.I. 5-9-56)

CITY OF TAMPA, FLORIDA
SEWER IMPROVEMENTS
DIVISION XI13

GS-3A & GS-3A-I






GREELEY AND HANSEN
ENGINEERS
CHICAGO, ILL.

DES. E.C.A.
DR. E.C.A.
CKD. E.E.S.
DATE:
NOV. 1954

SCALE
50 0 50 100 1"=50'

SHEET
XI13-15
OF 30

62-15

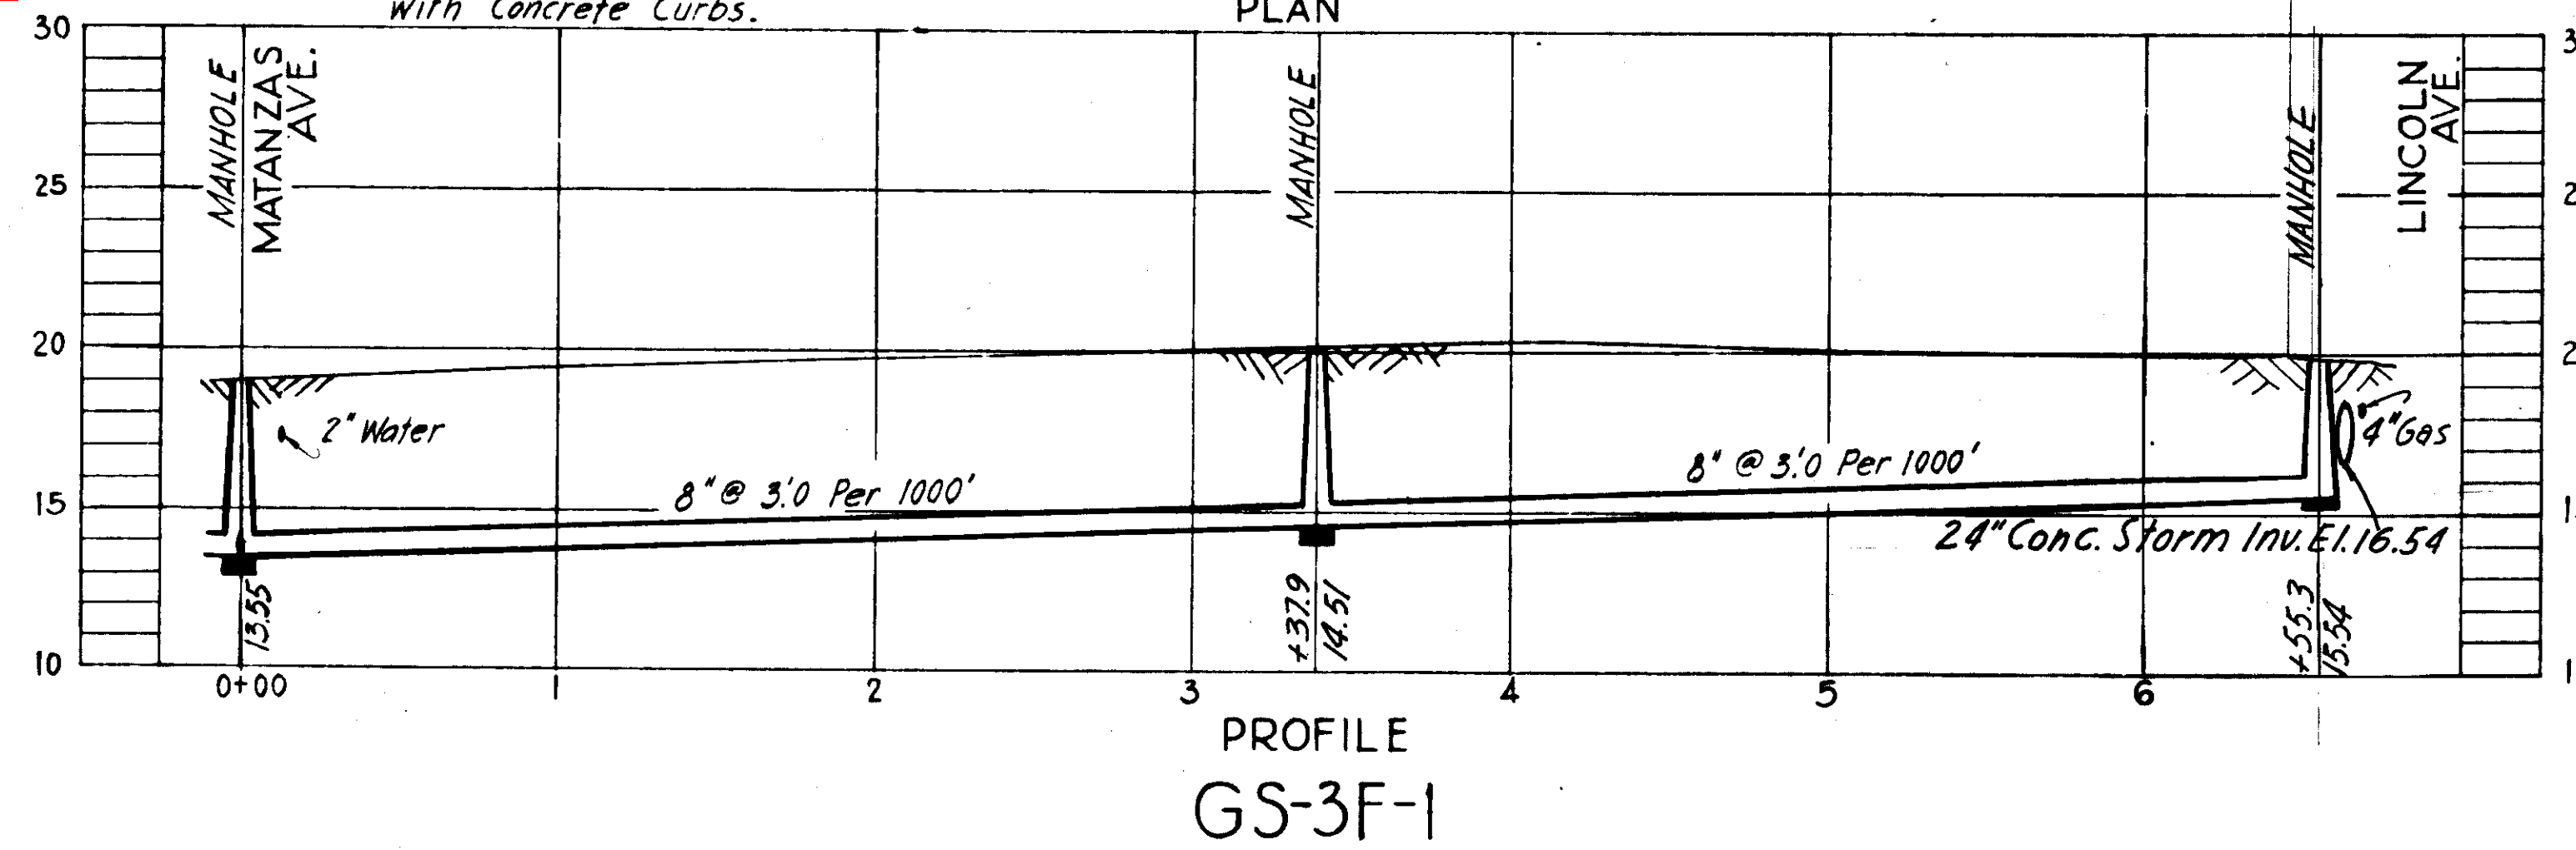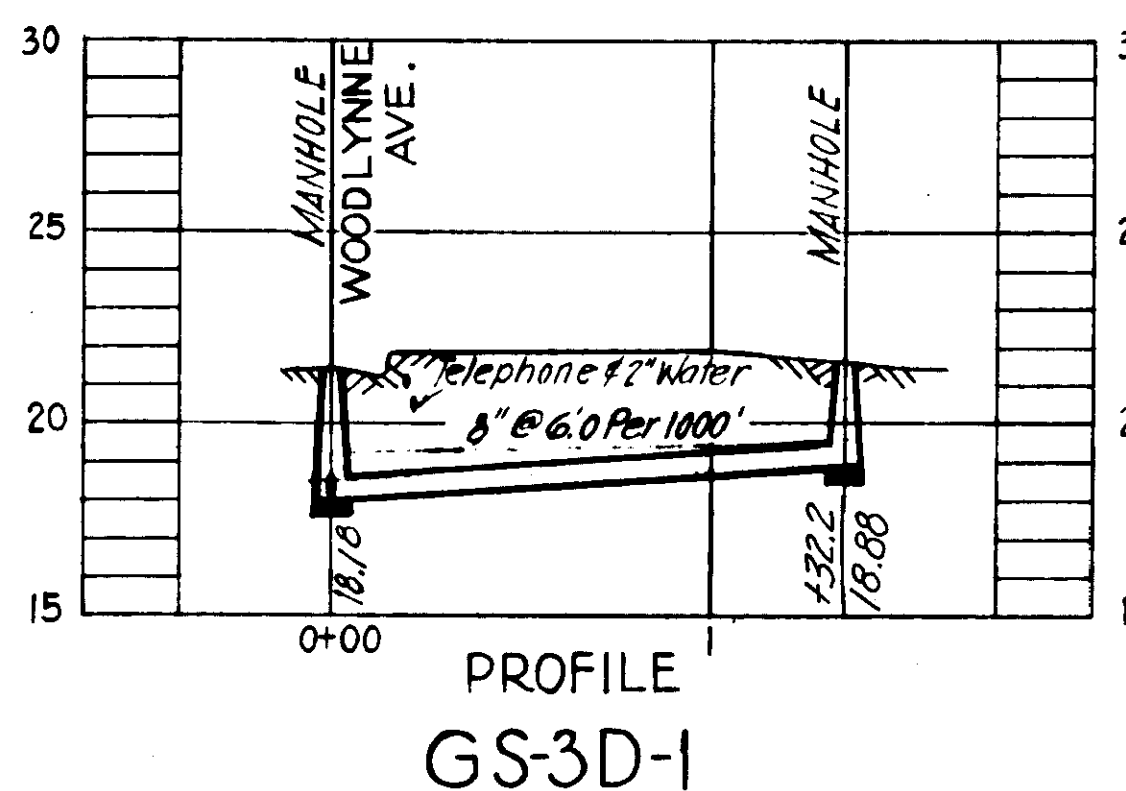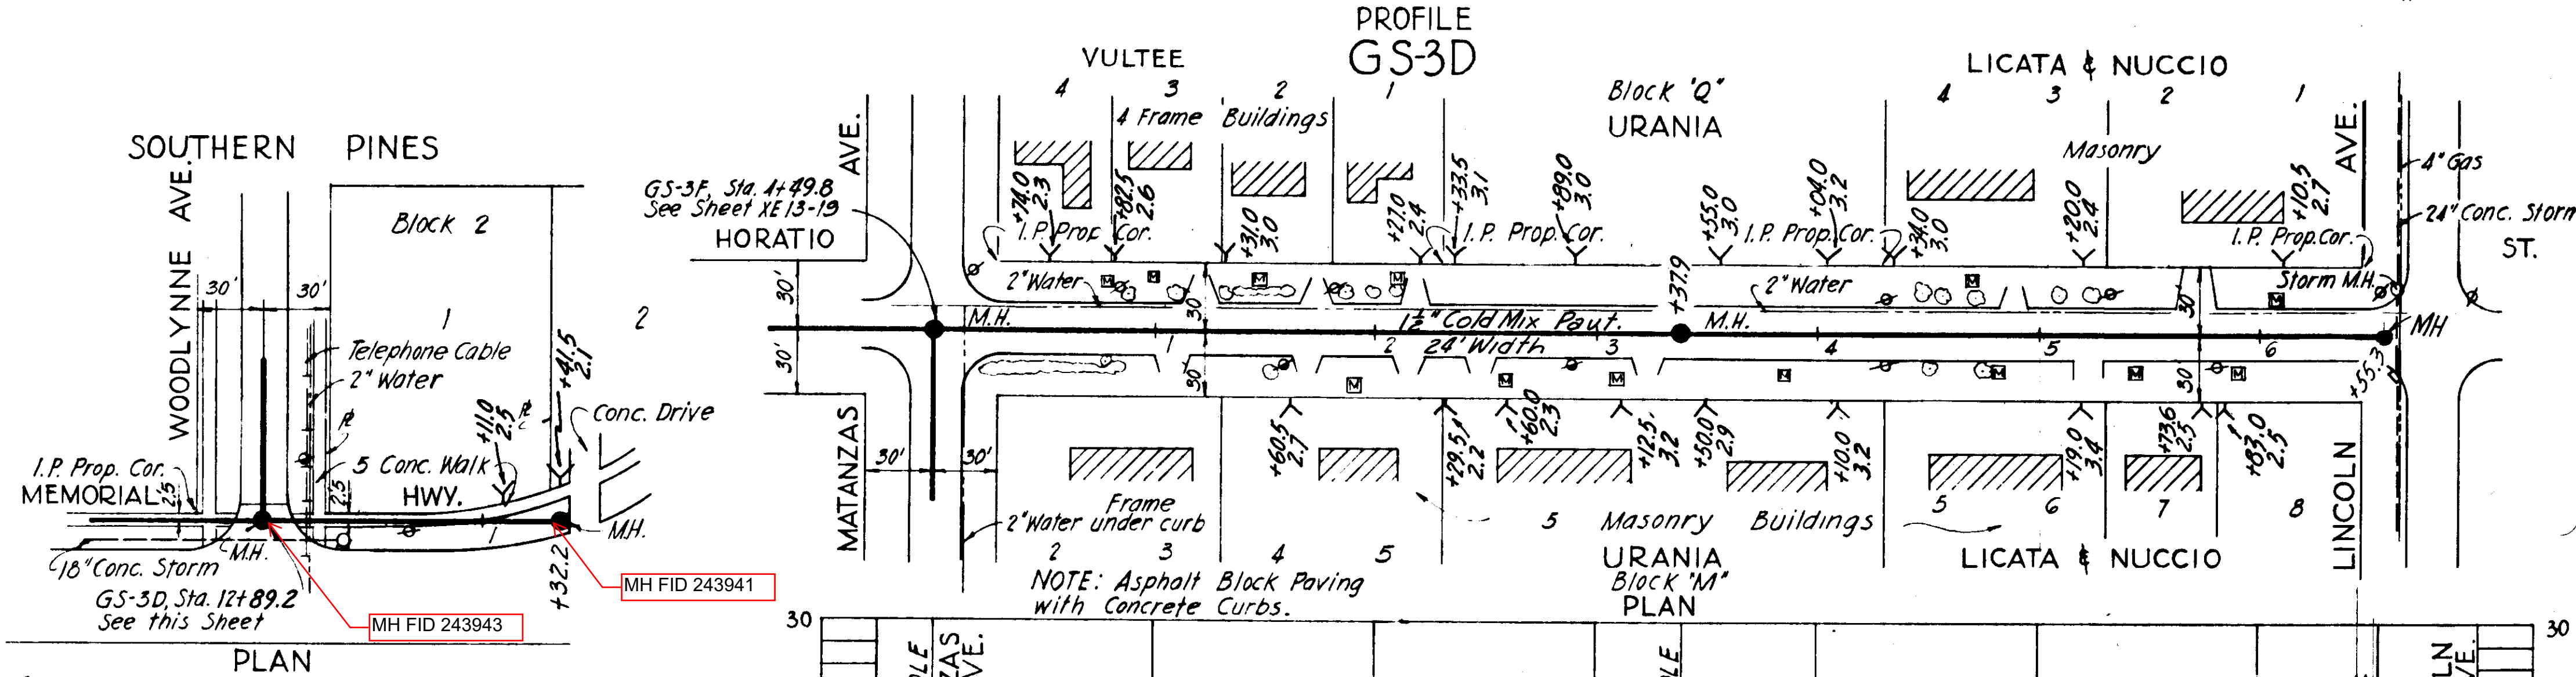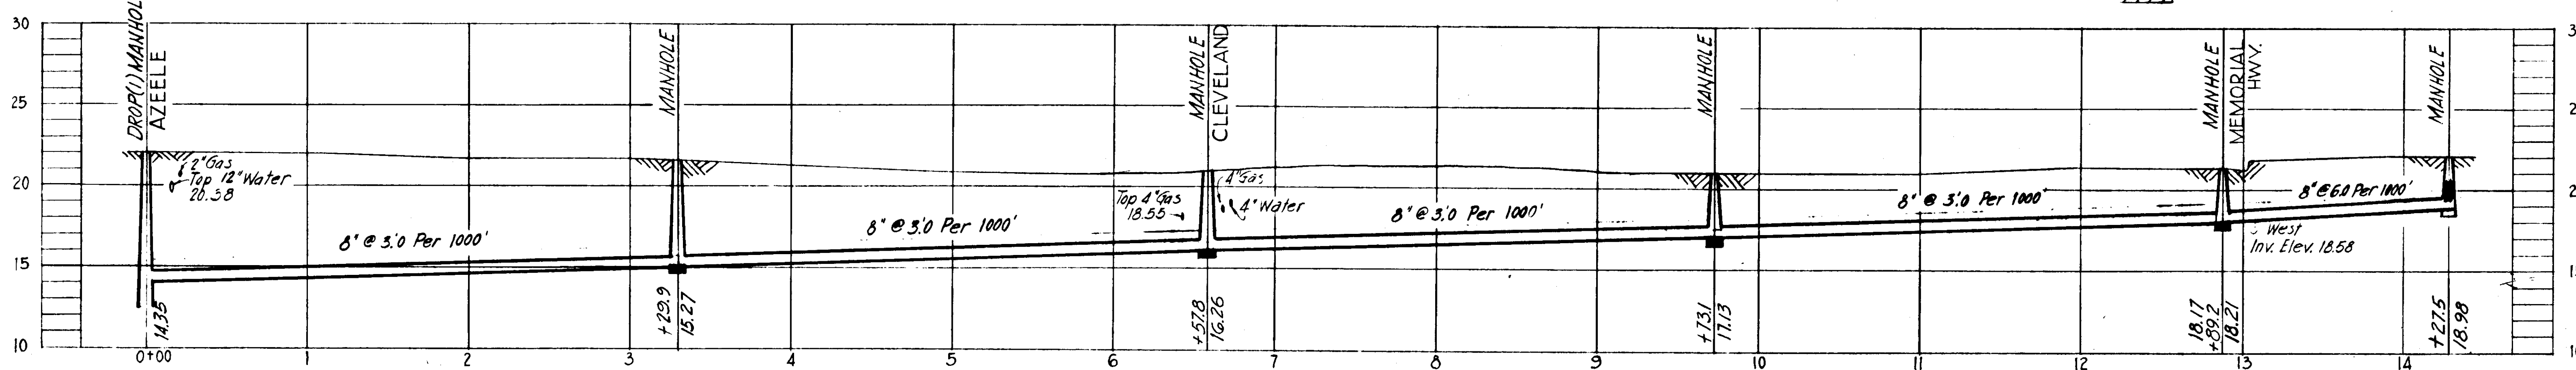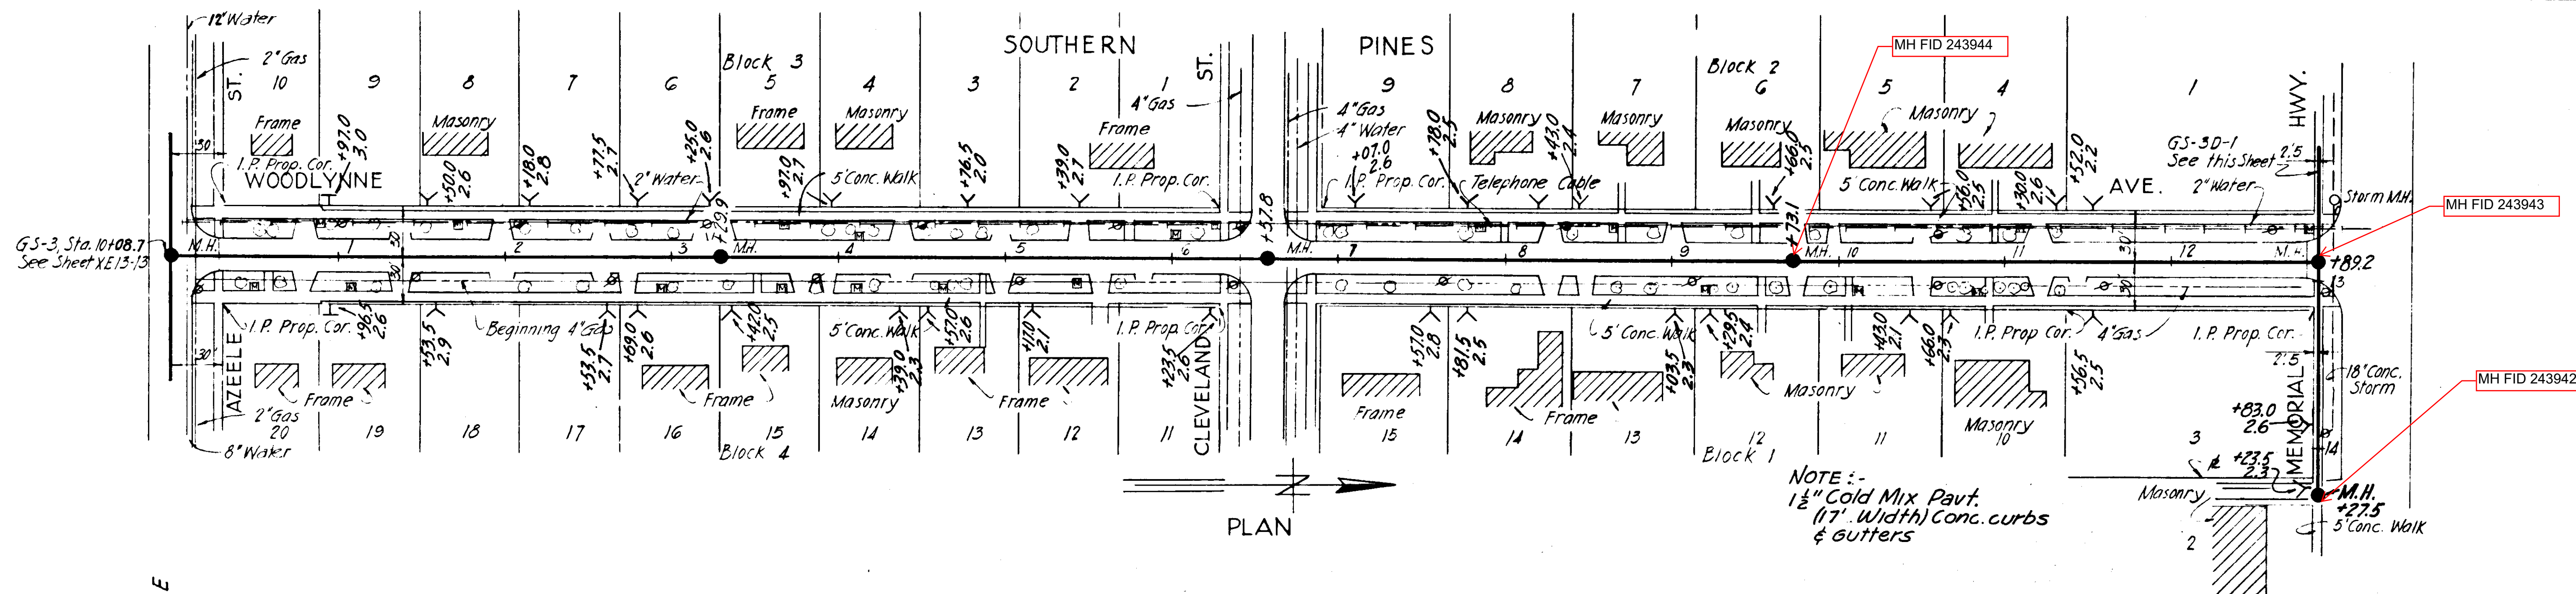

AS-BUILT PLAN
Revised to show actual conditions according to construction record as of (REV. 5-14-56)

CITY OF TAMPA, FLORIDA
SEWER IMPROVEMENTS
DIVISION XE13

GS-3D, GS-3D-1 & GS-3F-1

DES. E.C.A.
DR. E.C.A.
CKD. E.E.S
DATE:
NOV. 1954



SCALE
50 0 50 100
1" = 50'

SHEET
XE13-17
OF 30

GREELEY AND HANSEN
ENGINEERS
CHICAGO, ILL.

FINAL SURVEY		BY	DATE
NOTE BOOK			
	SURVEYED		
	PLOTTED		
	TEMPLATE		
	AREAS		
	AREAS CHECKED		

ORIGINAL SURVEY	BY _____		DATE _____
	SURVEYED _____ PLOTTED _____ TEMPLATE _____ AREAS _____ AREAS CHECKED _____		

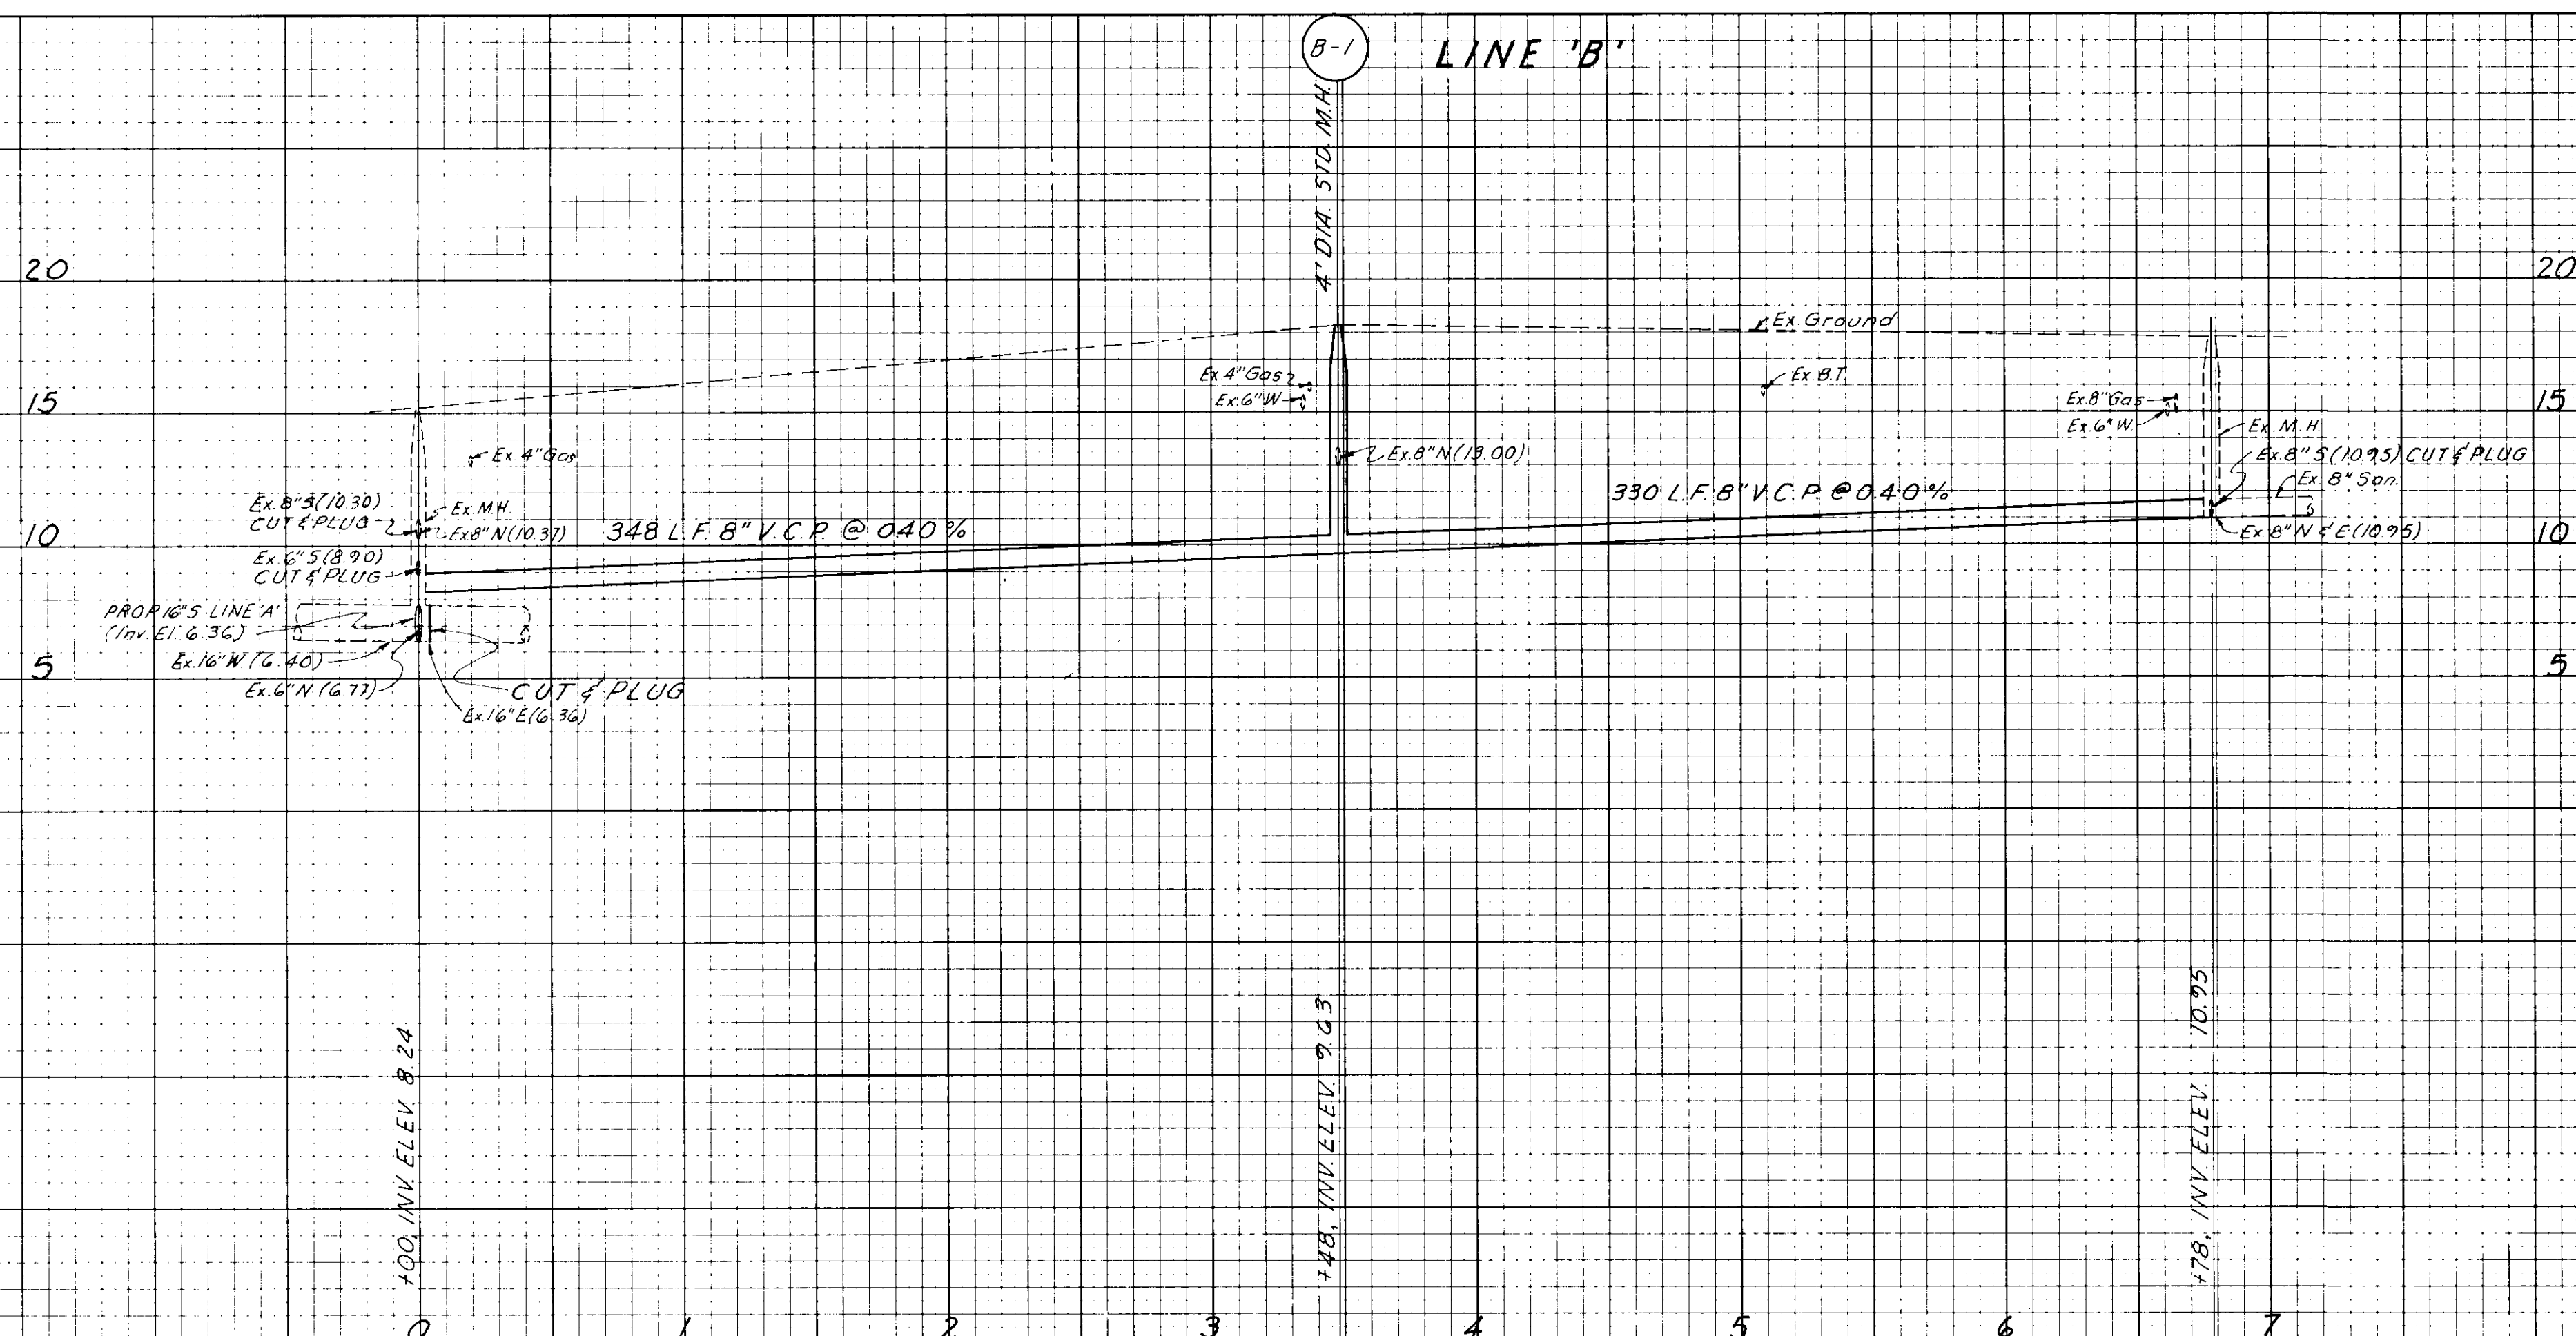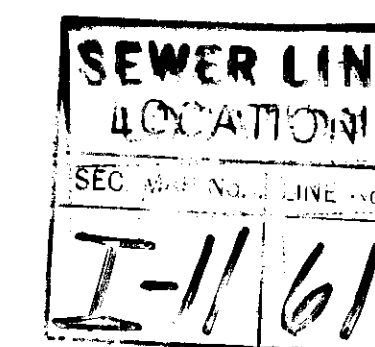



AS BUILT

140-4


FINAL SURVEY NOTE BOOK	SURVEYED _____	BY _____	DATE _____
	PLOTTED _____		
	TEMPLATE _____		
	AREAS _____		
NO _____	AREAS CHECKED _____		

ORIGINAL SURVEY NOTE BOOK	SURVEYED _____	BY _____	DATE _____
	PLOTTED _____		
	TEMPLATE _____		
	AREAS _____		

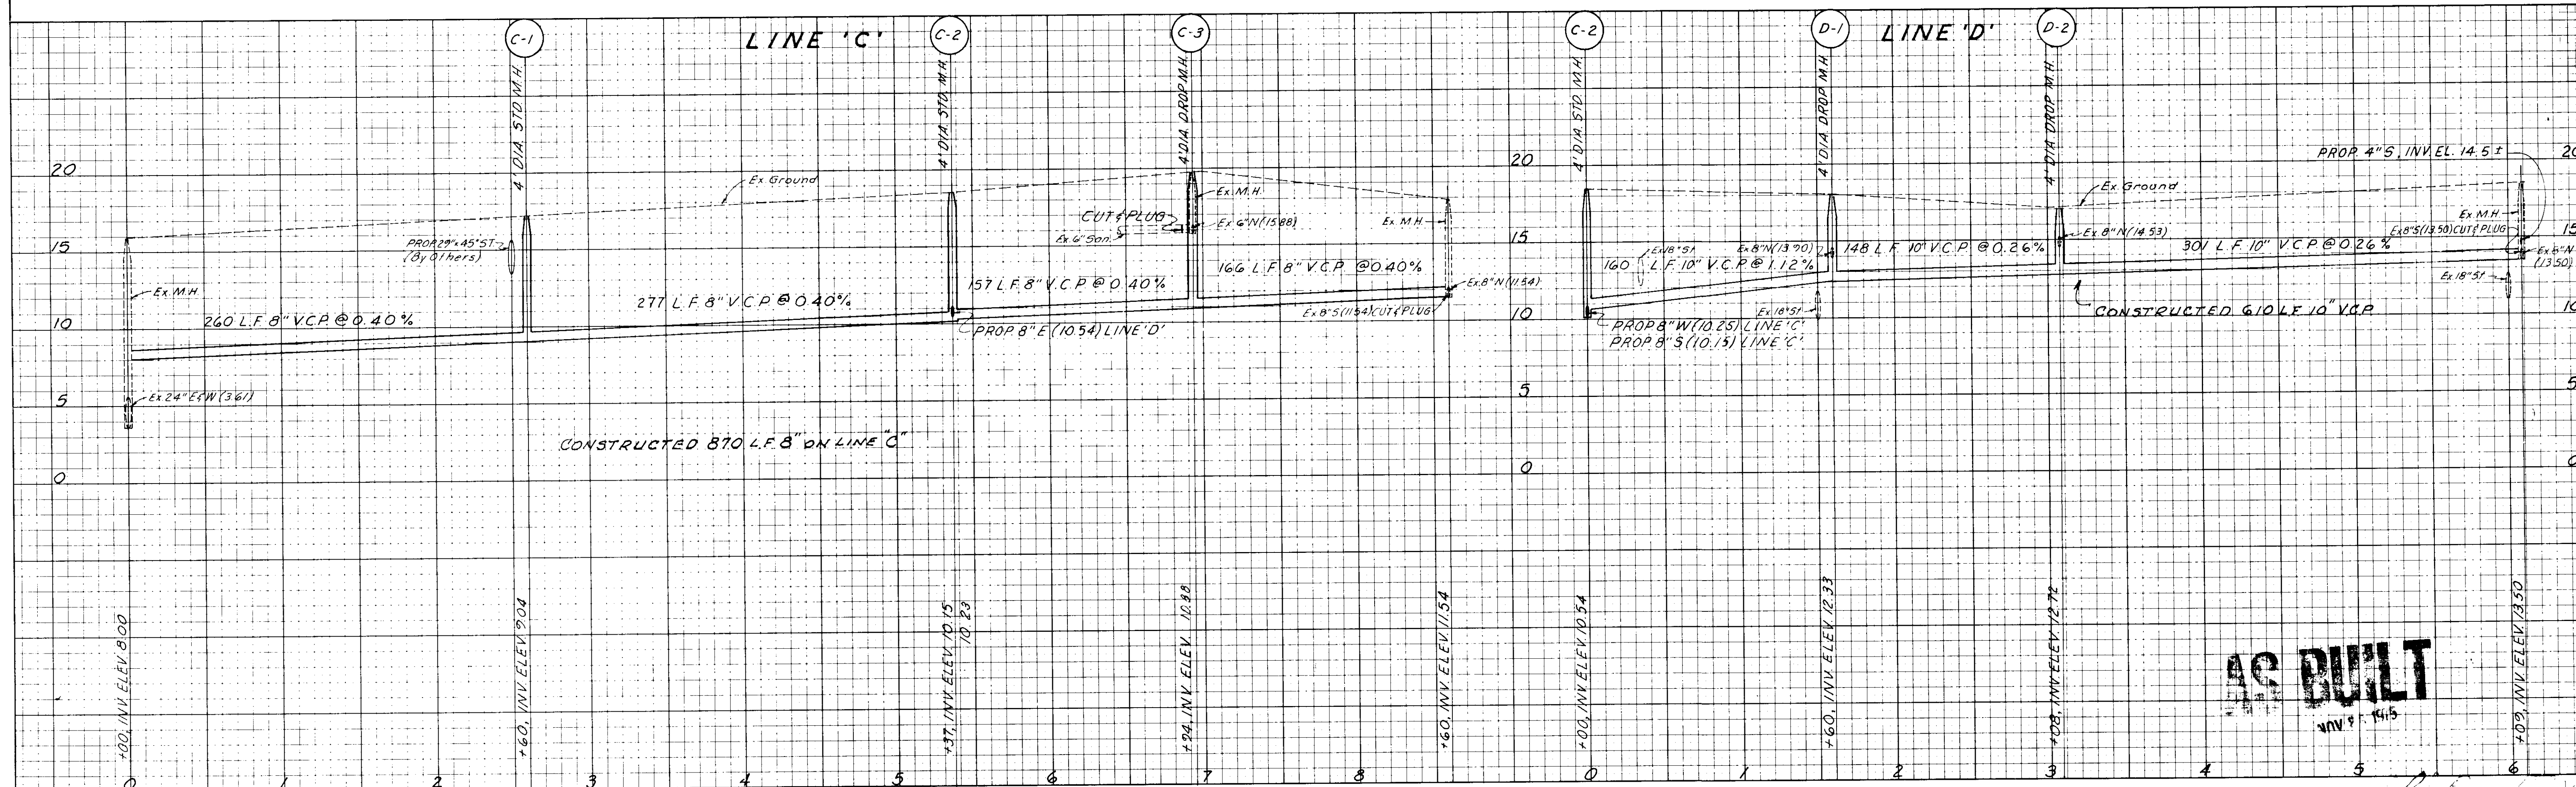

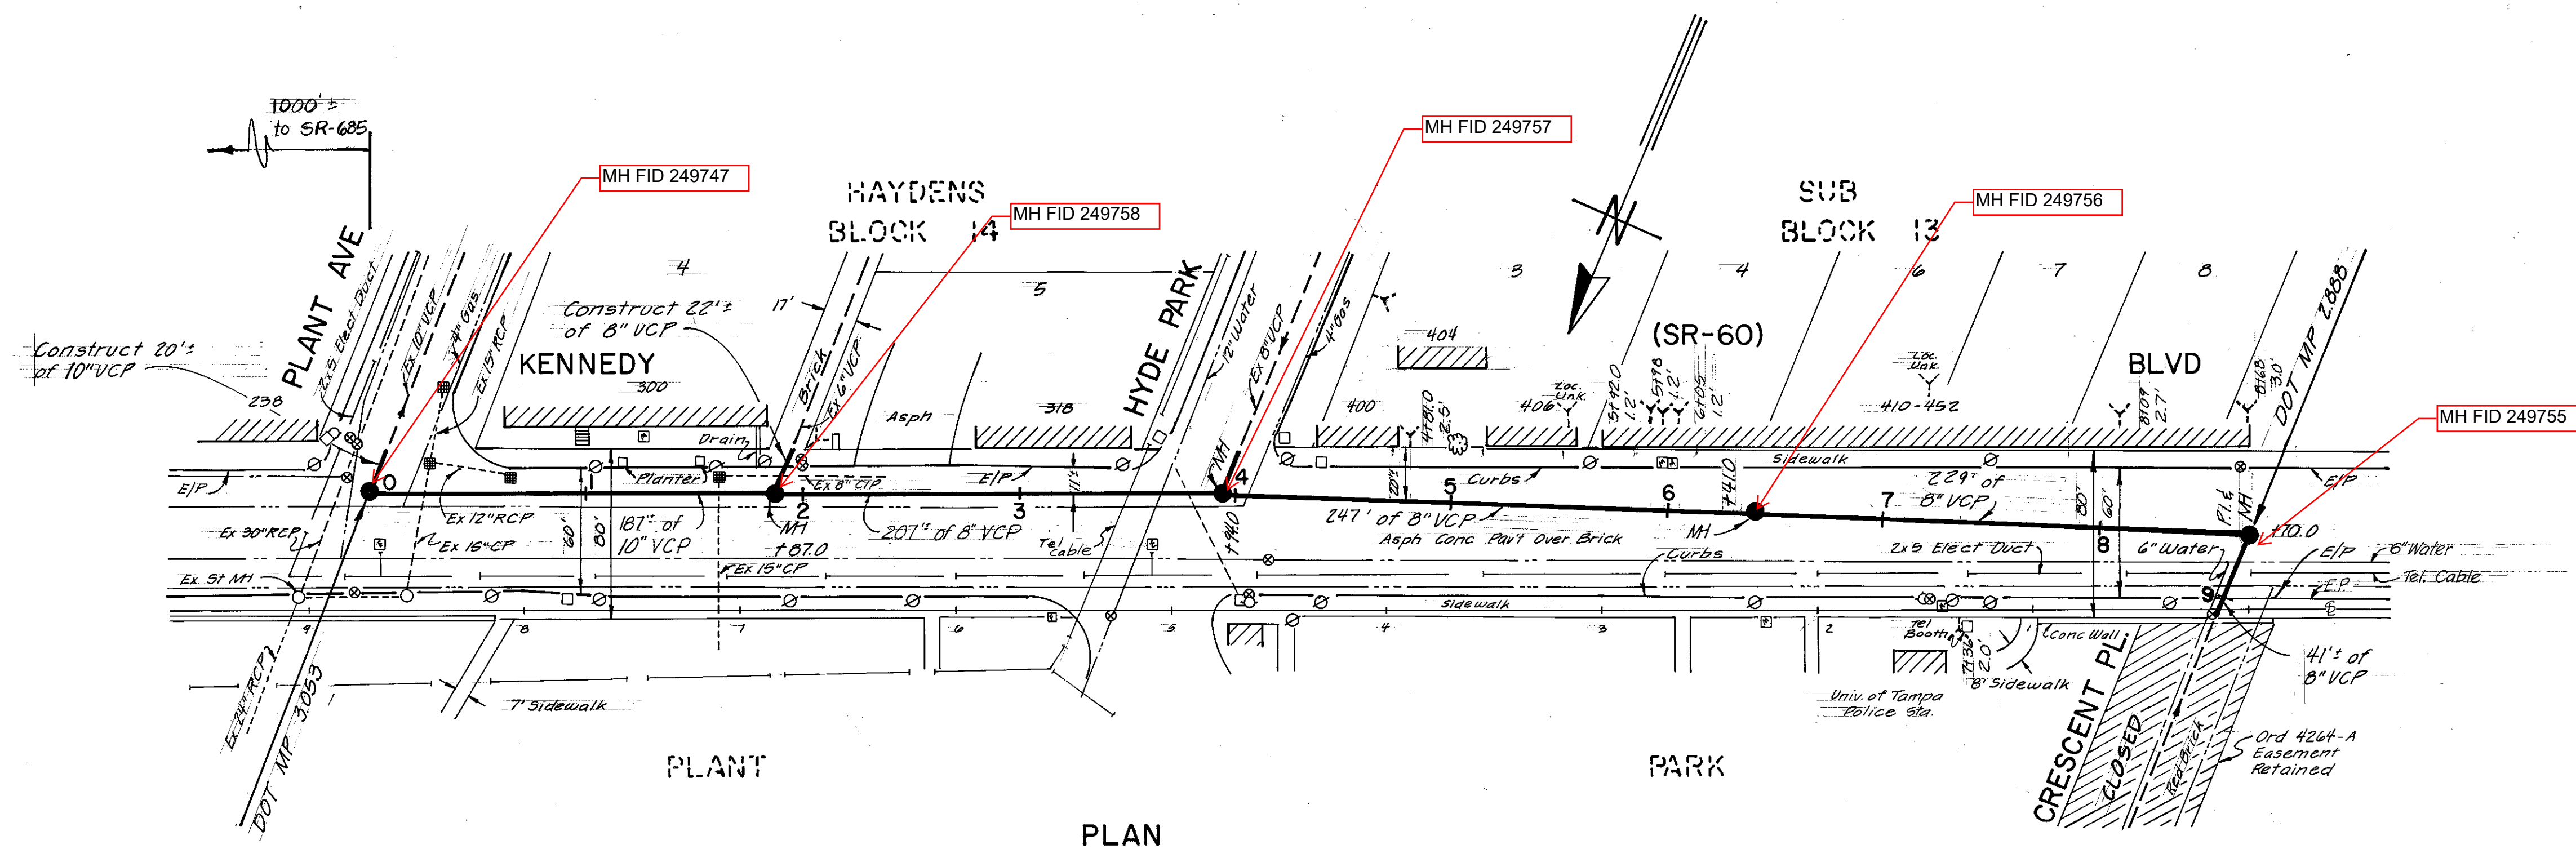


BM Elev 17.07
 Cut in SW @ SW corner
 Magnolia & J.F.K. @ N.E.
 corner Traffic Island.

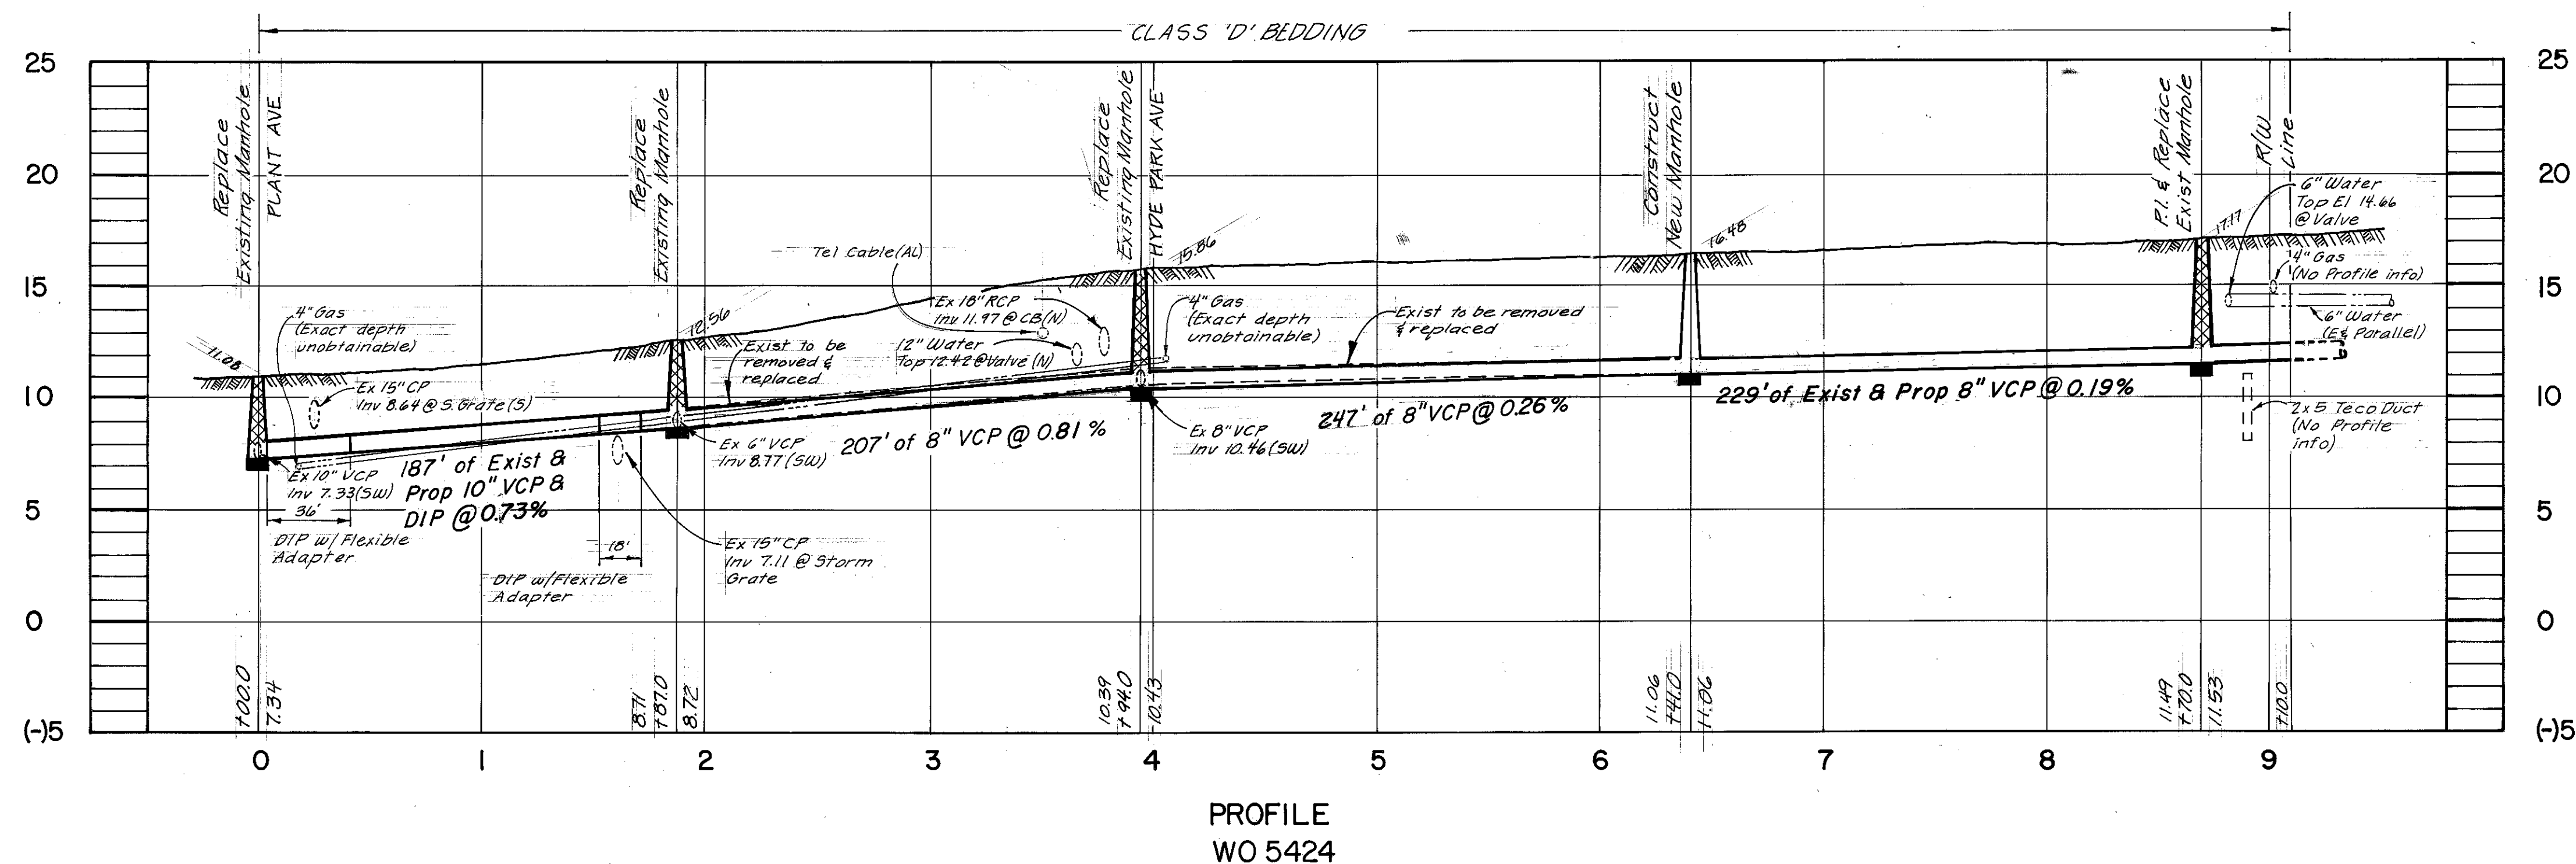

- NOTES:**
1. Location of existing underground utilities has been prepared from the most reliable information available. Verify the location and depth of all pertinent utilities prior to commencement of construction. Notify the utility companies at least 48 hours prior to beginning construction.
 2. Service connections shown in plan view are:
 a. representative locations of existing service connections of unknown locations.
 b. existing service connections (approximate locations shown)
 c. proposed service connections
 3. Many inactive service connections may exist. Replace in place only those service connections that are active unless directed by Fred Townsend at the time of construction. The Inspector and the Contractor will jointly determine which service connections are active.
 4. Compaction to be done to D.O.T. specifications.
 5. Disturbed pavement to be replaced in accordance with Section 125-9 of the D.O.T. spec.
 6. Existing lines to be rebuilt at existing slope to the limits of D.O.T. R/W and reconnected to existing lines.


AS BUILT

I-12

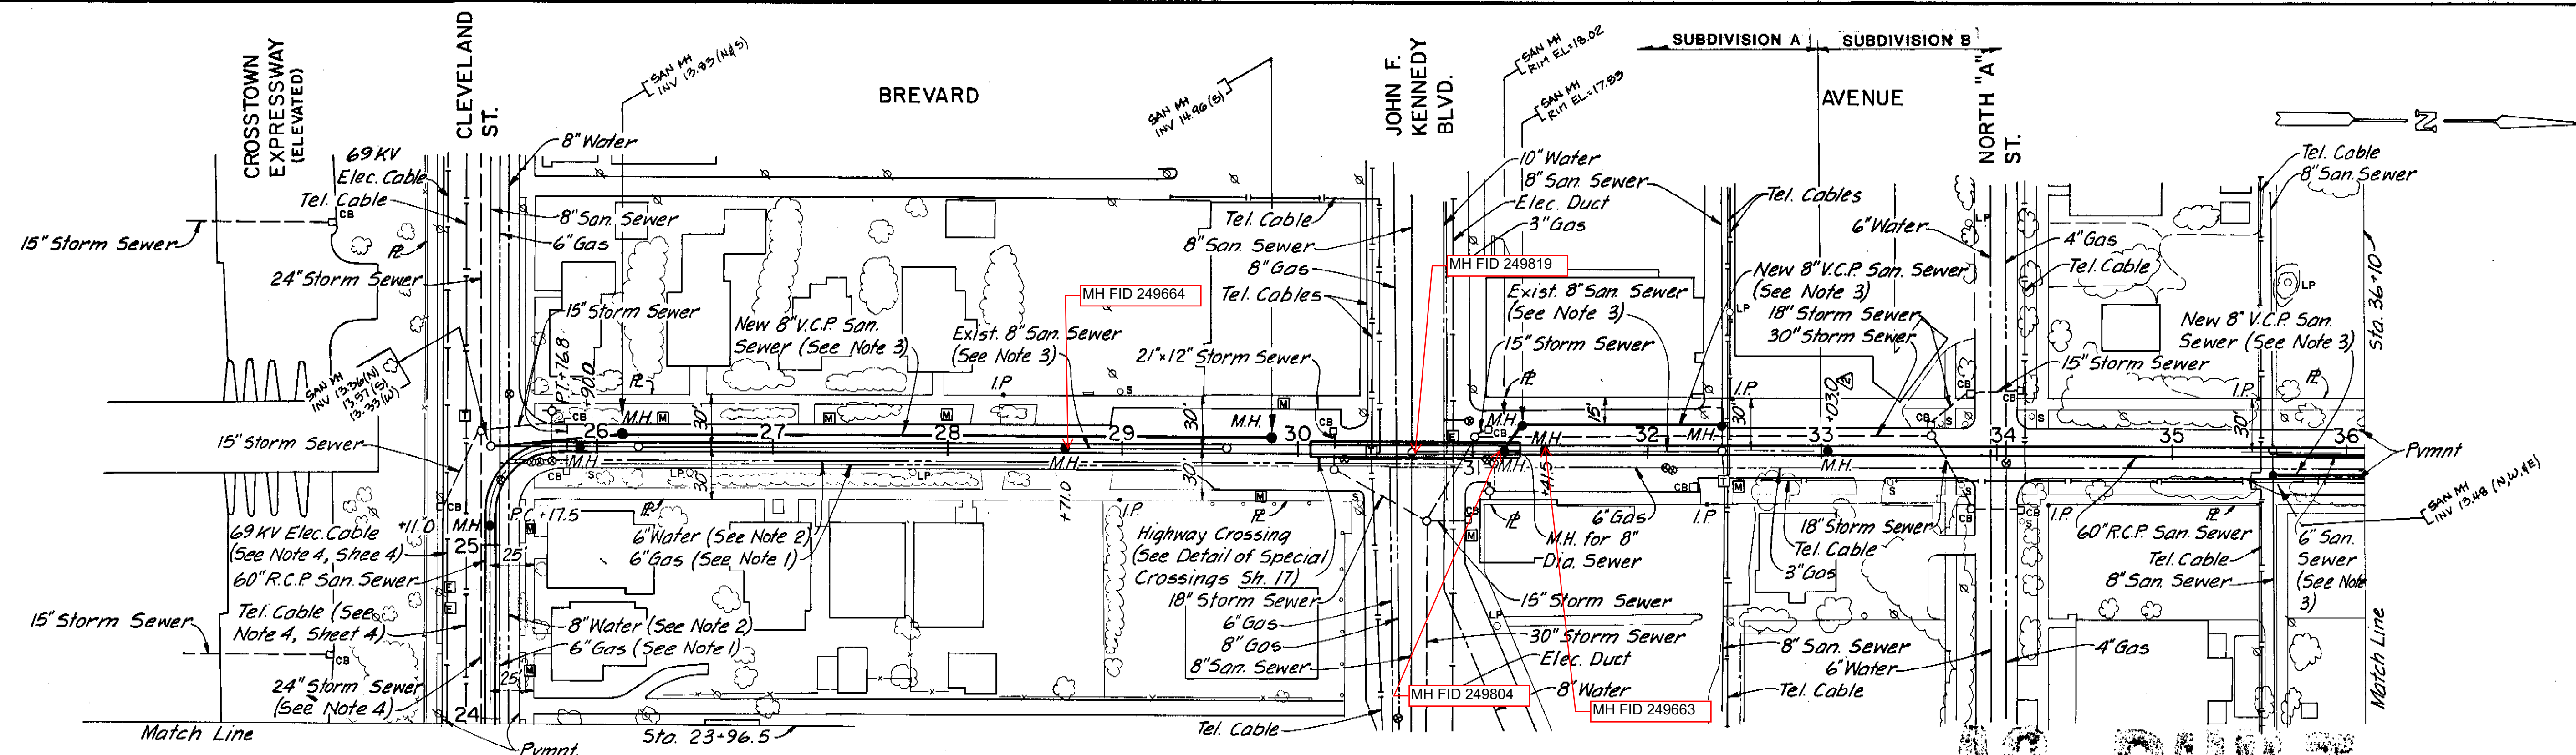

PLAN

Existing Pavement: Red Brick



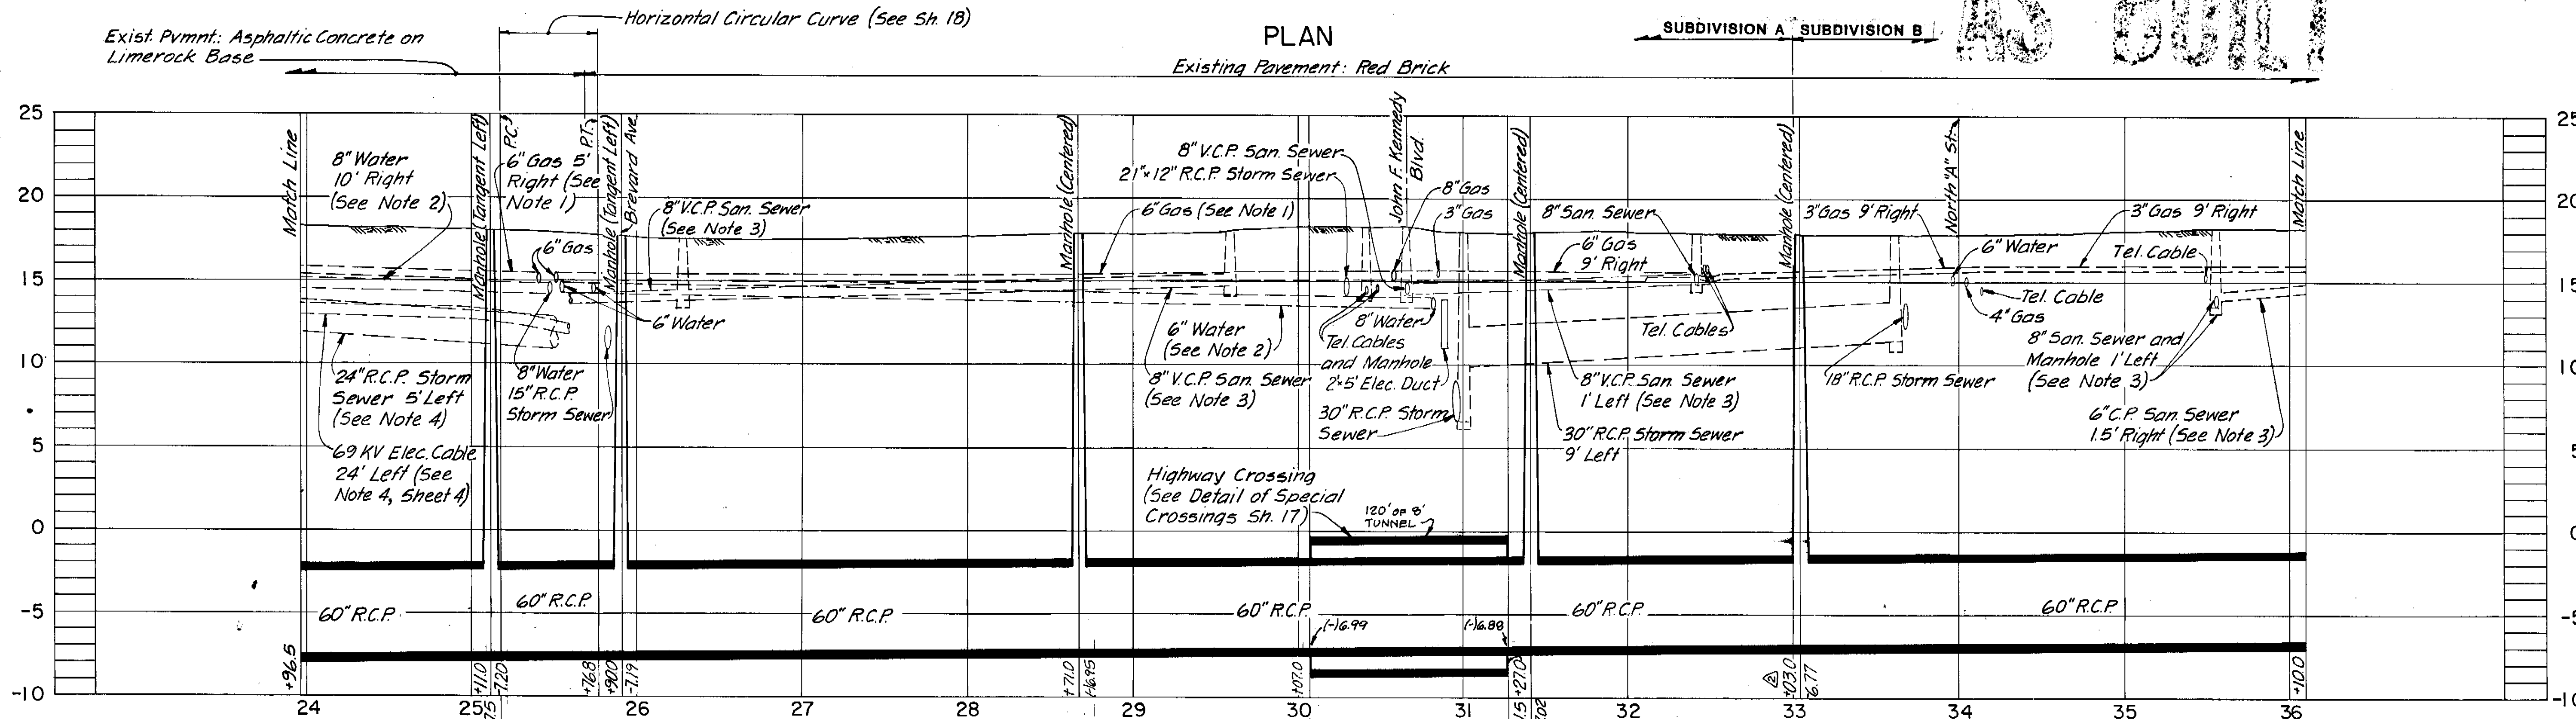


PROFILE


- NOTES:
- 6" Gas mains in Cleveland St. and Brevard Ave. to be relocated by others.
 - Contractor shall remove and relocate existing 8" water in Cleveland St. from Sta. 23+96.5 to 25+50[±] and 6" water in Brevard Ave. from Sta. 25+50[±] to Sta. 30+10[±] as directed by the Engineer to permit construction of the new 60" diameter sanitary sewer.
 - Contractor shall remove existing 8" and 6" diameter sanitary sewers and manholes from Sta. 25+50[±] to Sta. 29+60[±], from Sta. 31+15[±] to 32+42[±], and from Sta. 35+55[±] to Sta. 36+10[±] as required to permit construction of the new 60" diameter sanitary sewer and shall construct new 8" diameter V.C.P. replacement sanitary sewer and manholes at original elevations in the locations shown. All existing lateral sewers and house laterals shall be connected to the new 8" replacement sewer. Contractor shall maintain continuous sanitary sewer service during construction by approved temporary methods.
 - Contractor shall remove and replace existing 24" storm sewer from Sta. 23+96.5 to Sta. 25+30[±] and 30" and 18" storm sewers and manhole from Sta. 31+25[±] to Sta. 33+70[±] as required to permit construction of the new 60" R.C.P. San. Sewer.

SUBDIVISIONS A AND B

GREELEY AND HANSEN ENGINEERS 1211 NORTH WEST SHORE BLVD. TAMPA, FLORIDA 33607	DESIGNED RSH	APPROVED			SCALE 50 0 50 100 FT HORIZ. 1" = 50' 5 0 5 10 VERT. 1" = 5'	CITY OF TAMPA, FLORIDA SEWAGE DISPOSAL SYSTEM WEST RIVER INTERCEPTING SEWER REPLACEMENT	DIVISION B1-B PLAN AND PROFILE STA. 23+96.5 TO STA. 36+10	PROJ. NO. 2023-400-02-23	
	DRAWN AA	DATE	SHEET 5 OF 22						
	CHECKED TLW	SUPT., DEPT. OF SANITARY SEWERS							
		DATE							
GREELEY AND HANSEN, ENGINEERS		NO.	DATE	APP.	REVISION				

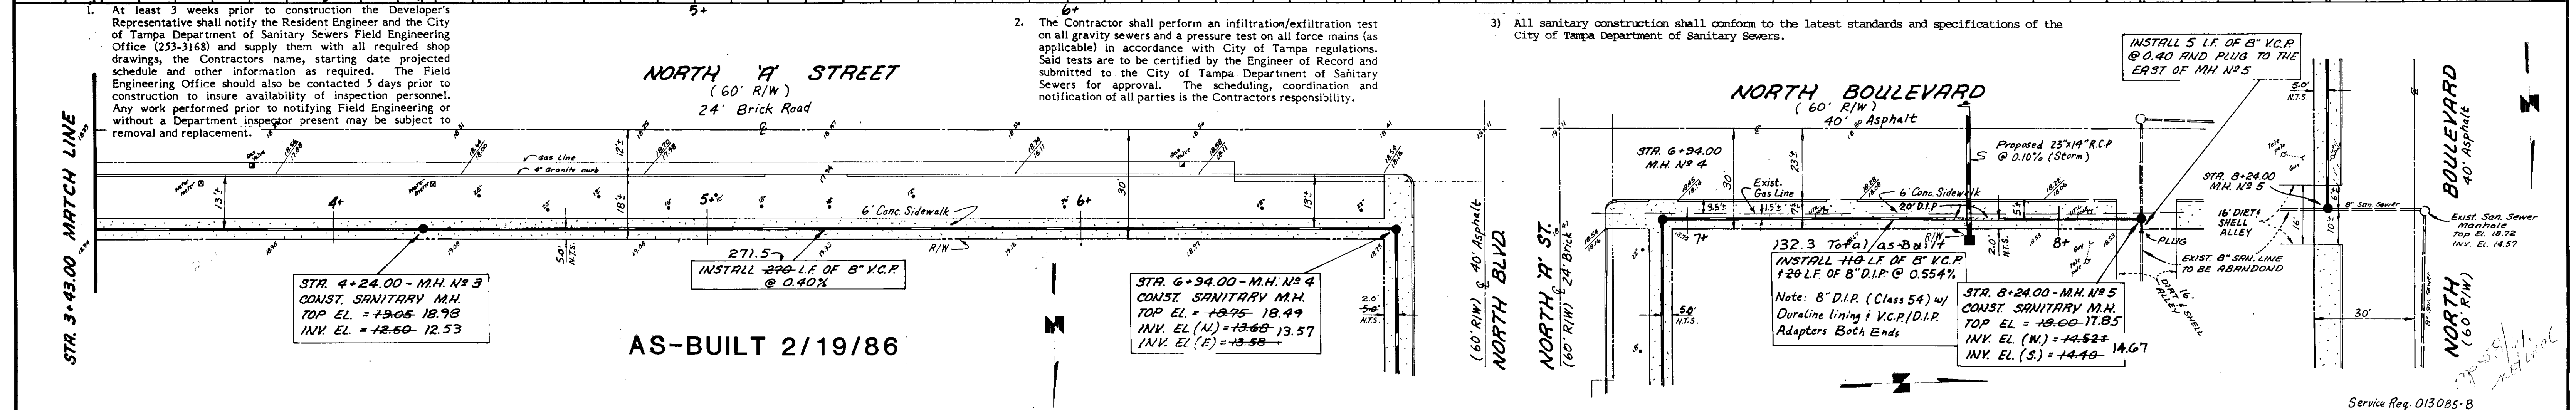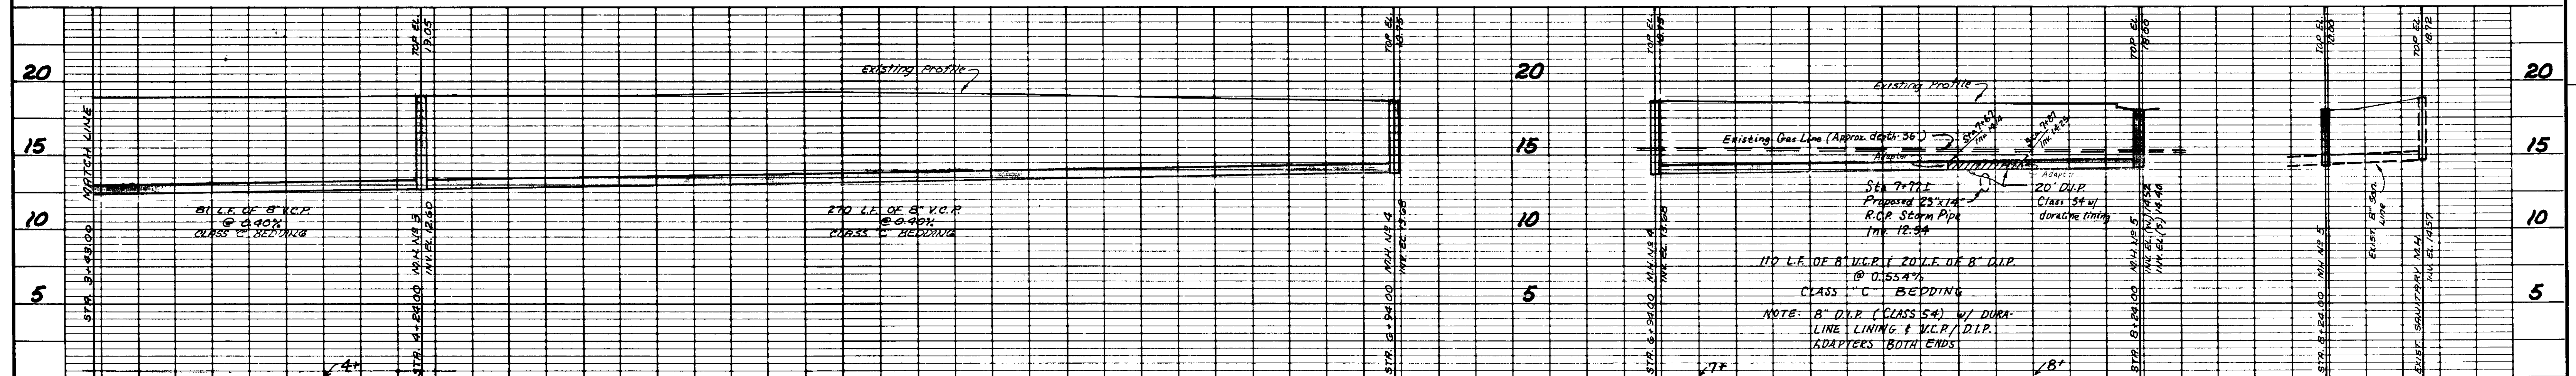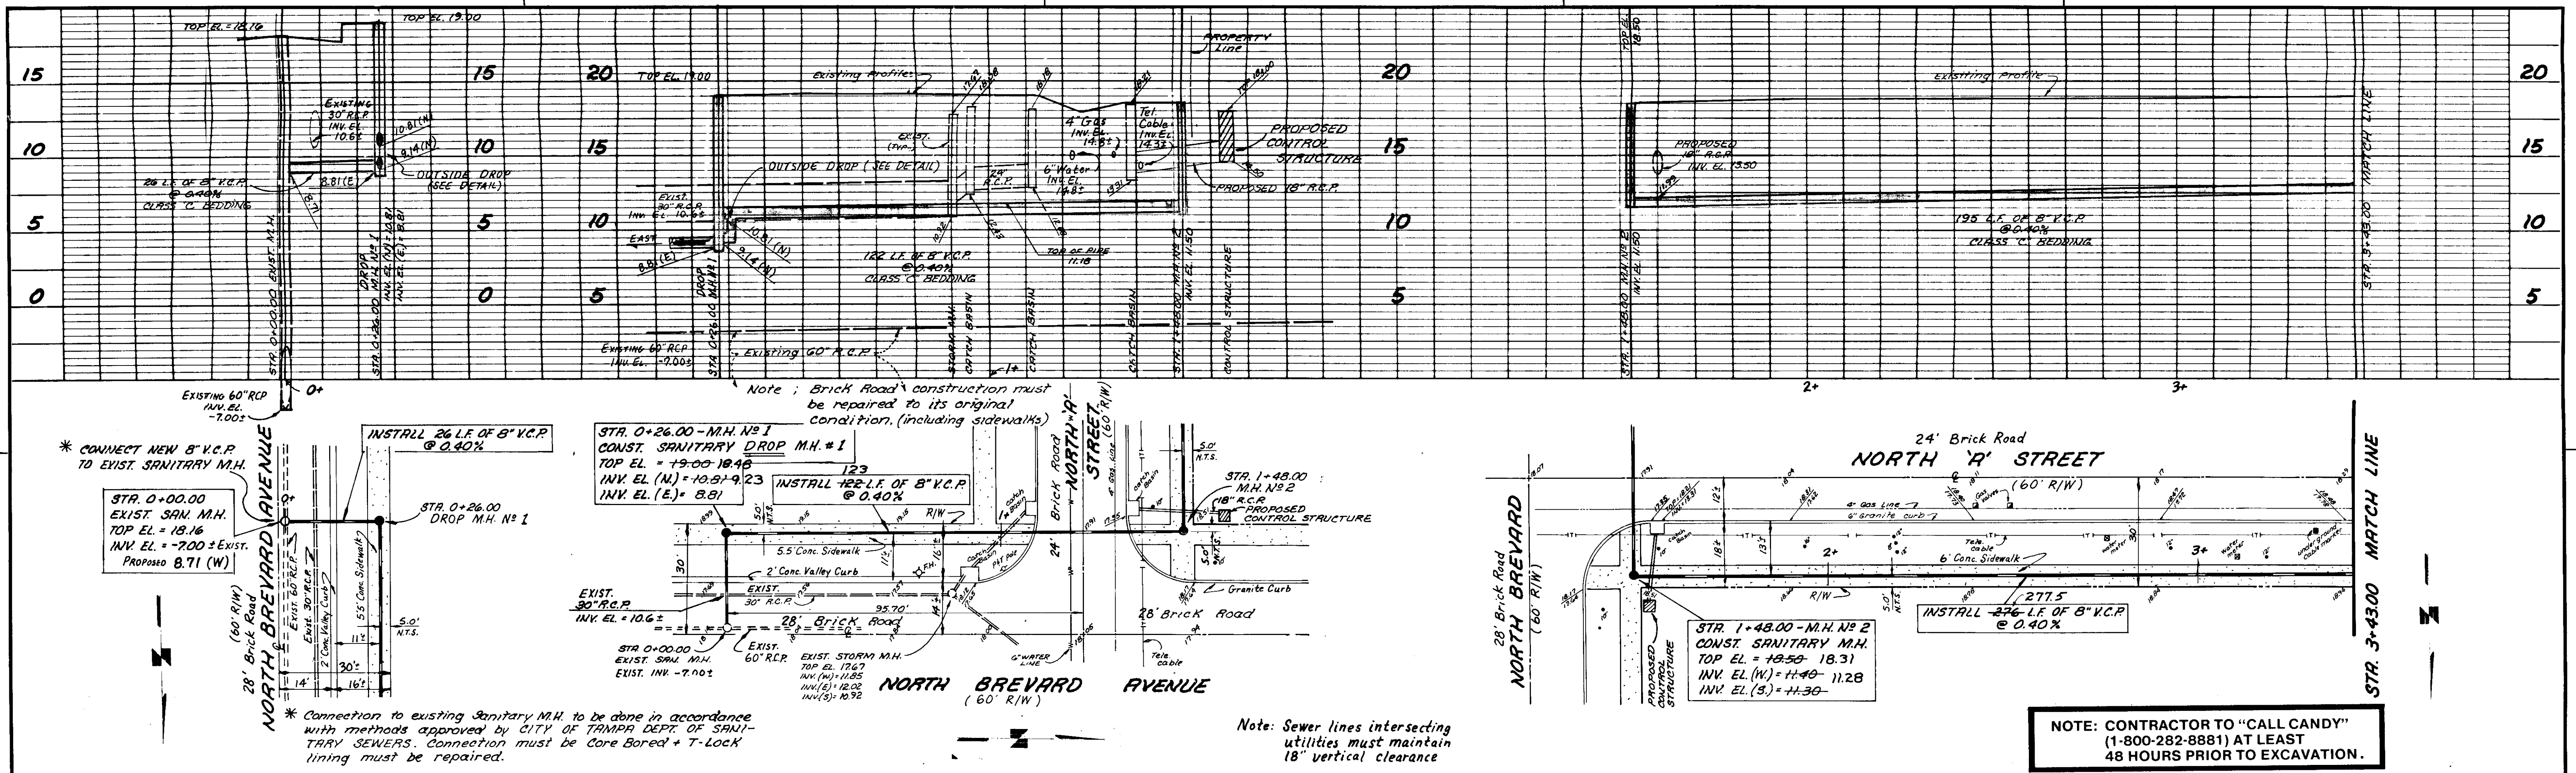


REVISIONS					
BY	DATE	DESCRIPTION	BY	DATE	DESCRIPTION
D.T.S.	12-23-85	Revised per Dept. of San Sewer Rev. Comments			
D.T.S.	12-30-85	Rev. per Dept. San Sewer Comments			
D.T.S.	2-17-86	Rev. Line Between MH 4 & MH 5			

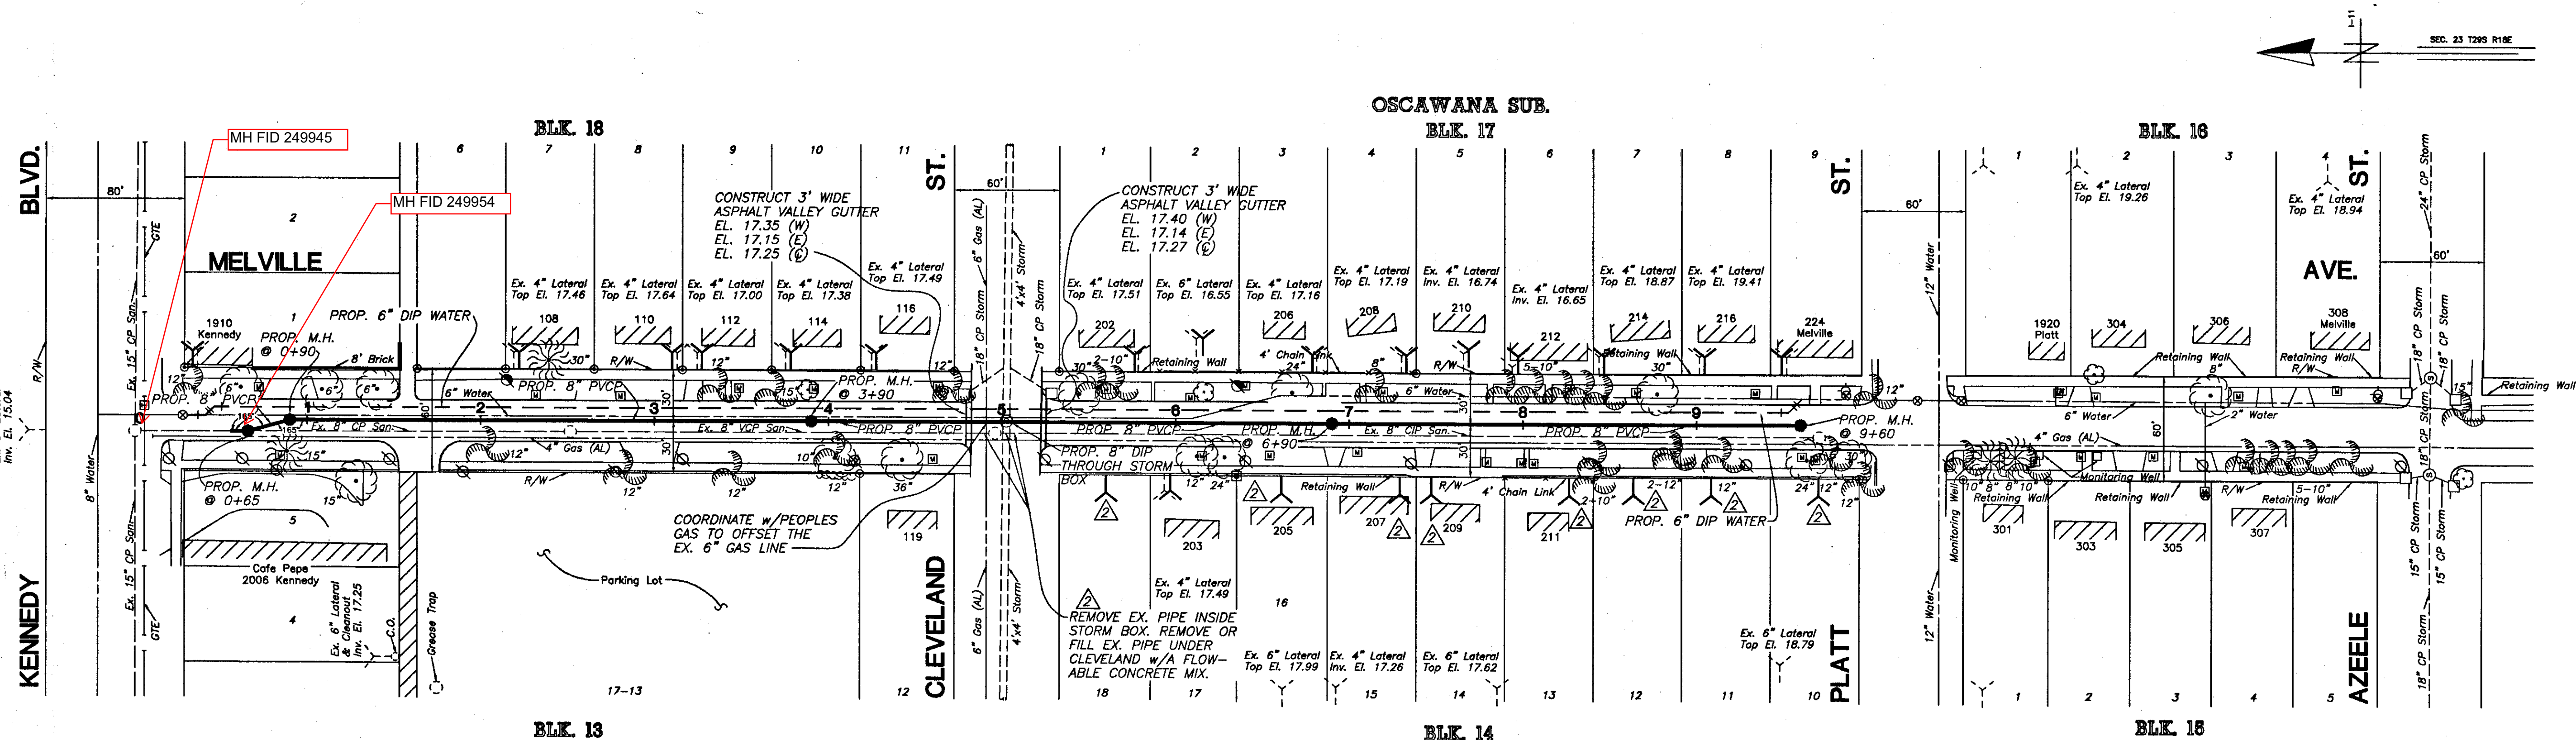

NOTES

1. ALL ELEVATIONS ARE BASED ON NOS DATUM UNLESS OTHERWISE NOTED.
2. LOCATIONS OF EXISTING UNDERGROUND UTILITIES WERE PREPARED FROM THE MOST RELIABLE INFORMATION AVAILABLE. VERIFY THE LOCATION AND DEPTH OF ALL PERTINENT UTILITIES PRIOR TO CONSTRUCTION. NOTIFY UTILITY COMPANIES AT LEAST 48 HOURS BEFORE BEGINNING CONSTRUCTION.
3. NEW HOUSE CONNECTION LOCATIONS ARE APPROXIMATE ONLY. REQUIRED LOCATION AND DEPTH WILL BE COORDINATED WITH THE HOMEOWNER AT THE TIME OF CONSTRUCTION BY THE D.S.S. CONSTRUCTION CREWS.
4. WHERE AN EXISTING SEWER IS TO BE REMOVED OR ABANDONED AND REPLACED WITH A NEW SEWER, CONTINUOUS SEWER SERVICE MUST BE MAINTAINED AT ALL TIMES, WHILE CONNECTING THE LATERALS TO THE NEW SEWER IN PLACE.
5. THE MINIMUM CLEARANCE BETWEEN HOUSE LATERALS AND WATER LINES SHALL BE 6" UNDER ALL CIRCUMSTANCES. IF THE HOUSE LATERAL IS BELOW A WATER LINE AND HAS BETWEEN 6" AND 18" OF CLEARANCE, OR IF THE LATERAL IS ABOVE THE WATER LINE REGARDLESS OF CLEARANCE, THEN A NOMINAL 20' LENGTH OF GREEN ANWVA CLASS 150 C900 PVC PIPE SHALL BE CENTERED OVER/UNDER THE WATER LINE.
6. ALL THE LATERALS WITH LESS THAN 2 FT. OF COVER SHALL BE DIP.
7. EX. STORM BOX SHALL BE CORE DRILLED FOR INSTALLATION OF PROP. 8" DIP. THE VERTICAL WALLS OF THE CONCRETE BOX CULVERT ARE APPROXIMATELY 12" THICK AND UNREINFORCED.

RESUB. OSCAWANA

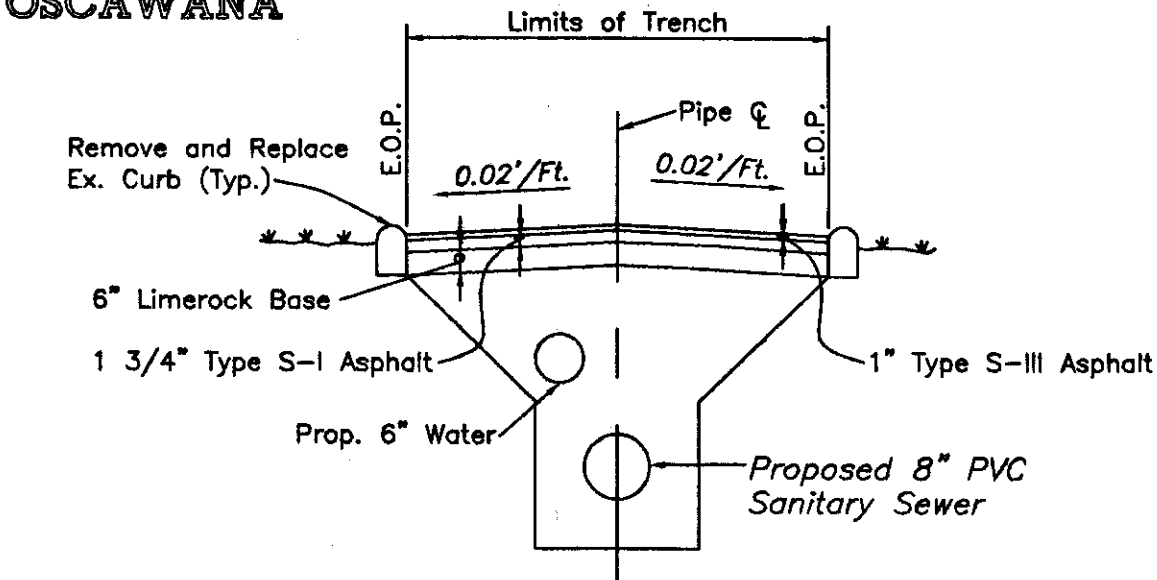


NOTES

1. Remove Ex. Asphalt & Base Full Width of Roadway.
2. Install 6" Limerock Base from EOP to EOP, Grade, & Compact.
3. Install 1 3/4" Type S-I & 1" Type S-III Asphalt. Match Prop. Grade of Roadway.

ROADWAY RESTORATION

N.T.S.


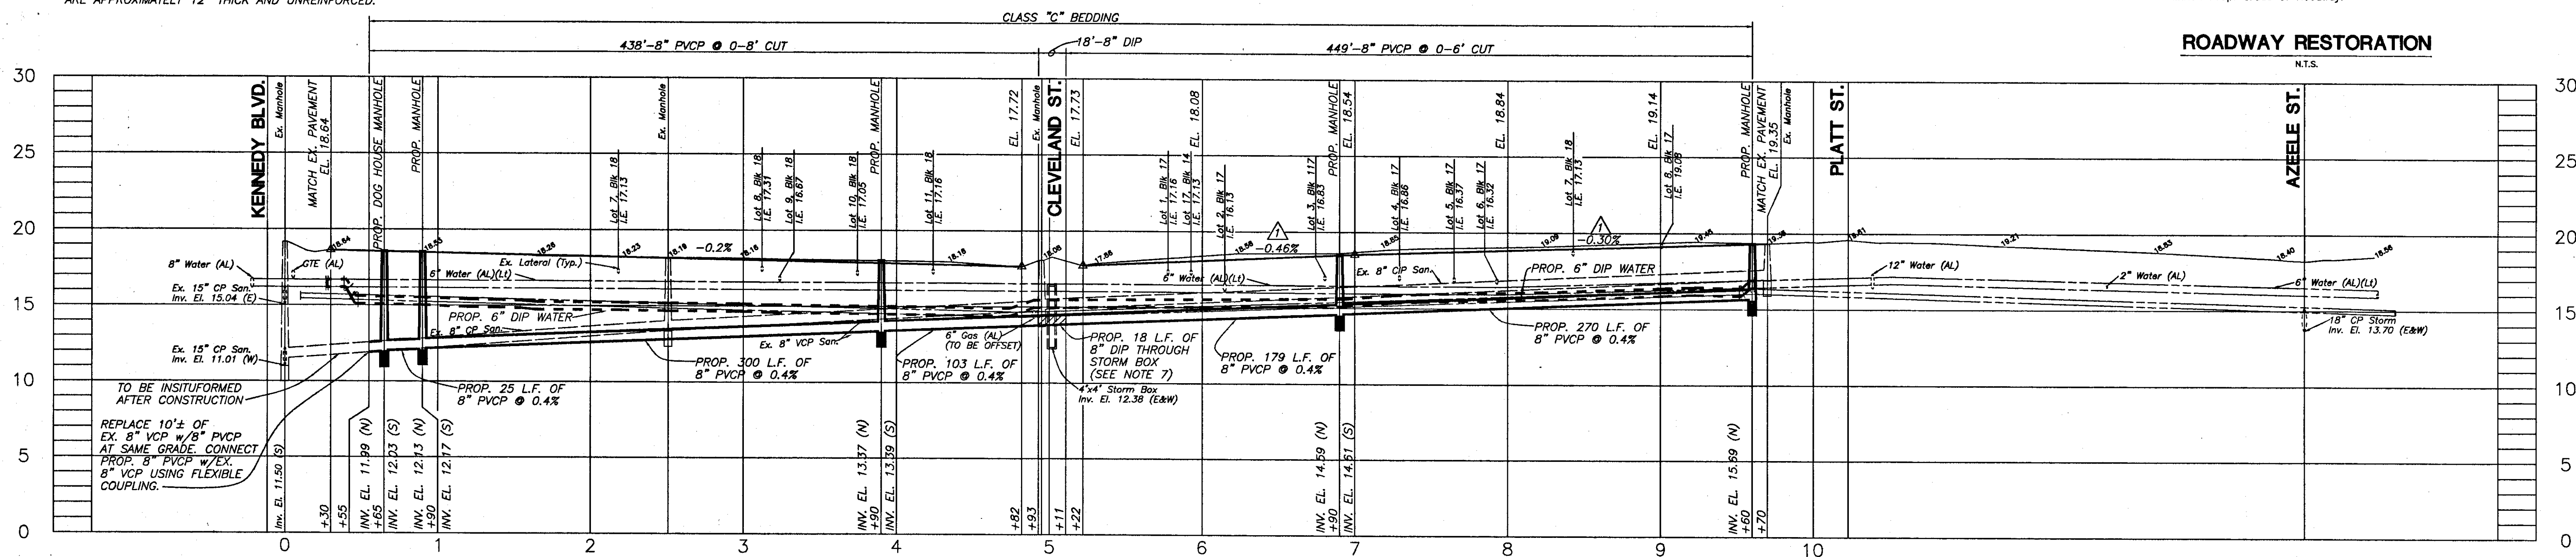


H.L. Dorback
HENRY DORBACK, P.E. #39449
CHIEF ENGINEER
DEPARTMENT OF SANITARY SEWERS

Ralph L. Metcalf II
RALPH L. METCALF II, P.E.
DIRECTOR
DEPARTMENT OF SANITARY SEWERS

DES: M.S.
DRN: R.A.R.
CKD: *D.H.*
DATE: 10/4/90

No.	DATE	REVISIONS
10-2-96		CHANGED SLOPE & GRADE IN PROFILE
10-2-96		ADDED LATERALS & NOTE
3		
4		
5		

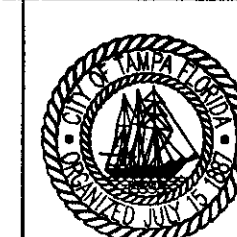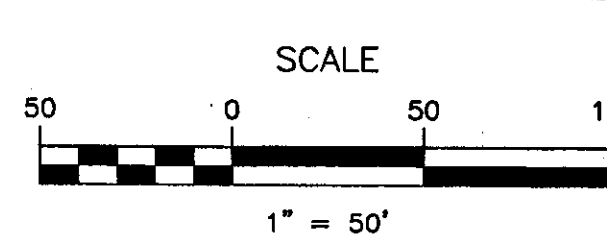

CITY OF TAMPA FLORIDA
DEPARTMENT OF SANITARY SEWERS
RENEWAL & REPLACEMENT
SEWAGE DISPOSAL SYSTEM

MELVILLE AVE.: KENNEDY BLVD. to PLATT ST.

DESIGN W.O. 4555
CONSTRUCTION W.O. 5640


SHEET

1

OF 3

290-21

MH FID 249879

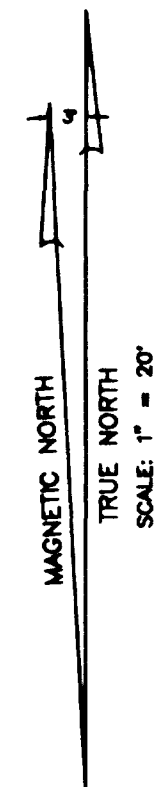

I-12

SURVEYORS NOTES

- LEGAL DESCRIPTION SHOWN HEREON IS OF THE PROPERTY SURVEYED AND THE PROPERTY DESCRIBED IN: COMMONWEALTH LAND TITLE INSURANCE COMPANY, COMMITMENT NUMBER # 864-80081, EFFECTIVE DATE, DECEMBER 17, 1999 @ 8:00 A.M.
- BEARINGS SHOWN HEREON ARE BASED ON THE NORTH RIGHT-OF-WAY LINE OF W. CLEVELAND STREET, SAID LINE BEARS N 89°00'00" E, ASSUMED.
- PER THE NATIONAL FLOOD INSURANCE RATE MAP OF THE CITY OF TAMPA, FLORIDA, COMMUNITY PANEL NO. 120114-0024 C, MAP REVISED 9-30-82, THIS PROPERTY APPEARS TO BE IN FLOOD ZONE "C".
- UNLESS OTHERWISE SHOWN, ENCROACHMENTS OF UNDERGROUND UTILITIES, WALL, FOOTINGS, ETC. WERE NOT RECOGNIZED IN THE FIELD. ALSO, FENCES AS SHOWN ARE NOT TO SCALE. OWNERSHIP OF FENCES AND/OR WALLS (IF PRESENT) ARE NOT FIELD DETERMINED.
- RE-USE OF THIS SURVEY FOR PURPOSES OTHER THAN WHICH IT WAS INTENDED, WITHOUT WRITTEN VERIFICATION, WILL BE AT THE RE-USER'S SOLE RISK AND WITHOUT LIABILITY TO THE SURVEYOR. NOTHING HEREIN SHALL BE CONSTRUED TO GIVE ANY RIGHTS OR BENEFITS TO ANYONE OTHER THAN THOSE CERTIFIED TO.
- EASEMENTS, RIGHT-OF-WAY, SET BACK LINES, RESERVATIONS, AGREEMENTS AND OTHER SIMILAR MATTERS TAKEN FROM COMMONWEALTH LAND TITLE INSURANCE COMPANY, COMMITMENT NUMBER # 864-80081, EFFECTIVE DATE, DECEMBER 17, 1999 @ 8:00 A.M.
- THE ELEVATIONS SHOWN HEREON ARE BASED ON THE CITY OF TAMPA BENCH MARK B-0252 ELEVATION = 19.816 (N.G.V.D. 1929).


SECTION 24, TOWNSHIP 29 SOUTH, RANGE 18 EAST

LEGEND:

A/C = AIR-CONDITIONER	L.B. = LICENSED BUSINESS	R/O = ROOF OVER
B = BASELINE	M = MEASURED	R/W = RIGHT-OF-WAY
C = CALCULATED	N.A.V.D. = NATIONAL GEODETIC VERTICAL DATUM	S.F.H. = SPECIAL FLOOD HAZARD AREA
CTV = CABLE TELEVISION	O.A. = OVER ALL	T.B.M. = TEMPORARY BENCH MARK
E = CENTERLINE	OH = OVERHEAD UTILITY LINE	W.F. = WOOD FENCE
C.M.P. = CORRUGATED METAL PIPE	P.I. = POINT OF INTERSECTION	W.M. = WATER METER
C.L.F. = CHAIN LINK FENCE	P.C. = POINT OF CURVATURE	W.P.P. = WOOD POWER POLE
CONC. = CONCRETE	P.E. = PERMANENT CONTROL POINT	ELEVATIONS = +X-00.00 AND/OR X-00.00
D = DESCRIPTION	P.K. = PARKER KALON	CONTOUR LINES =
D.G. = DOWN GUT	P.L.S. = PROFESSIONAL LAND SURVEYOR	00' - 00' - 00'
D.S. = DRAINAGE	P.O.B. = POINT OF BEGINNING	00' - 00' - 00'
E.P. = EDGE OF PAVEMENT	P.O.C. = POINT OF COMMENCEMENT	00' - 00' - 00'
ENCR. = ENCROACHMENT	P.O.T. = POINT OF TERMINATION	00' - 00' - 00'
G.T.A. = GATE TOP INLET	P.S.M. = PROFESSIONAL SURVEYOR & MAPPER	00' - 00' - 00'
I.D. No. = IDENTIFICATION NUMBER	P.T. = POINT OF TANGENCY	00' - 00' - 00'
L.P. = IRON PIPE	R.L.S. = REGISTERED LAND SURVEYOR	00' - 00' - 00'
L.S. = IRON ROD	R.C.P. = REINFORCED CONCRETE PIPE	00' - 00' - 00'

LEGAL DESCRIPTION:

THE SOUTH 22 FEET OF LOT 4, ALL OF LOTS 5, 6, 7 IN BLOCK 1, AND LOTS 9 AND 10, BLOCK 1, TOGETHER WITH 1/2 OF CLOSED ALLEY ABUTTING THEREON, PLAN OF WASHINGTON SUBDIVISION, ACCORDING TO THE PLAT THEREOF ON FILE IN THE OFFICE OF THE CLERK OF THE CIRCUIT COURT, IN AND FOR HILLSBOROUGH COUNTY, FLORIDA, RECORDED IN PLAT BOOK 1, PAGE 4, SAID LANDS SITUATE, LYING AND BEING IN HILLSBOROUGH COUNTY, FLORIDA.

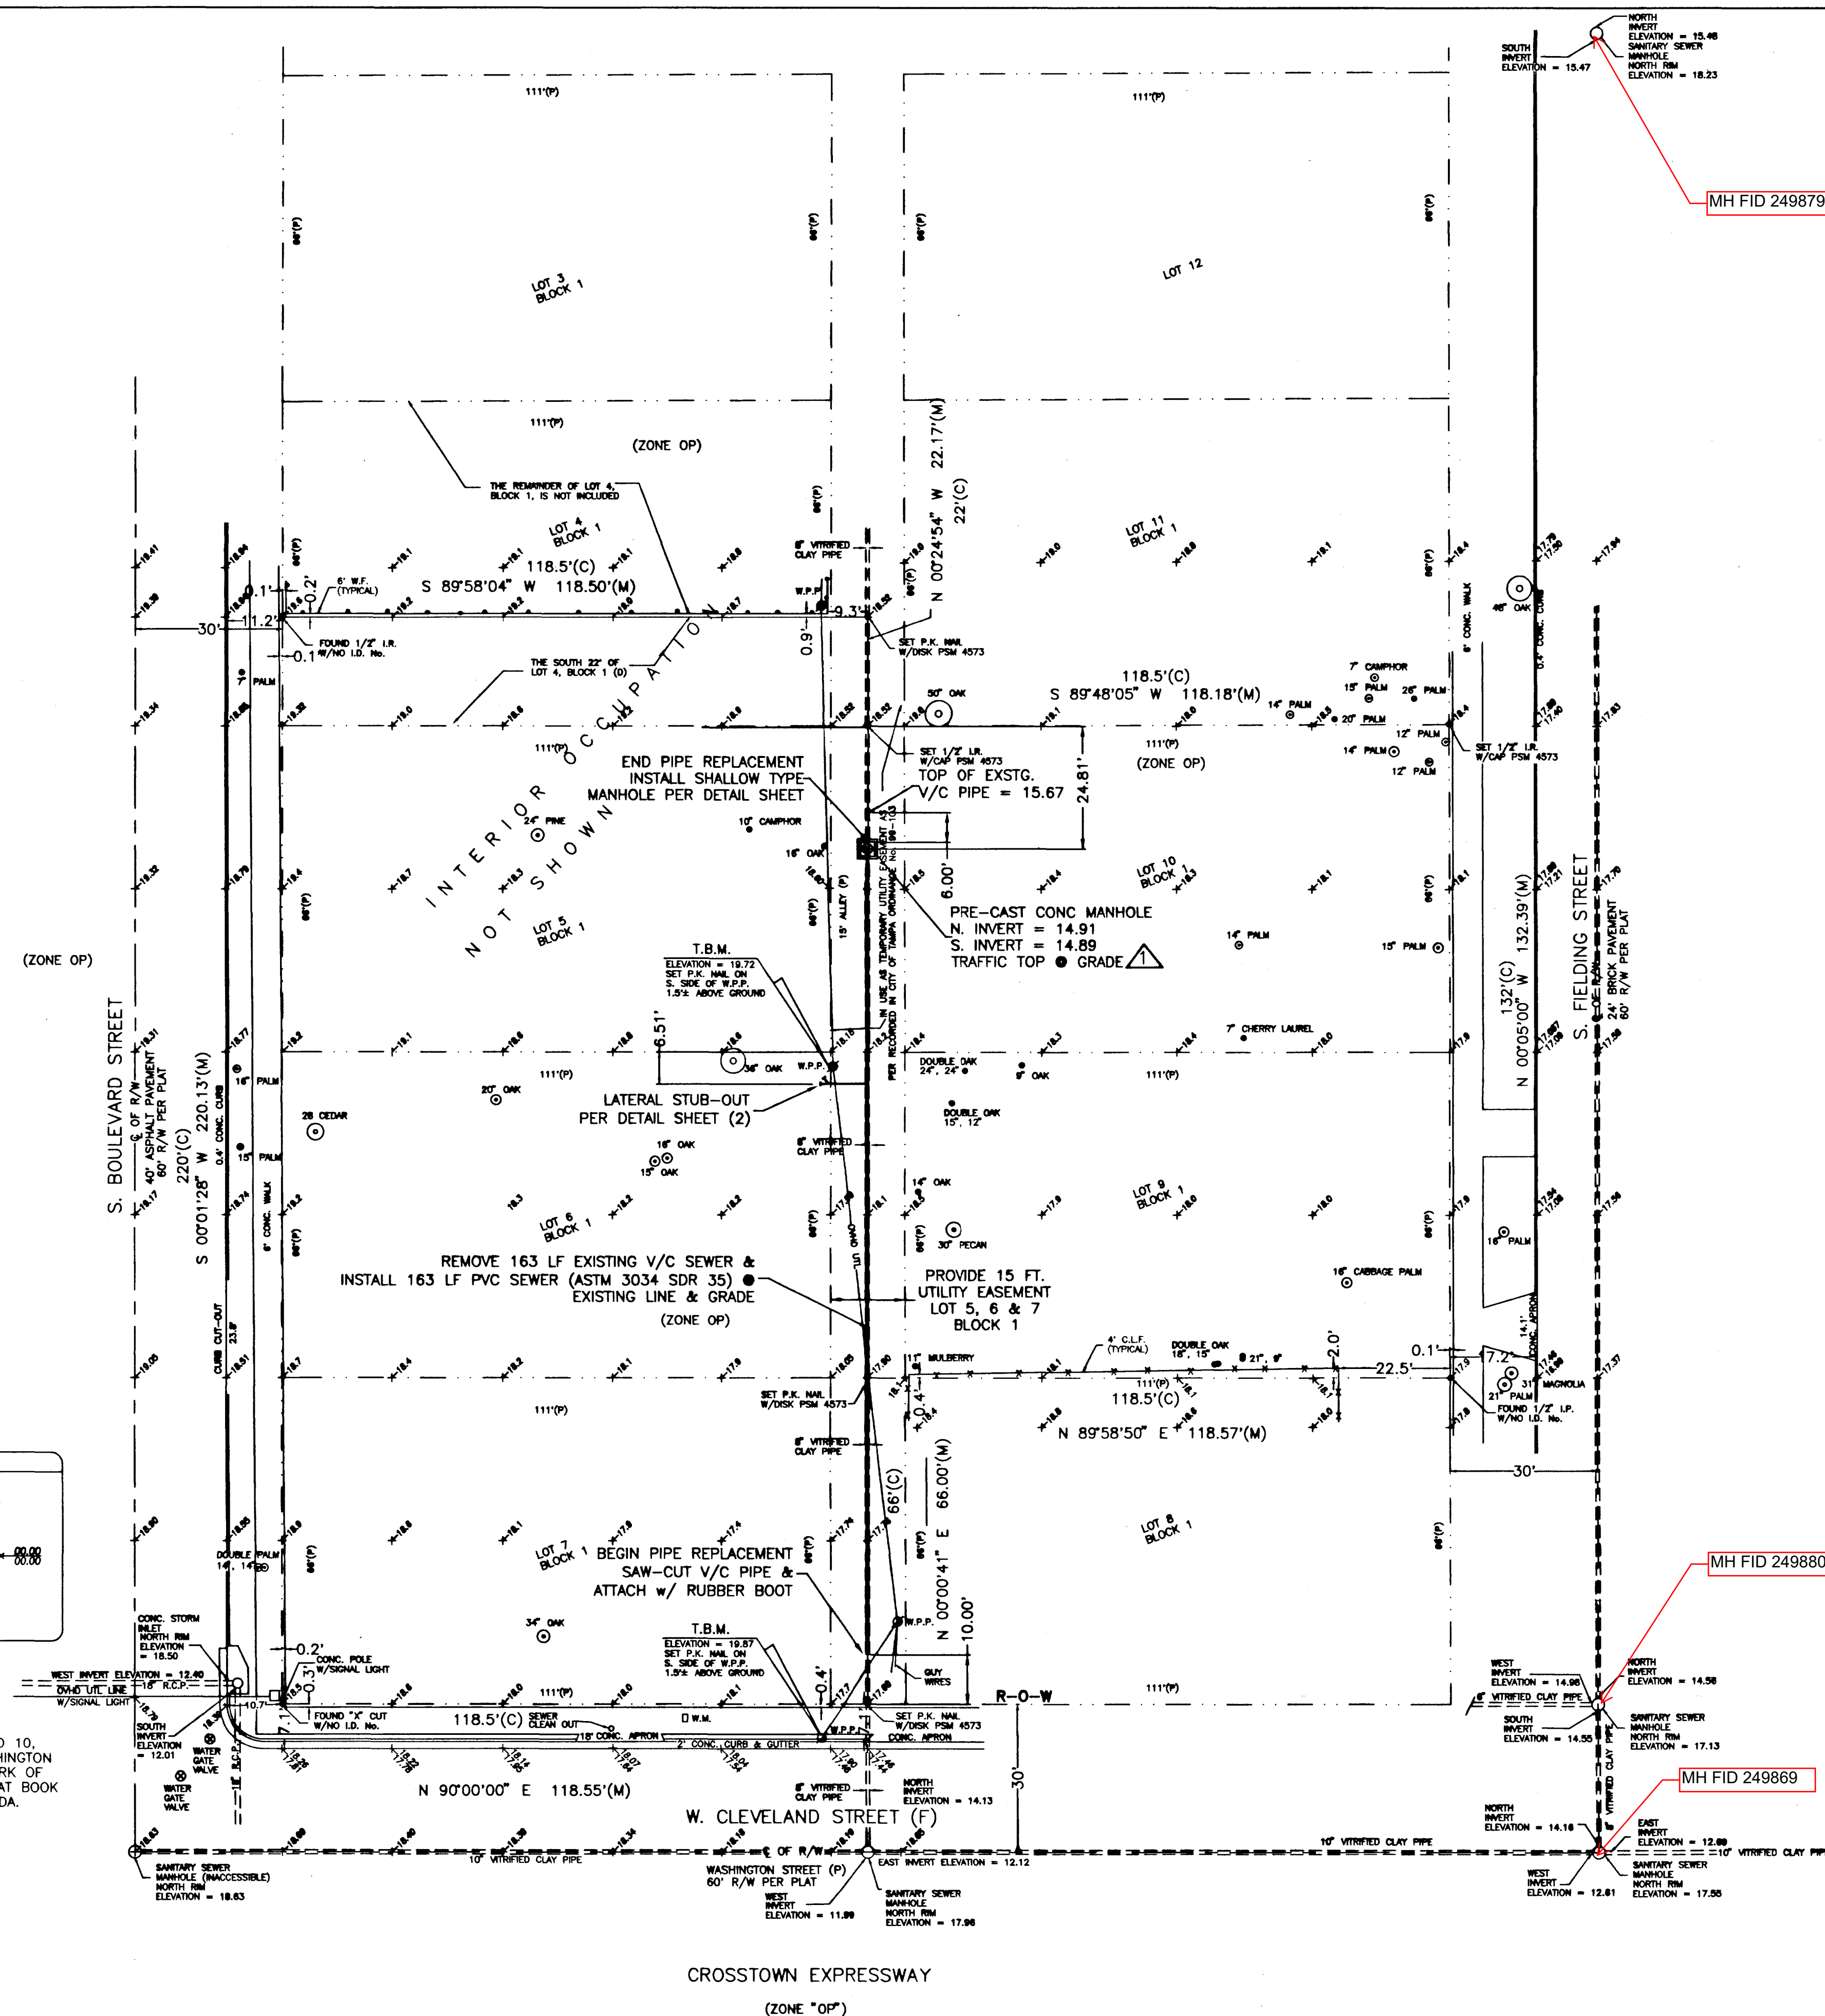

PVC PIPE: PIPE SHALL BE MADE OF PVC MATERIAL HAVING A CELL CLASSIFICATION 12454 B, 12454 C OR 13354 B PER ASTM D1784. (PIPE SHALL BE MARKED AS ASTM 3034, SDR35)

PIPE SHALL BE TESTED IN ACCORDANCE WITH ASTM D3212 AND SHALL CONFORM TO UNI-BELL PLASTIC PIPE ASSOCIATION STANDARD UNI-B4.

EACH LENGTH OF PIPE SHALL BE MARKED WITH THE SIZE, MANUFACTURER ASTM DESIGNATION AND THE NATIONAL SANITARY FOUNDATION (NSF) SEAL.

PIPE COLOR SHALL BE GREEN.

Laterals shall be installed with a wye fitting and 1/8 bend.

THE LATERAL LOCATION SHALL BE MARKED WITH A #5 x 48" REINFORCING ROD, DRIVEN VERTICALLY AND ADJACENT TO THE LATERAL UNTIL THE TOP OF THE ROD IS IN FLUSH WITH FINISHED GRADE.

TRENCH EXCAVATION: IN THE EVENT THAT UNSUITABLE SOIL IS ENCOUNTERED, IT MUST BE REMOVED AND REPLACED WITH SAND, GRAVEL CRUSHED STONE OR A COMBINATION THEREOF AS APPROVED BY THE ENGINEER.

BACK FILL & COMPACTION: BACK FILL MATERIAL SHALL BE COMMON FILL MATERIAL FREE OF ORGANIC MATTER, MUCK OR MARL AND ROCK EXCEEDING 2-1/2" IN DIAMETER.

BACK FILL SHALL BE COMPACTED TO 95% OF THE MAXIMUM DENSITY AS DETERMINED BY ASTM D1557 - MODIFIED PROCTOR, WITH A MINUS 3% TOLERANCE.

MH FID 249880

MH FID 249889

AS-BUILT


REVISION	DATE	DESCRIPTION
1	7/14/00	ADD P-CAST MANHOLE PER CITY REQUIREMENTS




Catalano Engineering, Inc.
CIVIL - TRANSPORTATION - STRUCTURAL

LIST GROUP
2101 WEST PLATT ST. #200
TAMPA, FLORIDA 33606
(813) 258-5478

UTILITY REPLACEMENT

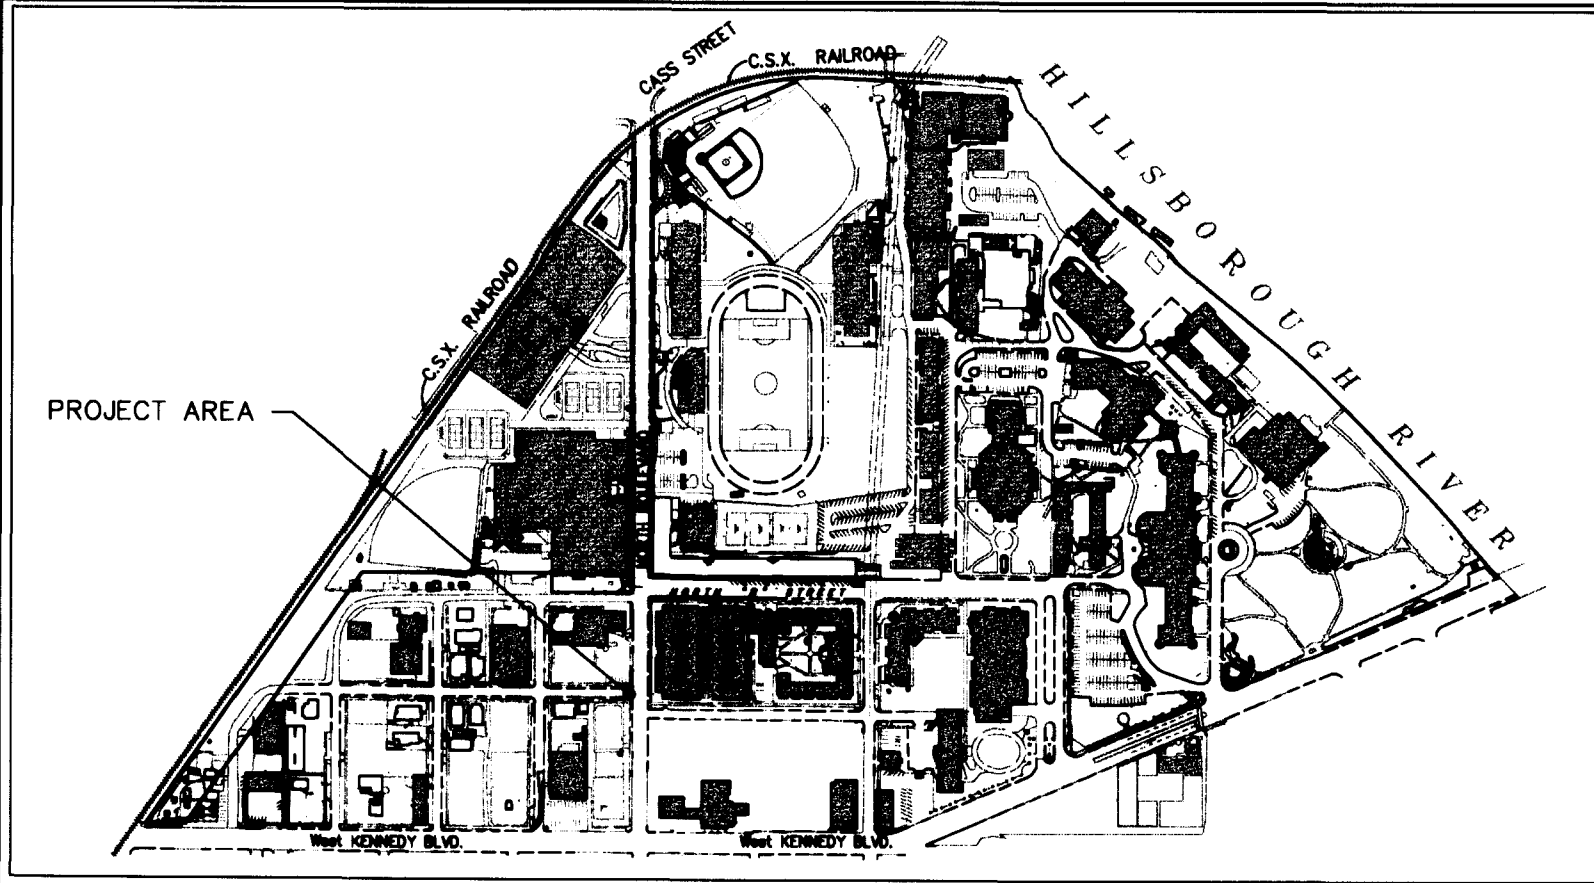


- GENERAL NOTES:**
- The Contractor shall maintain wastewater service wastewater service during all phases of the construction of the new sanitary sewer replacement. Prior to starting construction, shop drawings for bypassing the wastewater flow and maintaining serve shall be submitted to the City of Tampa's Wastewater Department for review and approval.
 - At utility crossings install joint equidistant from center of crossing utility pipe. (Typ.)
 - Return all disturbed areas to existing or better conditions. (Typ.)
 - Restore disturbed road way per FDOT Index # 307. (Typ.)
 - All work must comply with C.O.T. Wastewater Technical Manual. (Typ.)
 - Pipe Bedding to comply with C.O.T. Wastewater Technical Manual. (Typ.)
 - Existing pipes should be connected to the new manholes by providing an 8" PVC stub from the manhole and connecting the stub to the existing pipe using a flexible adapter.
 - All lateral along the alignment of the proposed sanitary sewer replacement that are in service and/or connected to an existing building shall be replaced from the property line to the new pipeline. A clean-out shall be provided at the property line.

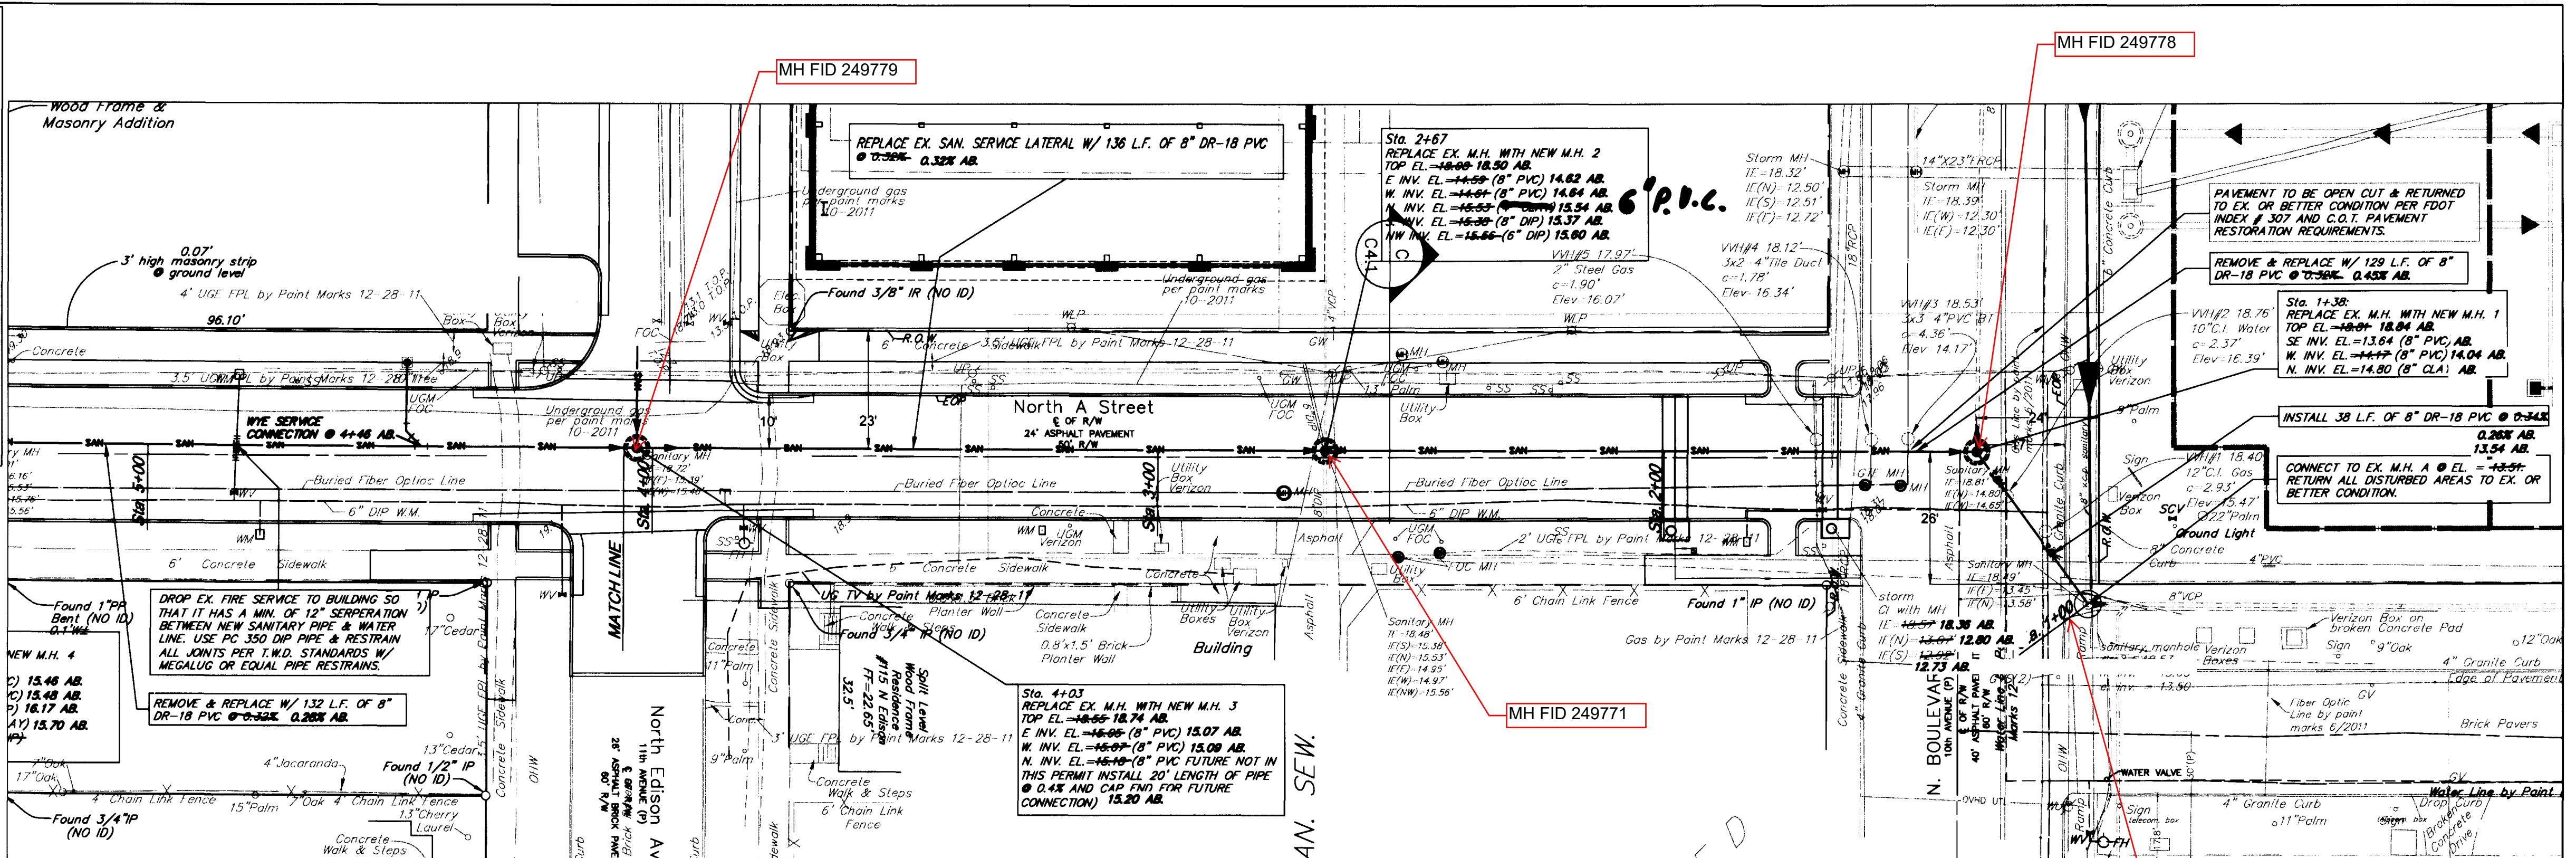


WASTEWATER FACILITIES & CONNECTION - PLAN
SCALE: 1" = 20'

*Location of existing utilities shown are approximate. Contractor shall field verify location of all existing utilities and shall expose them prior to installation and ensure that the proposed pipe will cross all existing utilities with acceptable clearance.

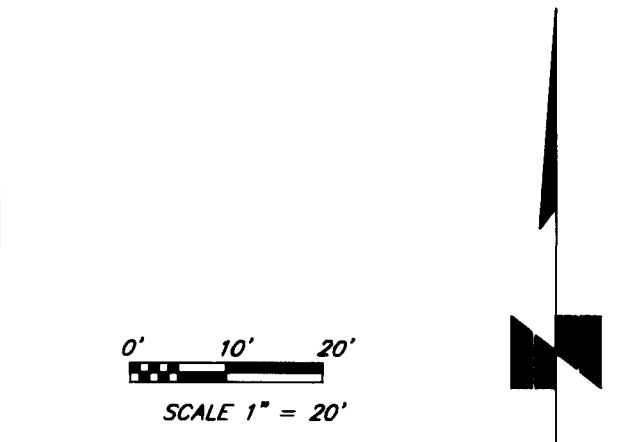

- LEGEND:**
- (D) = Description Data
 - (P) = Plot Data
 - (M) = Measured Data
 - c/a = Cleanout
 - Conc. = Concrete
 - C.L.F. = Chain Link Fence
 - E.B. = Electric Box
 - F.H. = Fire Hydrant
 - g.a. = Guy Anchor
 - Inv. = Invert elevation
 - LB = Licensed Business
 - max. = masonry
 - m.l.p. = metal light pole
 - O/A = Overall
 - O.V.D. = Overhead utility lines
 - PSM = Professional Surveyor & Mapper
 - R/O = Roof Overhang
 - R/W = Right-of-way
 - (typ.) = Typical
 - U.P. = Utility Pole
 - W.L.P. = wood light pole
 - W.M. = Water meter
 - W.V. = Water Valve
 - W.U.P. = Wood Utility Pole
 - N = North
 - S = South
 - E = East
 - W = West
 - M.E.G. = Match Existing Grade (for vacuum utility locating)
 - V.H. = VERTICAL VACUUM HOLE (for vacuum utility locating)
 - = Top of Curb El./ Pavement El.
 - = Top of Sod El.

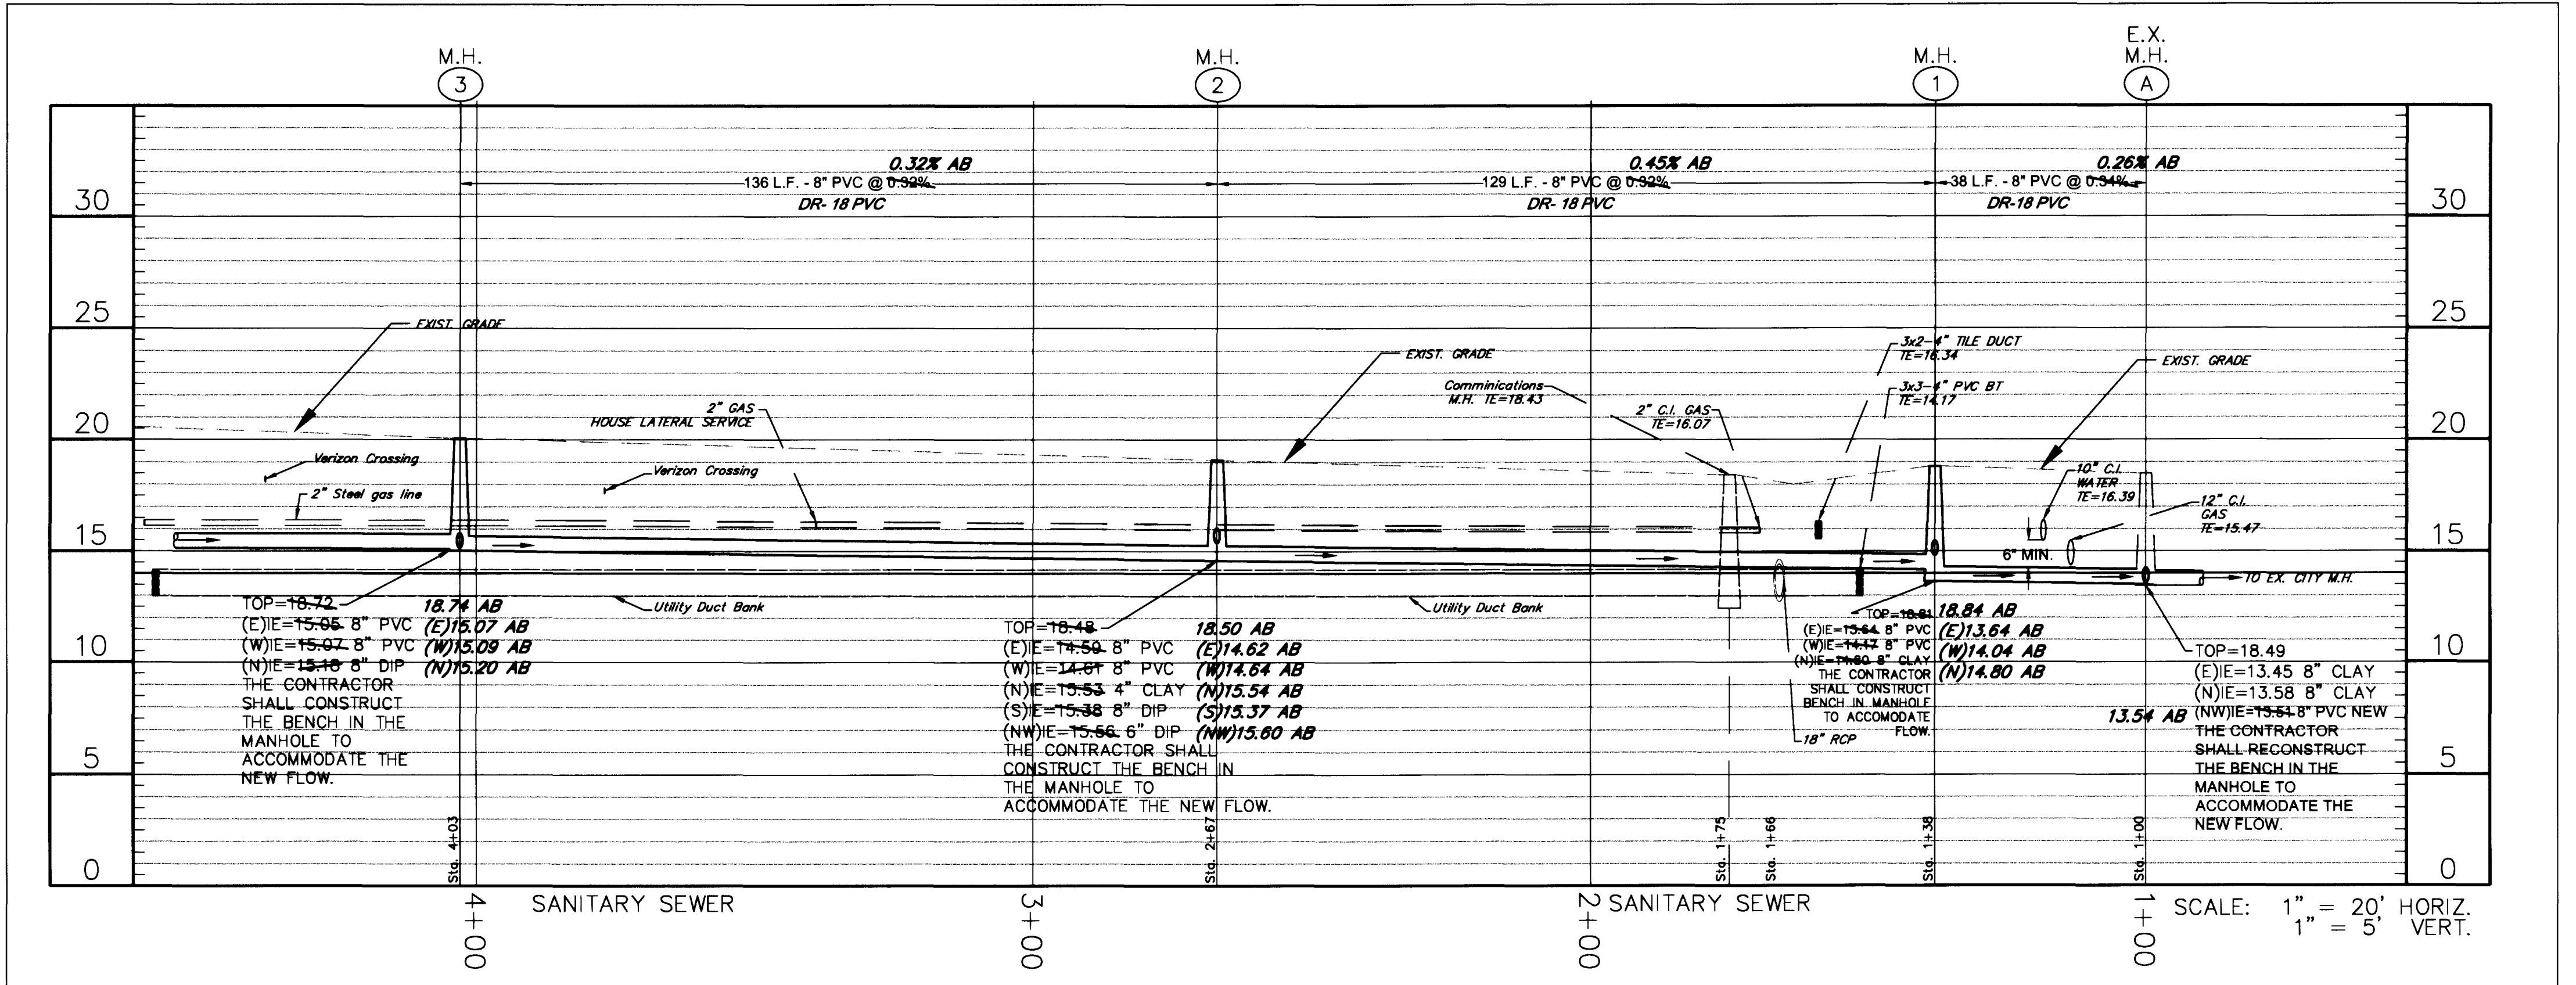

WASTEWATER FACILITIES & CONNECTION - PROFILE
SCALE:
HORIZ. 1" = 20'
VERT. 1" = 5'

NOTE TO CONTRACTOR:
CONTRACTOR TO CALL SUNSHINE STATE ONE-CALL OF FLORIDA, 1-800-432-4770, A MINIMUM OF 2 DAYS PRIOR TO EXCAVATION

FOR WORK IN THE RIGHT-OF-WAY, IT IS THE CONTRACTOR'S RESPONSIBILITY TO OBTAIN A CITY OF TAMPA D.P.W. RIGHT-OF-WAY PERMIT (PHONE 813/274-8027).

All signage and striping to comply with the Manual for Uniform Traffic Control Devices (M.U.T.C.D.)

NOTES:
1. Elevations shown hereon are based on City of Tampa Bench Marks and referenced to National Geodetic Vertical Datum of 1929. see drawing for on site bench marks.

REVISIONS					
BY	DATE	DESCRIPTION	BY	DATE	DESCRIPTION
ATG	12/26/12	Revise Per EPC Comments	1		
ATG	1/14/13	Revise Per EPC Comments	2		


MILLS and ASSOCIATES, INC.
CONSULTING ENGINEERS & LAND SURVEYORS
3242 HENDERSON BOULEVARD * SUITE 300
TAMPA, FLORIDA 33609-3056
TELEPHONE: (813) 876-5869

THE UNIVERSITY OF TAMPA
401 W. KENNEDY BLVD.
TAMPA, FLORIDA 33606
TELEPHONE: (813) 258-7256

DRWN BY: ATG DATE 11/29/11
DSGN BY: ATG DATE 10/30/12
CHKD BY: LEM DATE _____
SCALE: 1" = 20'
Lawrence E. Mills
LAWRENCE E. MILLS
P.E. NO. 22324 - E.B. NO. 3860
P.L.S. NO. 3141 - E.B. NO. 3869
STATE OF FLORIDA

PROJECT		SHEET	
N. A ST. SEWER REPLACEMENT		C 1.2	
PLAN & PROFILE		JOB NO.	
		12-015	

2013-282

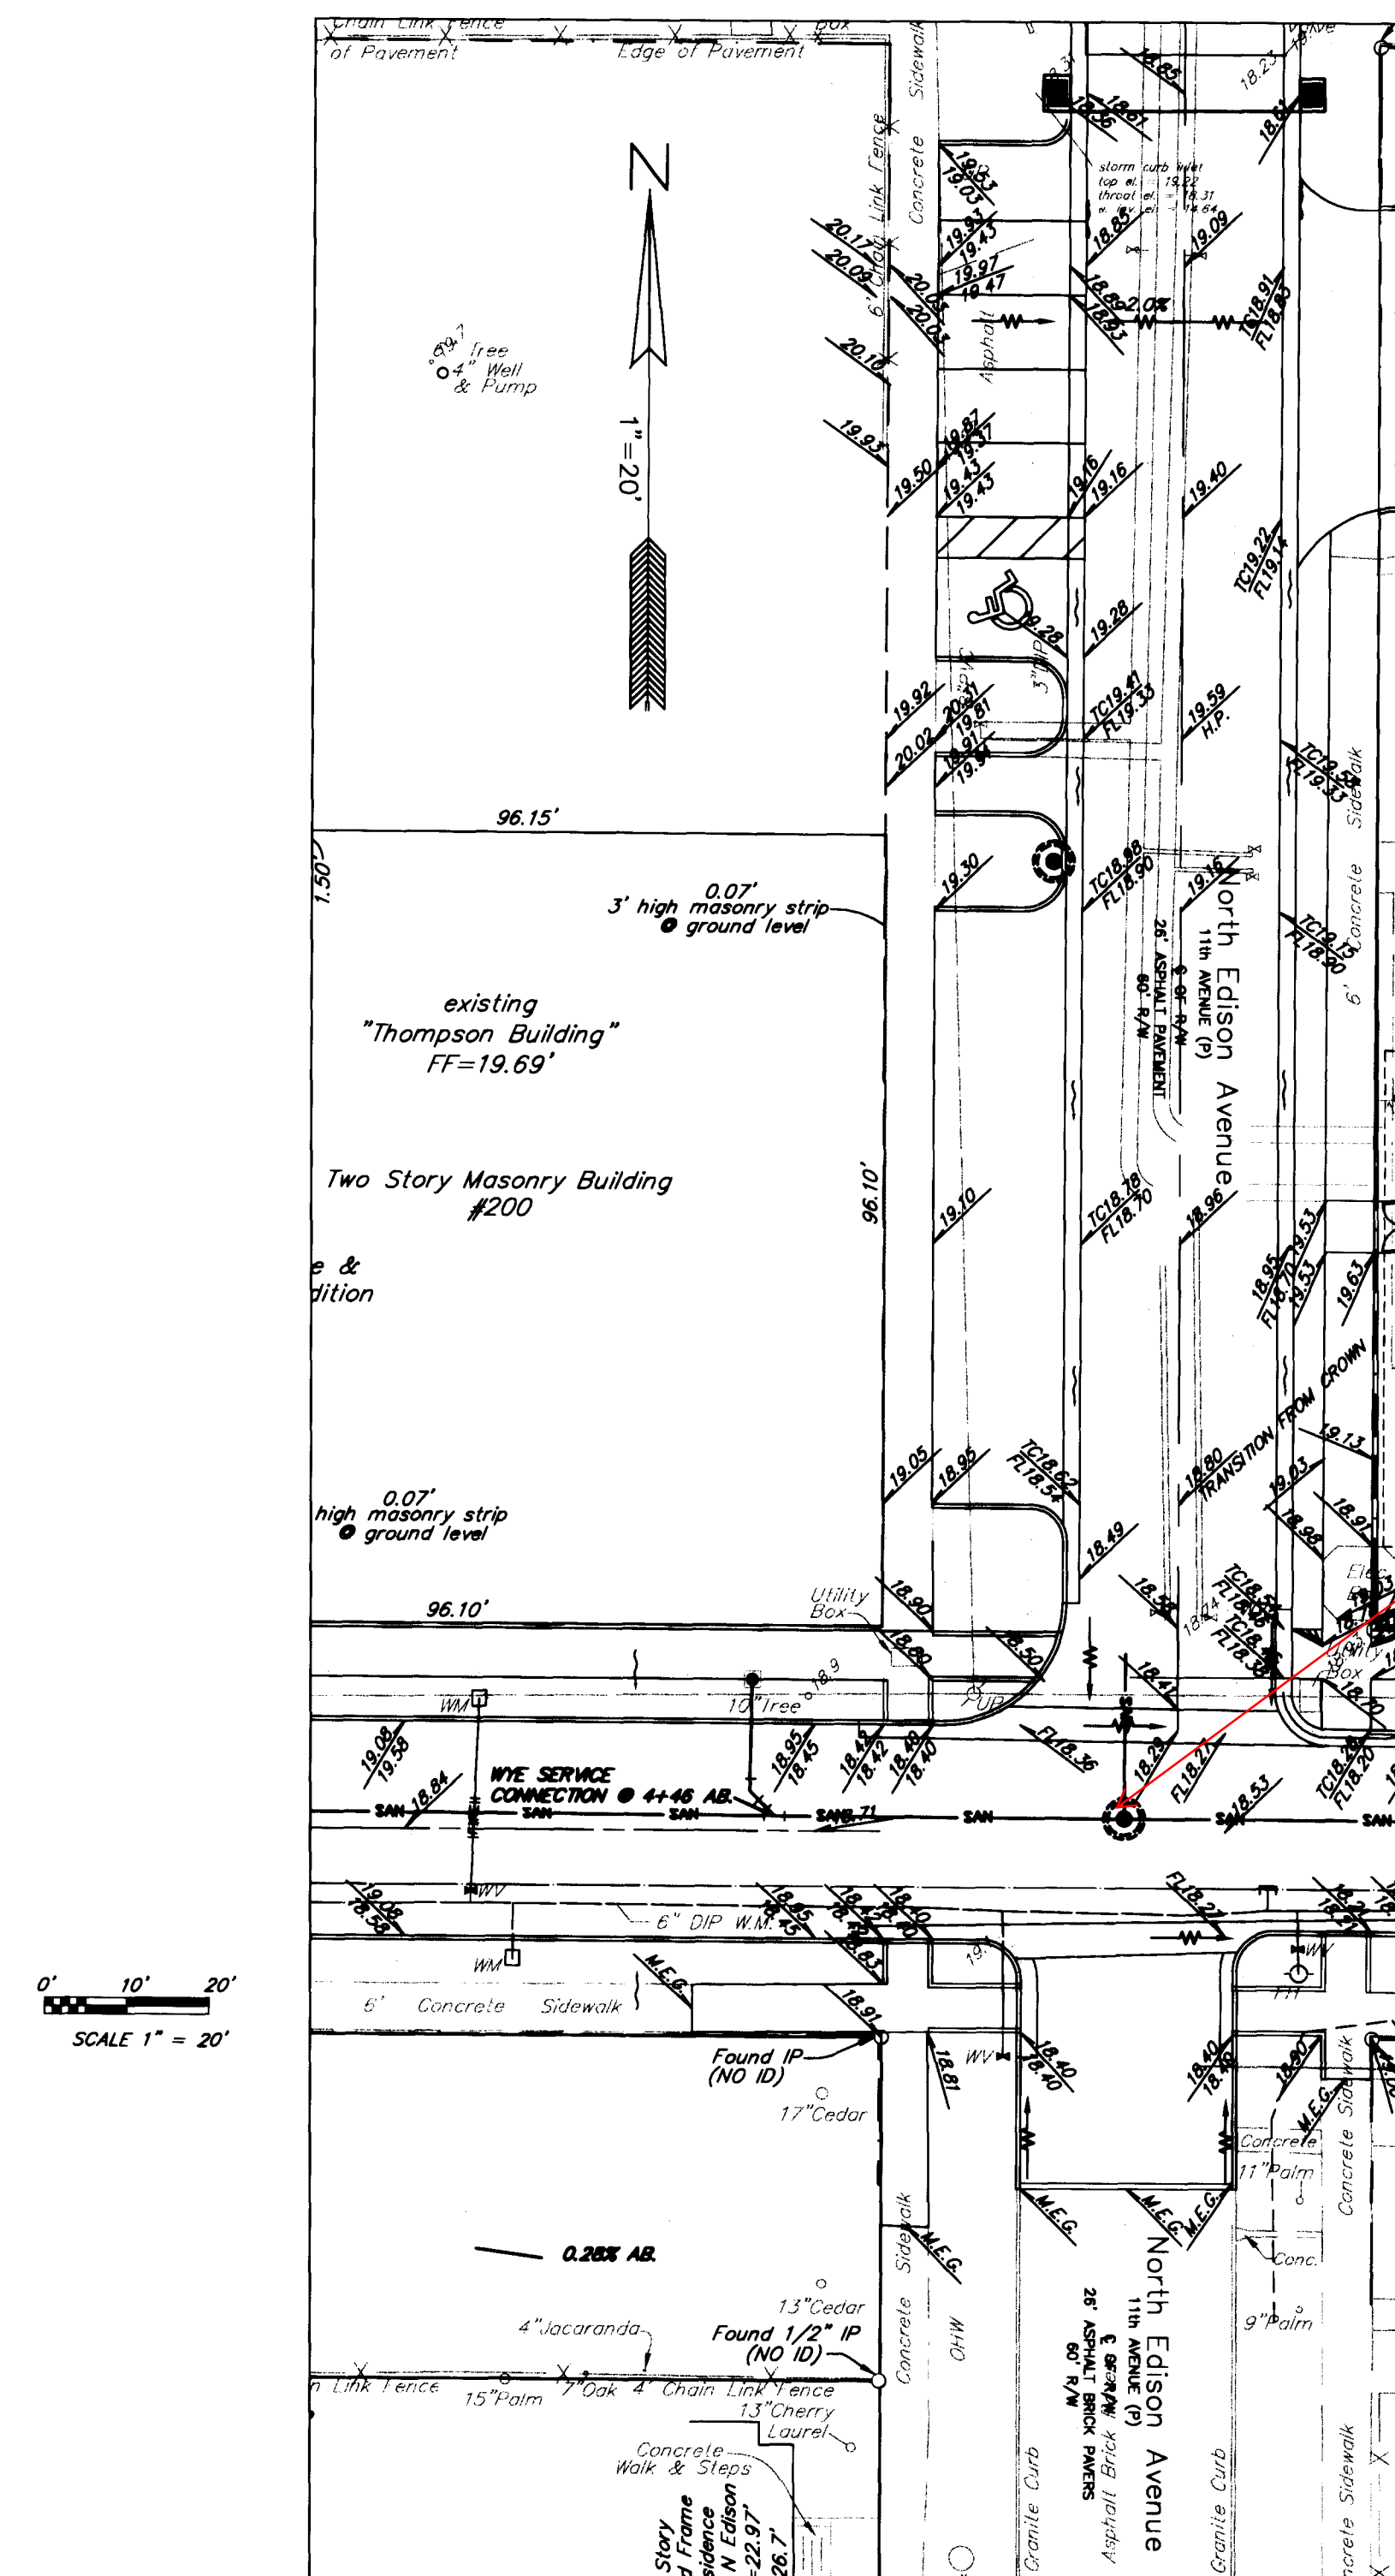

MH FID 249779



NOTE TO CONTRACTOR:
CONTRACTOR TO CALL SUNSHINE STATE
ONE-CALL OF FLORIDA, 1-800-432-4770
A MINIMUM OF 5 DAYS PRIOR TO EXCAVATION

**FOR WORK IN THE RIGHT-OF-WAY, IT IS THE CONTRACTOR'S
RESPONSIBILITY TO OBTAIN A CITY OF TAMPA D.P.W.
RIGHT-OF-WAY PERMIT (PHONE 813/274-8027).**

*All signage and stripping to comply with the Manual for Uniform Traffic
Control Devices (M.U.T.C.D.)*

NOTES:

1. Elevations shown hereon are based on City of Tampa Bench Marks and referenced to National Geodetic Vertical Datum of 1929. see drawing for on site bench marks.

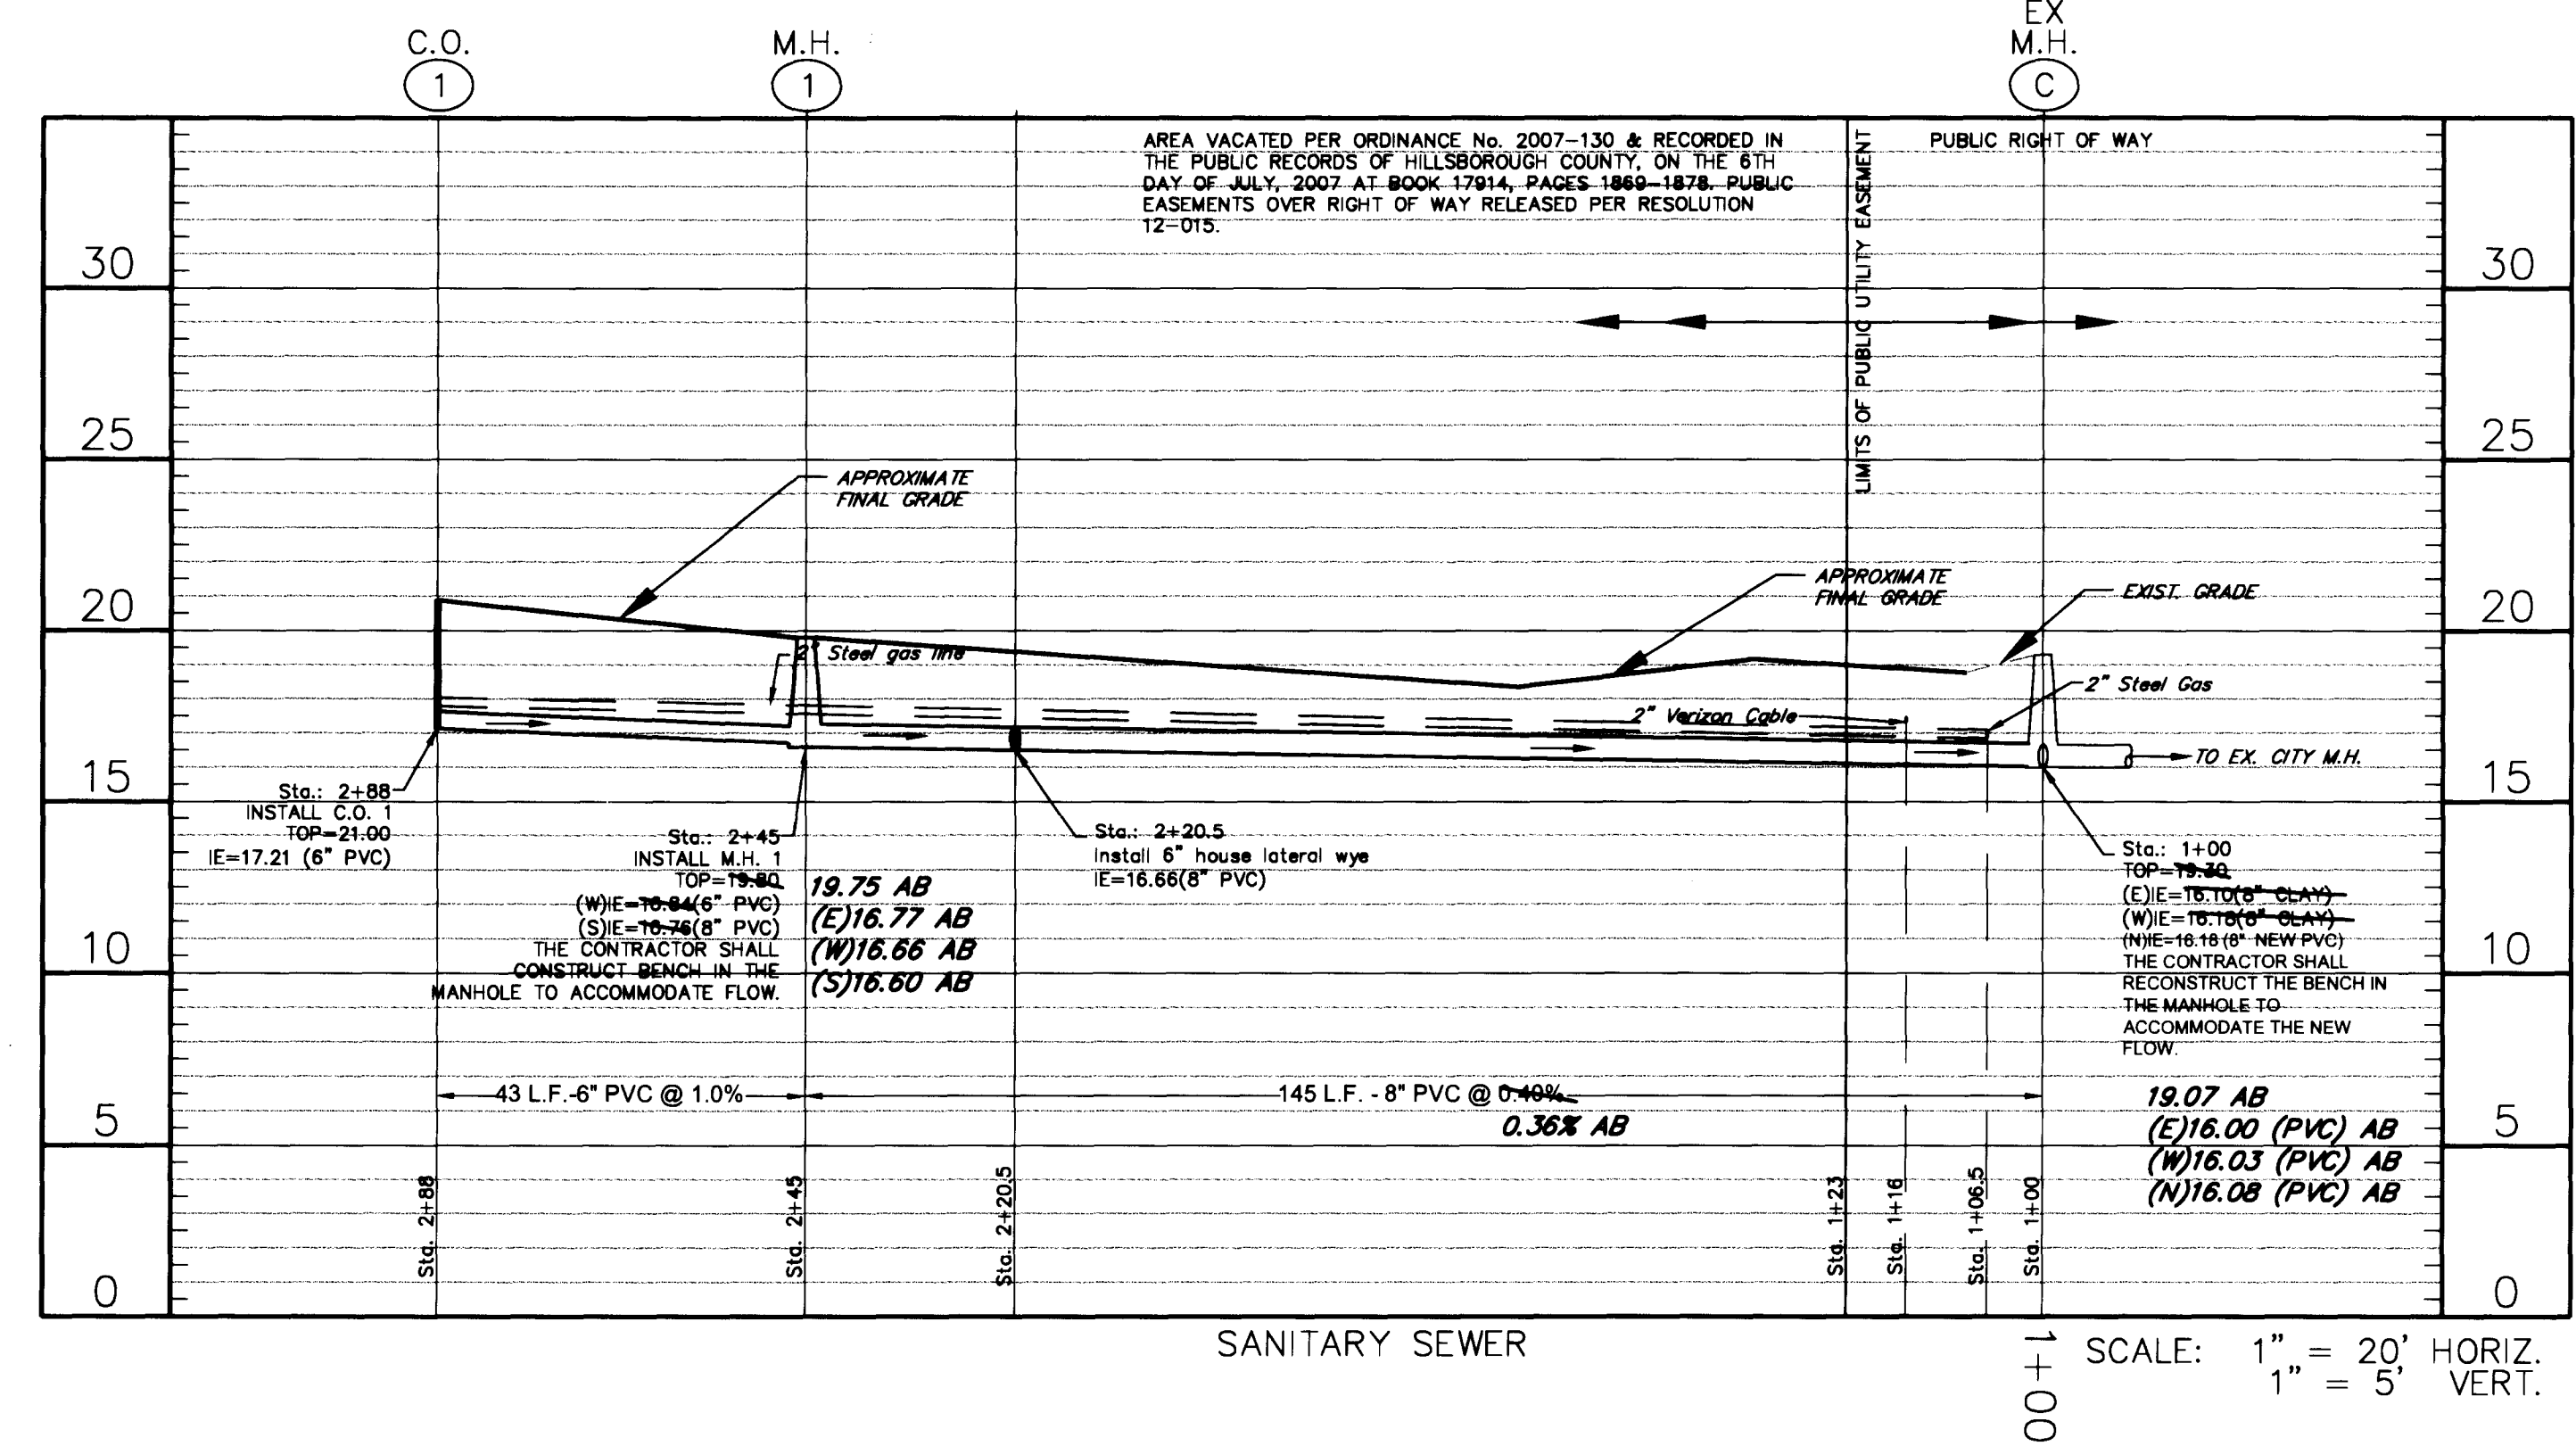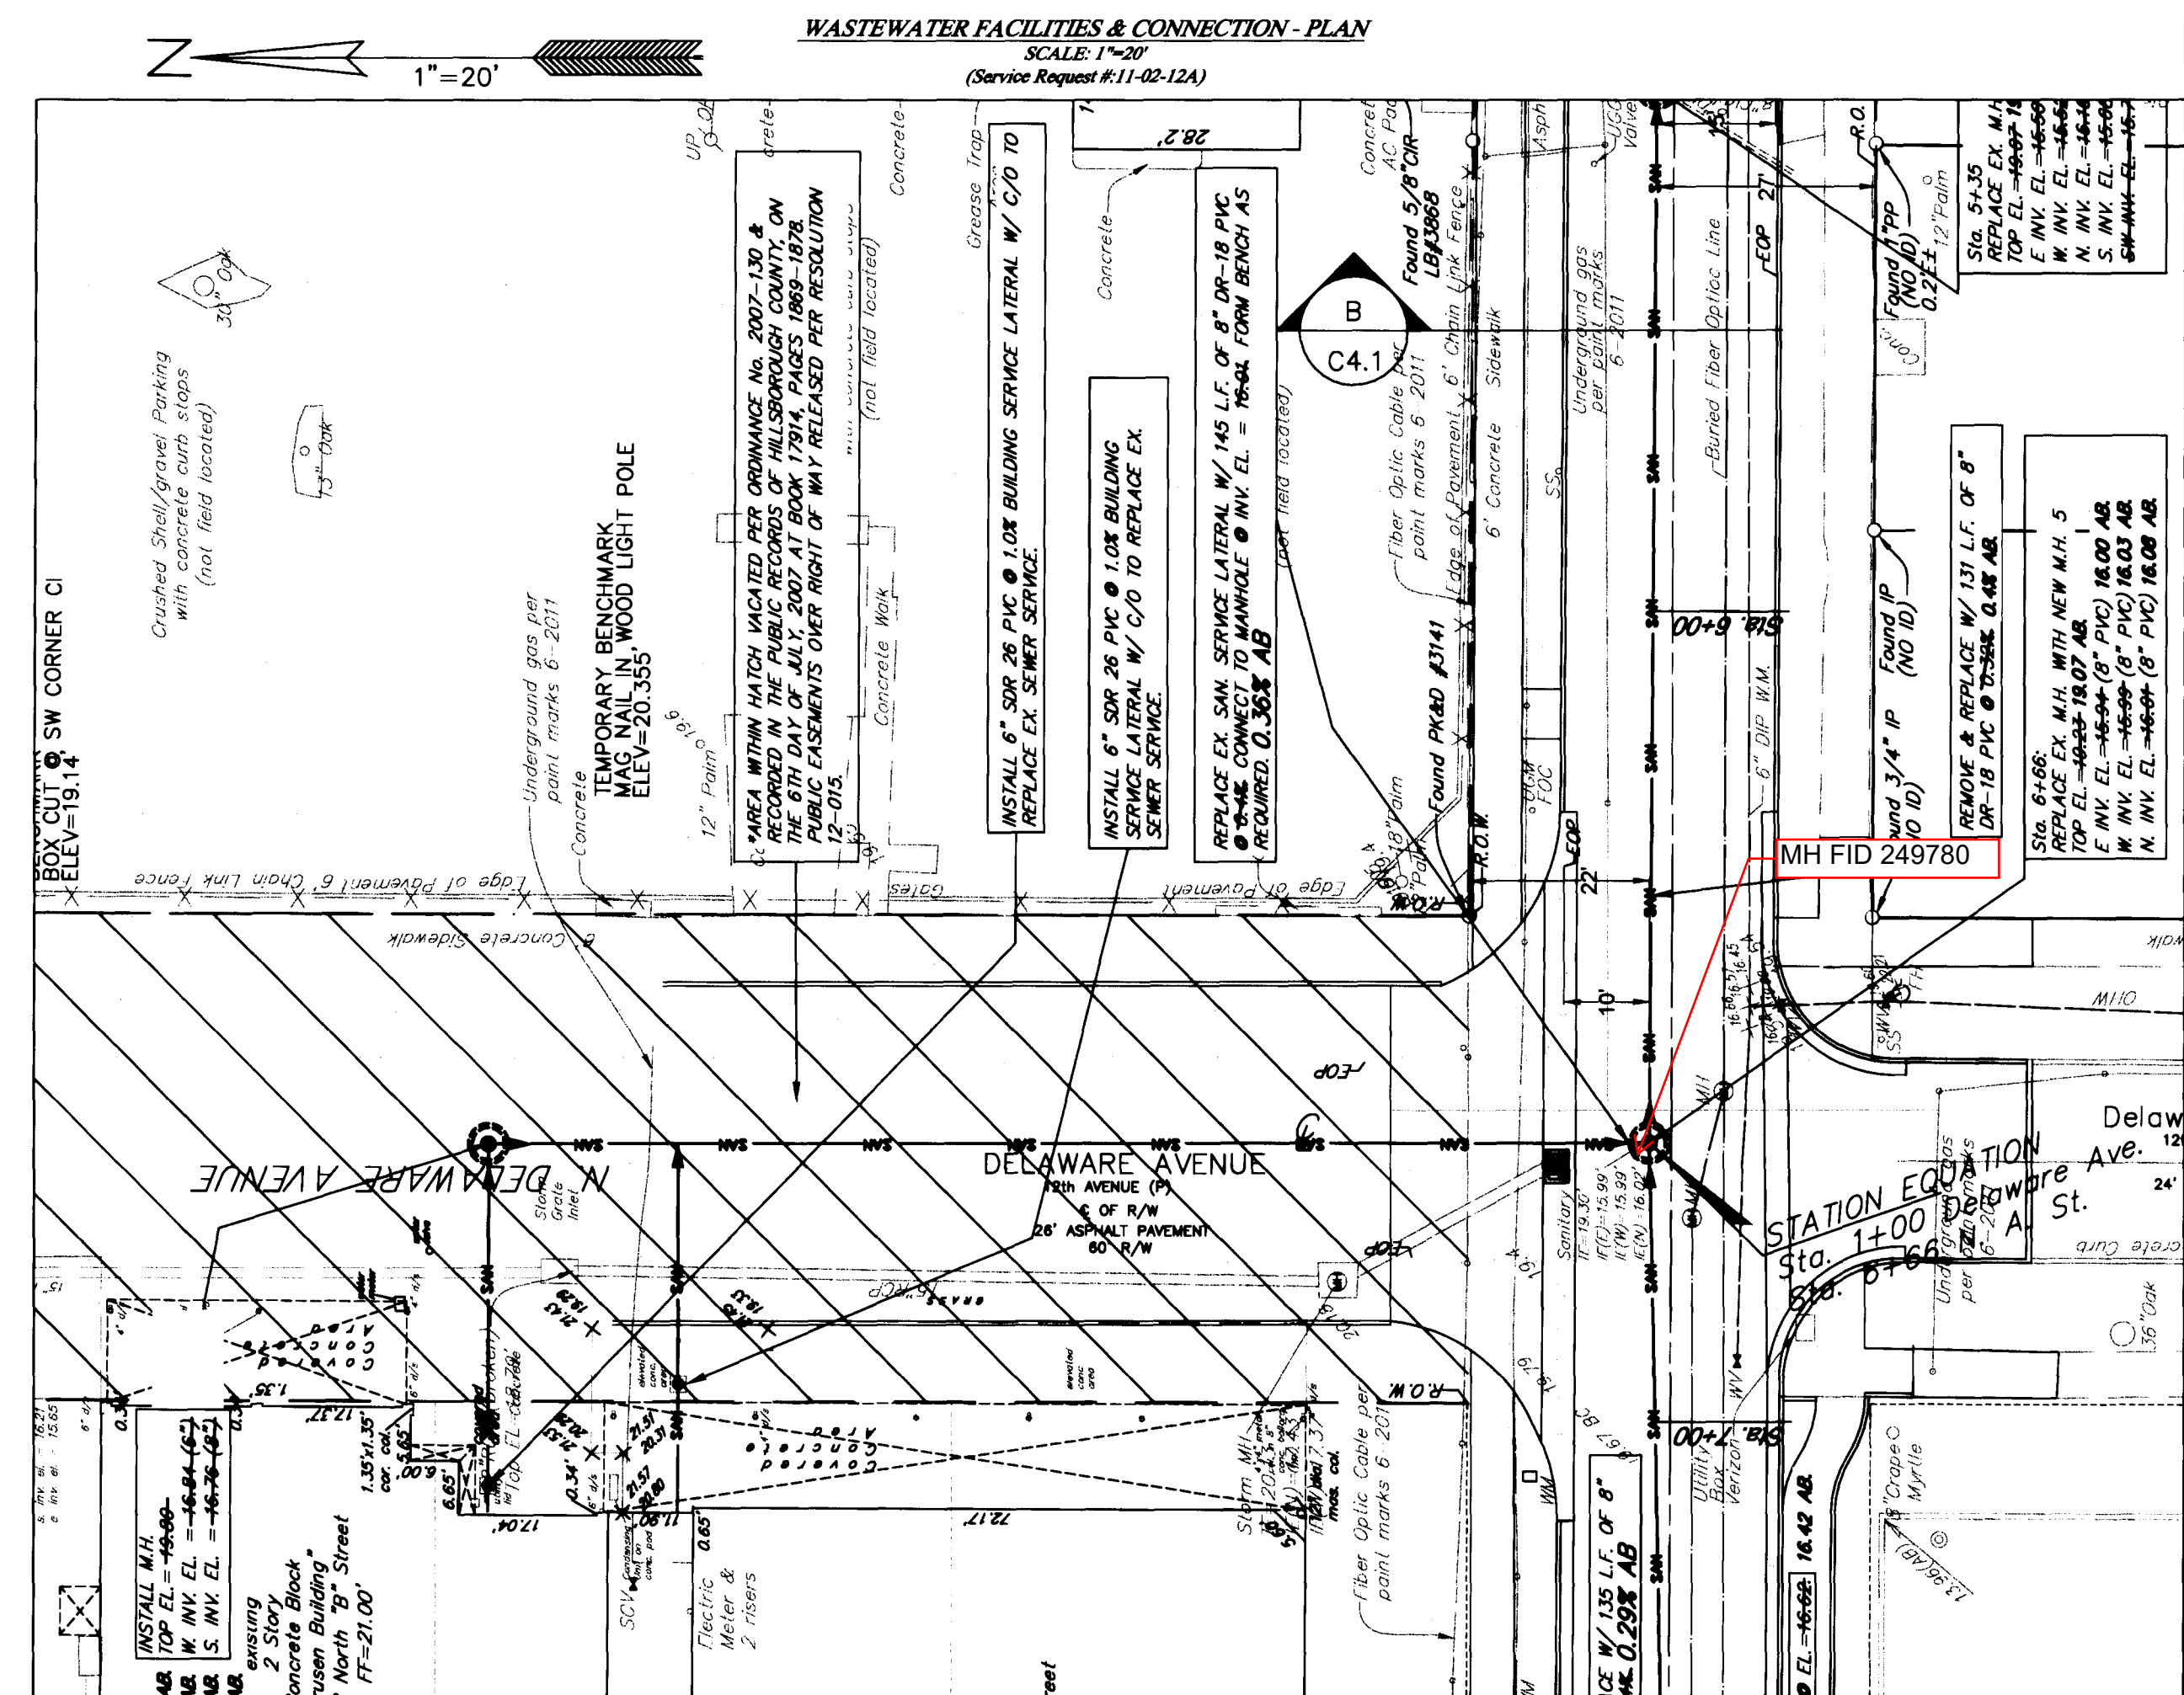

*Location of existing utilities shown are approximate. Contractor shall field verify location of all existing utilities and shall expose them prior to installation and ensure that the proposed pipe will cross all existing utilities with acceptable clearance.

WASTEWATER FACILITIES & CONNECTION - PROFILE
SCALE:
HORIZ: 1"=20'
VERT: 1"=5'
(Service Request #:11-02-12A)

AS-BUILT: 8/20/13

[illegible]

MILLS and ASSOCIATES, INC.
CONSULTING ENGINEERS & LAND SURVEYORS

3242 HENDERSON BOULEVARD * SUITE 300
TAMPA, FLORIDA 33609-3056
TELEPHONE: (813) 876-5869

FOR
THE UNIVERSITY OF TAMPA

401 W. KENNEDY BLVD.
TAMPA, FLORIDA 33606
TELEPHONE: (813) 258-7256

DRWN BY: ATG DATE 11/29/11
 DSGN BY: ATG DATE 10/30/12
 CHKD BY: LEM DATE _____
 SCALE: 1" = 20'

LG 0122/13
LAWRENCE E. MILLS
P.E. NO. 22324 - E.B. NO. 3860
P.L.S. NO. 3141 - L.B. NO. 3868
STATE OF FLORIDA



PROJECT
N. A ST. SEWER
REPLACEMENT

*PLAN & PROFILE &
Edison Paving & Grading Plan*

SHEET	C 1.4
JOB NO.	12-015

2013-284

- GENERAL NOTES:
1. The Contractor shall maintain wastewater service during all phases of the construction of the new sanitary sewer replacement. Prior to starting construction, shop drawings for bypassing the wastewater flow and maintaining service shall be submitted to the City of Tampa's Wastewater Department for review and approval.
 2. At utility crossings install joint equidistant from center of crossing utility pipe. (Typ.)
 3. Return all disturbed areas to existing or better conditions. (Typ.)
 4. Restore disturbed road way per FDOT Index # 307. (Typ.)
 5. All work must comply with C.O.T. Wastewater Technical Manual. (Typ.)
 6. Pipe Bedding to comply with C.O.T. Wastewater Technical Manual. (Typ.)
 7. Existing pipes should be connected to the new manholes by providing an 8" PVC stub from the manhole and connecting the stub to the existing pipe using a flexible adapter.
 8. All lateral along the alignment of the proposed sanitary sewer replacement that are in service and/or connected to an existing building shall be replaced from the property line to the new pipeline. A clean-out shall be provided at the property line.
 9. CONTRACTOR TO VERIFY LOCATION AND ELEVATIONS OF ALL EXISTING UNDER GROUND UTILITIES PRIOR TO PIPE INSTALLATION.

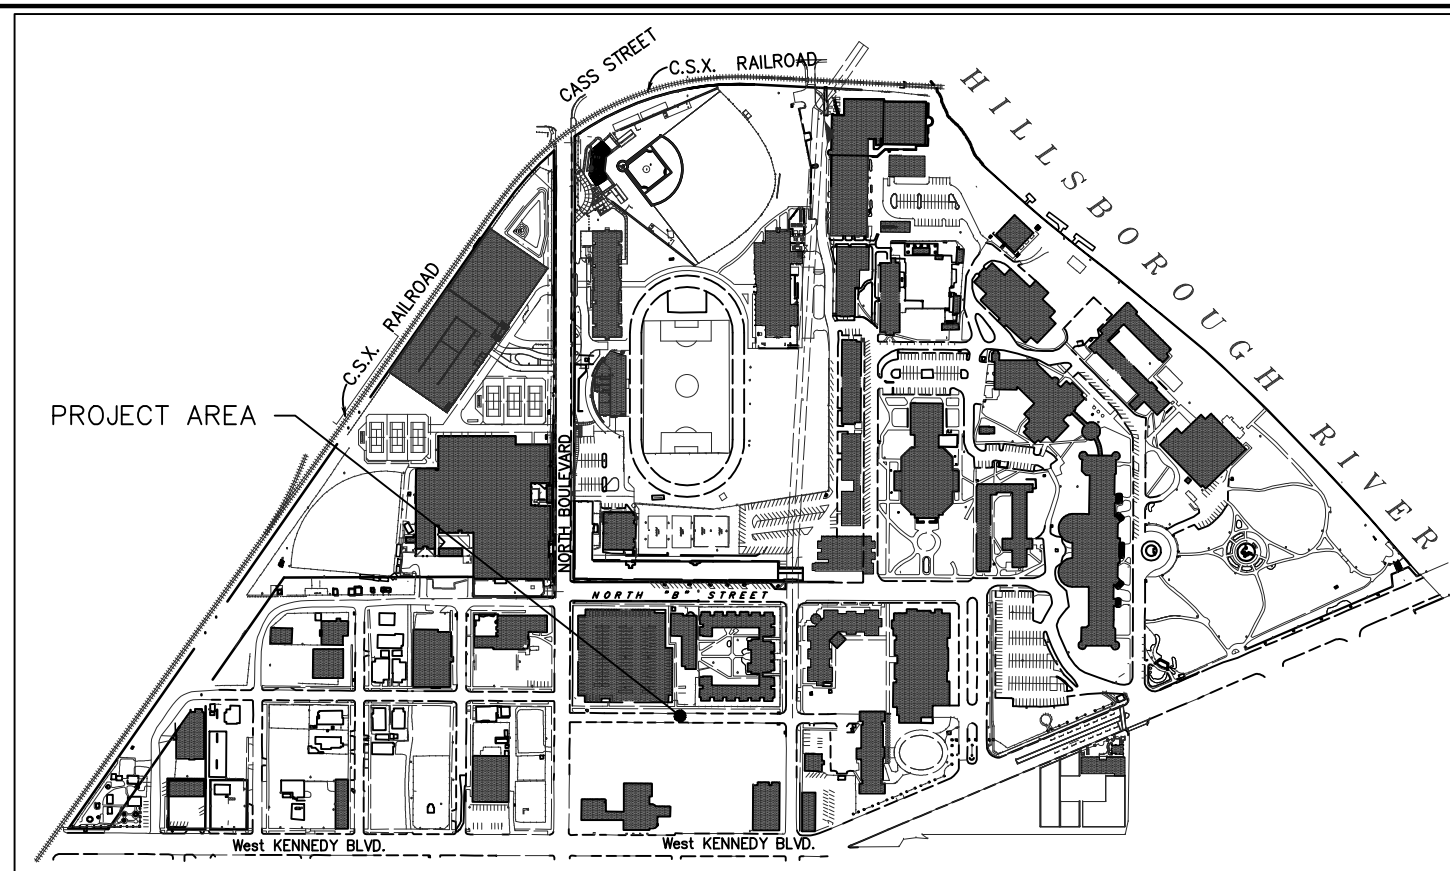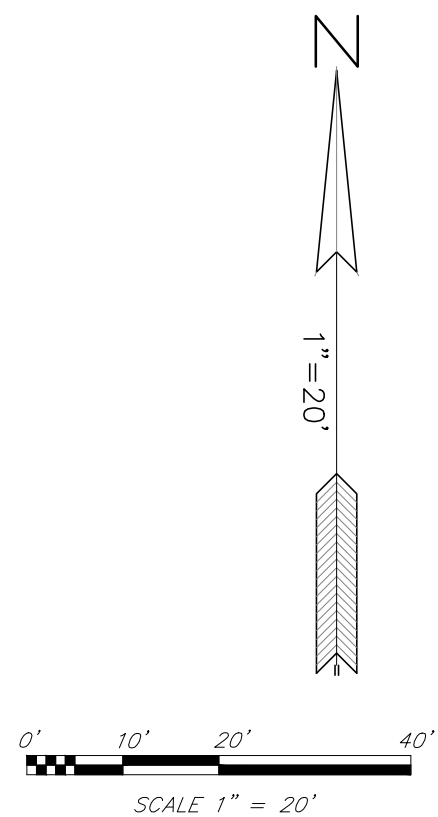

NOTE TO CONTRACTOR:
CONTRACTOR TO CALL SUNSHINE STATE ONE-CALL OF FLORIDA, 1-800-432-4770 A MINIMUM OF 2 DAYS PRIOR TO EXCAVATION


FOR WORK IN THE RIGHT-OF-WAY, IT IS THE CONTRACTOR'S RESPONSIBILITY TO OBTAIN A CITY OF TAMPA D.P.W. RIGHT-OF-WAY PERMIT (PHONE 813/274-8027).

All signage and striping to comply with the Manual for Uniform Traffic Control Devices (M.U.T.C.D.)

WASTEWATER FACILITIES & CONNECTION - PLAN


SCALE: 1"=20'

(Service Request #12-12-13A)

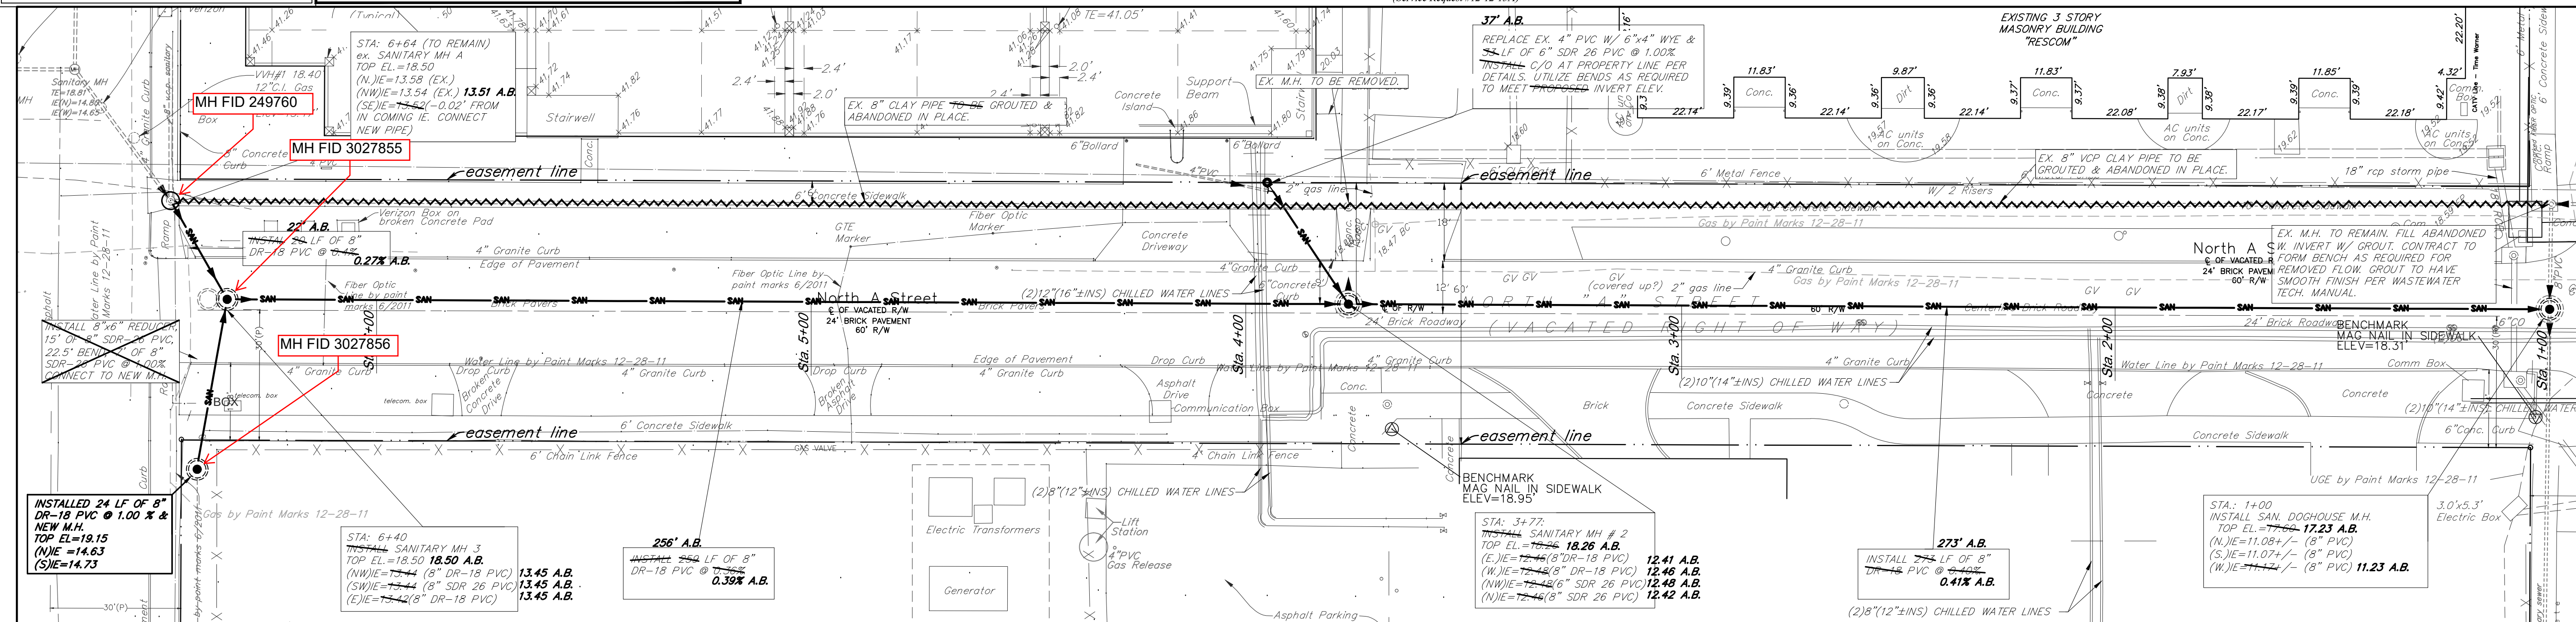

NORTH
KEY PLAN
SCALE: 1" = 500'

- LEGEND:
- (D) = Description Data
 - (P) = Plot Data
 - (M) = Measured Data
 - c/c = Cleanout
 - Conc. = Concrete
 - c.l.f. = Chain Link Fence
 - E.B. = Electric Box
 - F.H. = Fire Hydrant
 - g.a. = Guy Anchor
 - Inv. Elev. = Invert elevation
 - LB = Licensed Business
 - mas. = masonry
 - m.l.p. = metal light pole
 - O/A = Overall
 - OH&D = Overhead utility lines
 - PSM = Professional Surveyor & Mapper
 - R/O = Road Overhang
 - R/W = Right-of-way
 - (Typ.) = Typical
 - U.P. = Utility Pole
 - W.L.P. = wood light pole
 - W.M. = Water meter
 - W.V. = Water Valve
 - W.U.P. = Wood Utility Pole
 - N = North
 - S = South
 - E = East
 - W = West
 - M.E.G. = Match Existing Grade
 - = Proposed Top of Curb El./ Pavement El.
 - = Proposed Top of Sod El.
 - = Flow Direction
 - = Pipe Flow Direction

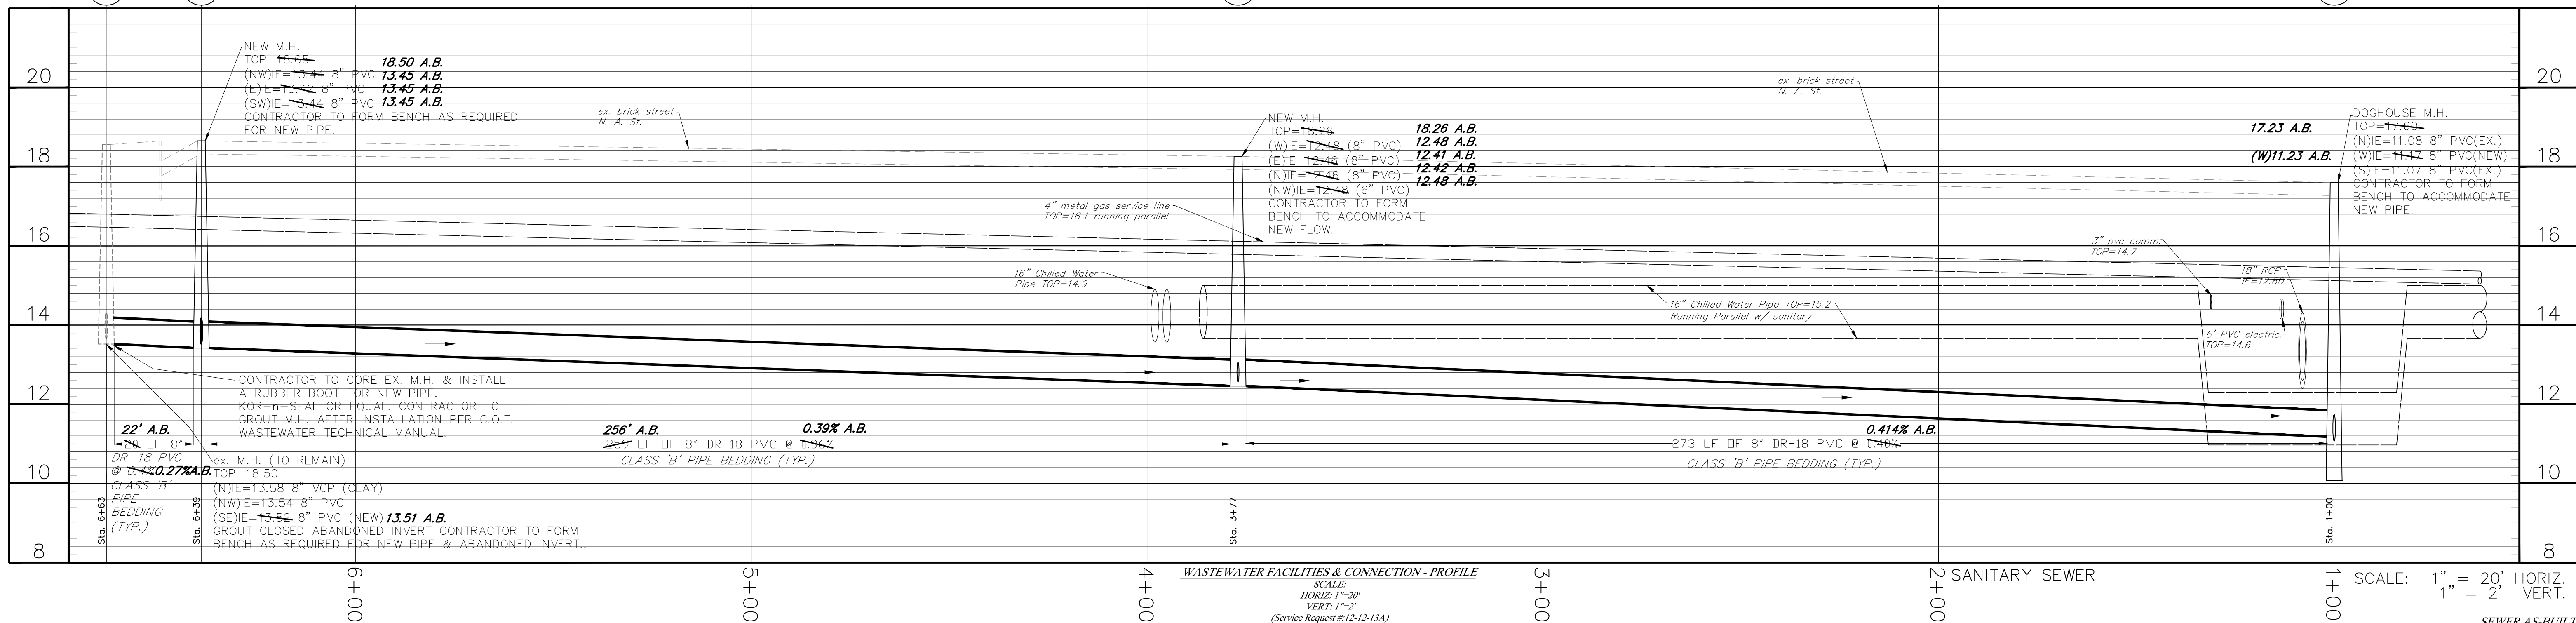

WASTEWATER FACILITIES & CONNECTION - PROFILE

SCALE: 1"=20'

(Service Request #12-12-13A)

SCALE: 1" = 20' HORIZ.
1" = 2' VERT.

SEWER AS-BUILTS 12/09/14

REVISIONS					
BY	DATE	DESCRIPTION	BY	DATE	DESCRIPTION
ATG	2/7/14	Revised Pipe Route			

MILLS and ASSOCIATES, INC.
CONSULTING ENGINEERS & LAND SURVEYORS
3242 HENDERSON BOULEVARD * SUITE 300
TAMPA, FLORIDA 33609-3056
TELEPHONE: (813) 876-5869

FOR

UNIVERSITY OF TAMPA

DRWN BY: RFS
DSGN BY: ATG
CHKD BY: LEM
SCALE: 1" = 20'
DATE: 12/23/13
DATE: 2/7/14
DATE:

LAWRENCE E. MILLS
P.E. NO. 22324 - E.B. NO. 3860
P.L.S. NO. 3141 - L.B. NO. 3868
STATE OF FLORIDA

PROJECT
THOMAS PARKING GARAGE
EXPANSION
SEWER MAIN REPLACEMENT
PLANS

SHEET
WW 1.1
JOB NO.
11-019

2015-018

SPE-650

