

TAMPA, FLORIDA
SEPTEMBER 13, 2023
BID DOCUMENTS



Consultants:

[illegible]

Seal

Project No.:	200039.00
Issue Date:	09/18/2023

Drawn By: GRD
Approved By: TKE
Scale:

Drawing Title:
COVER SHEET

Drawing No.: C-1

NOTE: SOME SYMBOLS SHOWN ON THIS LEGEND MAY NOT PERTAIN TO THIS PROJECT.

APPLICABLE CODES

APPLICABLE CODES:
ALL WORK UNDER THIS DIVISION SHALL BE IN STRICT COMPLIANCE AND IN ACCORDANCE WITH THE APPLICABLE PROVISIONS OF THE FOLLOWING CODES AND STANDARDS INCLUDING THE REGULATIONS OF GOVERNING LOCAL, STATE, COUNTY AND OTHER APPLICABLE CODES. REFER TO SPECIFICATIONS FOR ADDITIONAL CODE REQUIREMENTS:

BUILDING CODES:

- FLORIDA BUILDING CODE, 7TH EDITION (2020)
- FLORIDA ENERGY CONSERVATION CODE, 7TH EDITION (2020)
- FLORIDA FIRE PREVENTION CODE, 7TH EDITION (2020)

ADDITIONAL CODES, STANDARDS, AND REQUIREMENTS

1. AMERICAN NATIONAL STANDARDS INSTITUTE (ANSI)
2. INSTITUTE OF ELECTRICAL AND ELECTRONIC ENGINEERS (IEEE)
3. NATIONAL ELECTRICAL MANUFACTURERS ASSOCIATION (NEMA)
4. REQUIREMENTS OF LOCAL POWER COMPANY
5. THE AMERICANS WITH DISABILITIES ACT (ADA)
6. OWNER'S PUBLISHED DESIGN STANDARDS
7. FGI GUIDELINES FOR DESIGN AND CONSTRUCTION OF HOSPITALS AND OUTPATIENT FACILITIES (2014)

ALL MATERIALS SHALL BE NEW AND FREE OF DEFECTS, AND SHALL BE LISTED BY A NATIONALLY RECOGNIZED TESTING LAB, AS DEFINED BY OSHA, WHERE NO LABELING OR LISTING SERVICE IS AVAILABLE FOR CERTAIN TYPES OF EQUIPMENT. TEST DATA SHALL BE SUBMITTED TO VALIDATE THAT EQUIPMENT MEETS OR EXCEEDS AVAILABLE STANDARDS.

- NFPA 12, 2018 EDITION, STANDARD FOR PORTABLE FIRE EXTINGUISHERS.
- NFPA 13, 2016 EDITION, STANDARD FOR THE INSTALLATION OF SPRINKLER SYSTEMS.
- NFPA 20, 2016 EDITION, STANDARD FOR THE INSTALLATION OF STATIONARY PUMPS FOR FIRE PROTECTION.
- NFPA 30, 2012 EDITION, FLAMMABLE AND COMBUSTIBLE LIQUIDS CODE.
- NFPA 37, 2018 EDITION, STANDARD FOR THE INSTALLATION AND USE OF STATIONARY COMBUSTION ENGINES AND GAS TURBINES.
- NFPA 45, 2015 EDITION, STANDARD ON FIRE PROTECTION FOR LABORATORIES USING CHEMICALS.
- NFPA 54, 2018 EDITION, NATIONAL FUEL GAS CODE.
- NFPA 70, 2017 EDITION, NATIONAL ELECTRICAL CODE.
- NFPA 72, 2016 EDITION, NATIONAL FIRE ALARM AND SIGNALING CODE.
- NFPA 75, 2017 EDITION, STANDARD FOR THE PROTECTION OF INFORMATION TECHNOLOGY EQUIPMENT.
- NFPA 79, 2016 EDITION, STANDARD FOR PREVENTING FIRE HAZARDS FROM ELECTRIC EQUIPMENT.
- NFPA 85, 2015 EDITION, BOLLER AND COMBUSTION SYSTEMS HAZARDS CODE.
- NFPA 88A, 2015 EDITION, STANDARD FOR PARKING STRUCTURES.
- NFPA 91, 2018 EDITION, STANDARD FOR THE INSTALLATION OF AIR-CONDITIONING AND VENTILATING SYSTEMS.
- NFPA 98B, 2018 EDITION, STANDARD FOR THE INSTALLATION OF WARM AIR HEATING AND AIR-CONDITIONING SYSTEMS.
- NFPA 99, 2015 EDITION, STANDARD FOR SMOKE-CONTROL SYSTEMS.
- NFPA 99, 2018 EDITION, HEALTH CARE FACILITIES CODE.
- NFPA 101, 2018 EDITION, STANDARD FOR SAFETY OF LIFE.
- NFPA 110, 2016 EDITION, STANDARD FOR EMERGENCY AND STANDBY POWER SYSTEMS.
- NFPA 111, 2016 EDITION, STANDARD ON STORED ELECTRICAL ENERGY EMERGENCY AND STANDBY POWER SYSTEMS.
- NFPA 780, 2017 EDITION, INSTALLATION OF LIGHTNING PROTECTION SYSTEMS.

A CONVENTION CENTER WORK

[illegible]

Project No.:	200039.00
Issue Date:	09/18/2023
Drawn By:	GRD
Approved By:	TKB
Scale:	12" = 1'-0"

Drawing Title:
**ELECTRICAL
LEGENDS, SYMBOLS,
NOTES AND INDEX**

Drawing No.:
E000



333 S FRANKLIN STREET TAMPA, FL 33602

KEY PLAN (AREA OF WORK)


The key plan shows the layout of the site with a vertical line indicating the centerline. A north arrow is located in the bottom right corner, pointing towards the bottom right of the page.

Project No.:	200039.00
Issue Date:	09/18/2023
Drawn By:	GRD
Approved By:	TKR
Scale:	1/32" = 1'-0"
Drawing Title:	
BALLROOM LEVEL OVERALL PLAN ELECTRICAL	

Drawing No.: E101



© Copyright 2019 TLC Engineering Solutions, Inc.
TLC Project No. : 722136
THINK. LISTEN. CREATE.

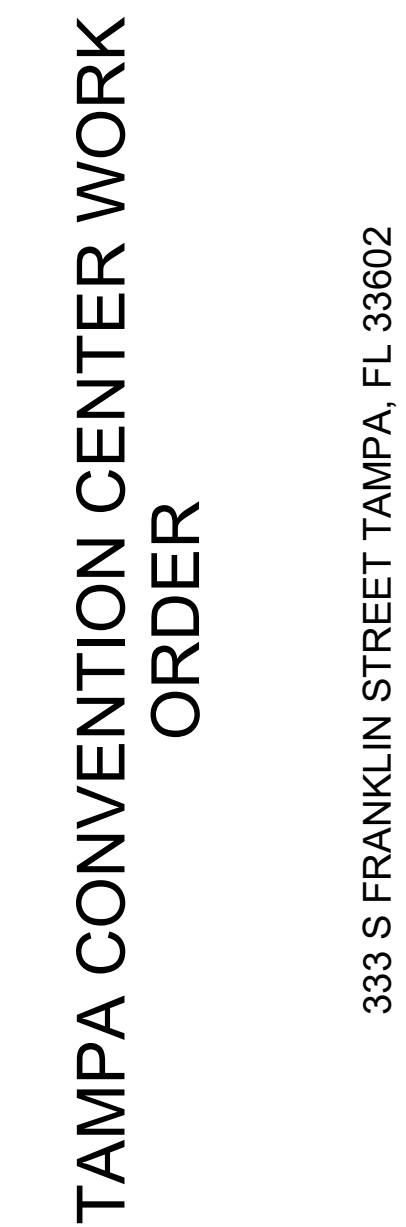Seal

Drawing No.: E102




1	OFFICE LEVEL OVERALL - POWER			
	1/32" = 1'-0"			



© Copyright 2019 TLC Engineering Solutions, Inc.
TLC Project No. : 722136
THINK. LISTEN. CREATE.

TAMPA CONVENTION CENTER WORK
ORDER

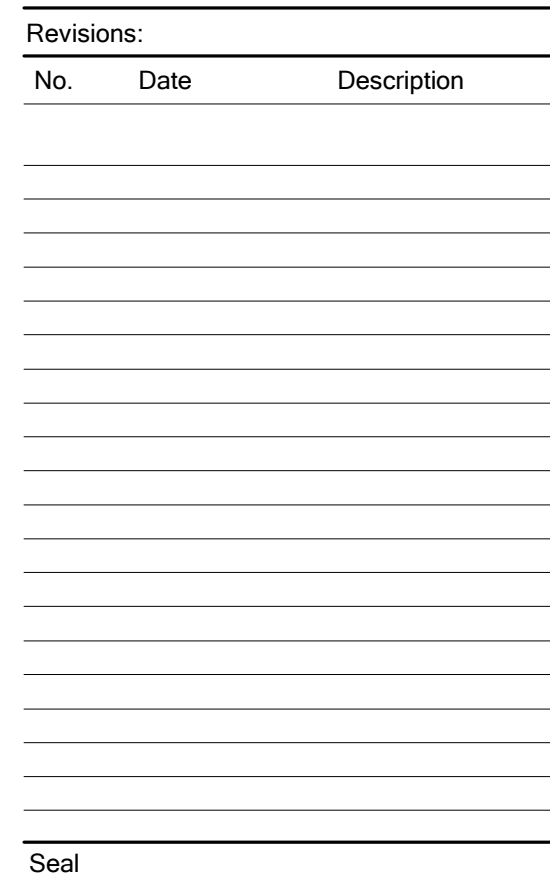


Project No.:	200039.00
Issue Date:	09/18/2023
Drawn By:	GRD
Approved By:	TKB
Scale:	1/32" = 1'-0"
Drawing Title: FIN FL CATWALK OVERALL PLAN ELECTRICAL	
Drawing No.:	E105

333 S FRANKLIN STREET TAMPA, FL 33602

[illegible]

Drawing No.:
E501



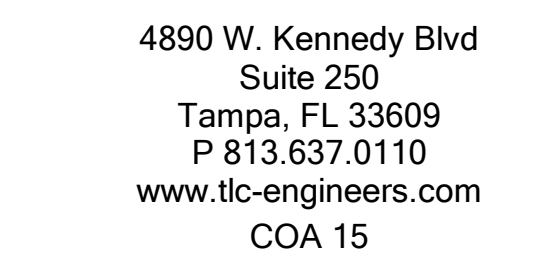

TAMPA CONVENTION CENTER WORK

333 S FRANKLIN STREET TAMPA, FL 33602

[illegible]

Project No.:	200039.00
Issue Date:	09/18/2023
Drawn By:	GRD
Approved By:	TKB
Scale:	12" = 1'-0"

Drawing No.:



TAMPA CONVENTION CENTER WORK
ORDER

333 S FRANKLIN STREET TAMPA, FL 33602

Consultants:

[illegible]


Seal

Project No.:	200039.0
Issue Date:	09/18/2022
Drawn By:	GR
Approved By:	TK
Scale:	12" = 1'-0"

Drawing Title:
**ELECTRICAL RISER
DIAGRAM**

Drawing No.:

E503

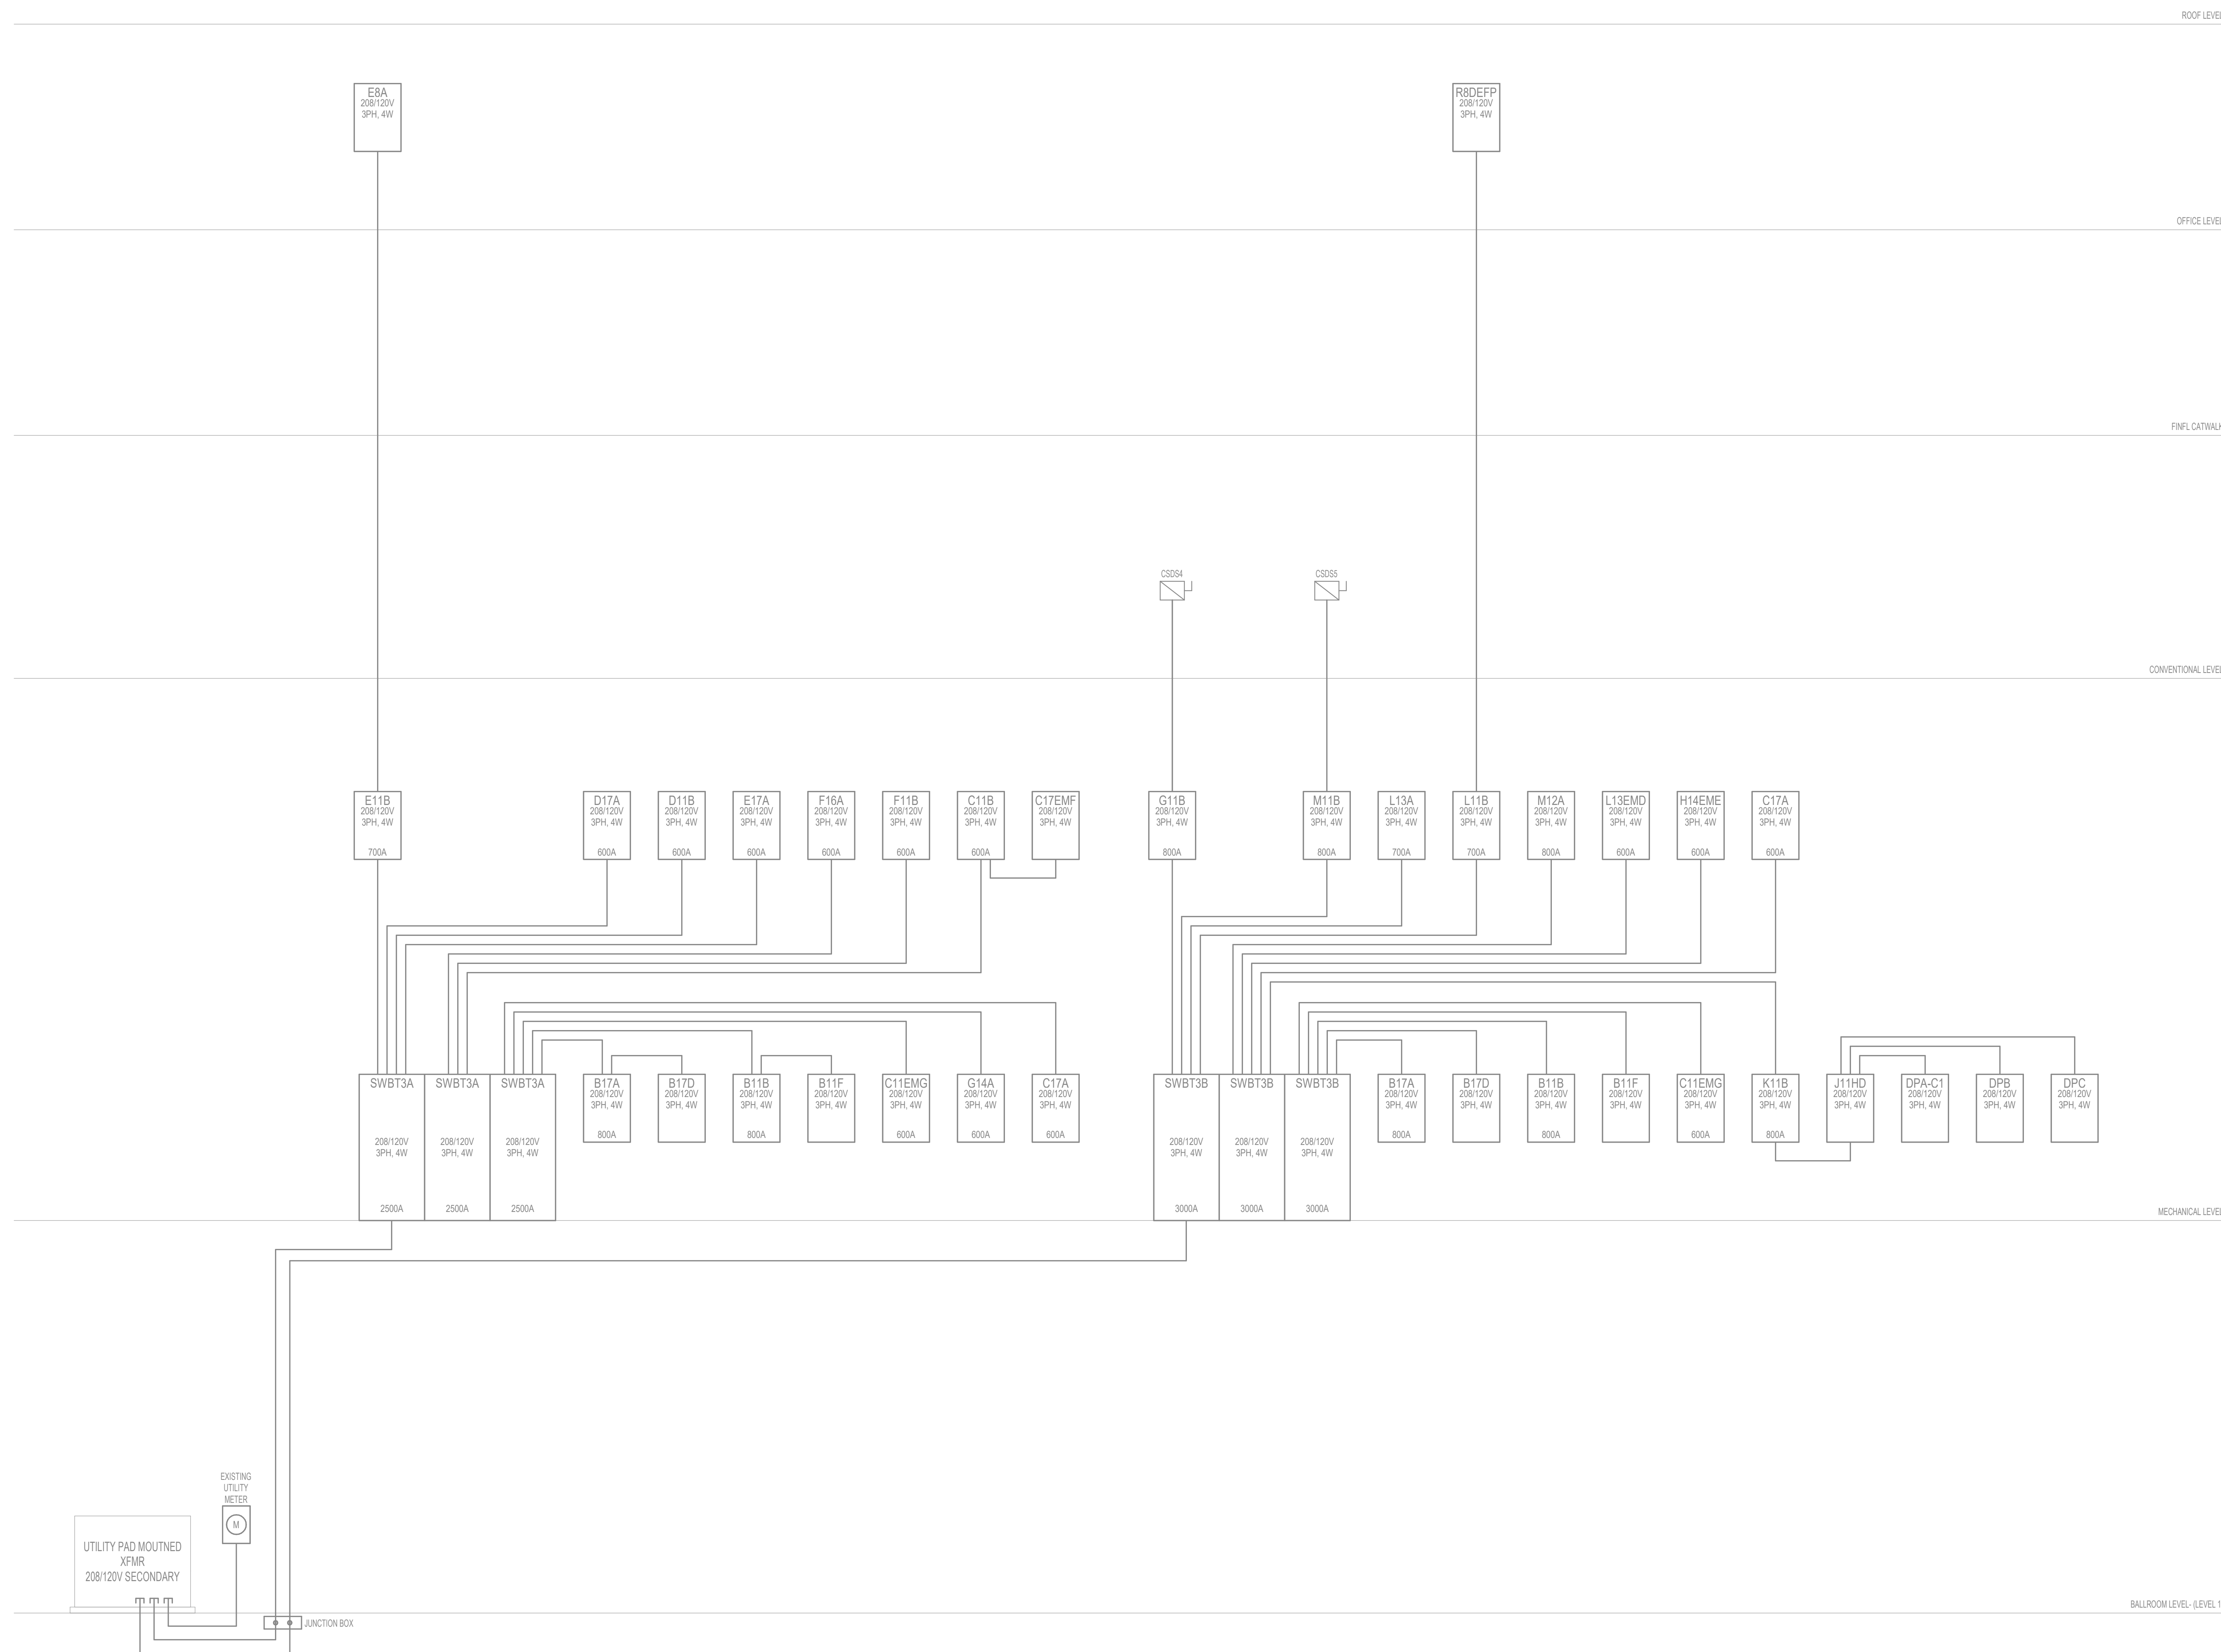


1 PARTIAL RISER DIAGRAM - SWBT3A & SWBT3B
12" = 1'-0"

333 S FRANKLIN STREET TAMPA, FL 33602

[illegible]

Drawing No.:
E504

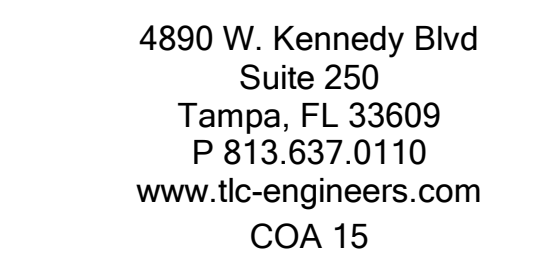

TAMPA CONVENTION CENTER WORK
ORDER

333 S FRANKLIN STREET TAMPA, FL 33602

[illegible]

Drawing Title:
**ELECTRICAL RISER
DIAGRAM**

1 PARTIAL RISER DIAGRAM - SWBT5 & SWBT2A
12" = 1'-0"

333 S FRANKLIN STREET TAMPA, FL 33602

[illegible]

Drawing Title:
**ELECTRICAL RISER
DIAGRAM**

Drawing No.: **E506**



333 S FRANKLIN STREET TAMPA, FL 33602

[illegible]

Project No.:	200039.00
Issue Date:	09/18/2023
Drawn By:	GRD
Approved By:	TKB
Scale:	12" = 1'-0"

Drawing No.: **E507**



TAMPA CONVENTION CENTER WORK
ORDER

Consultants:


[illegible]

Se

Project No.:	200039.00
Issue Date:	09/18/2023
Drawn By:	GRD
Approved By:	TKB
Scale:	12" = 1'-0"

Drawing Title:
**ELECTRICAL RISER
DIAGRAM**

Drawing No.:

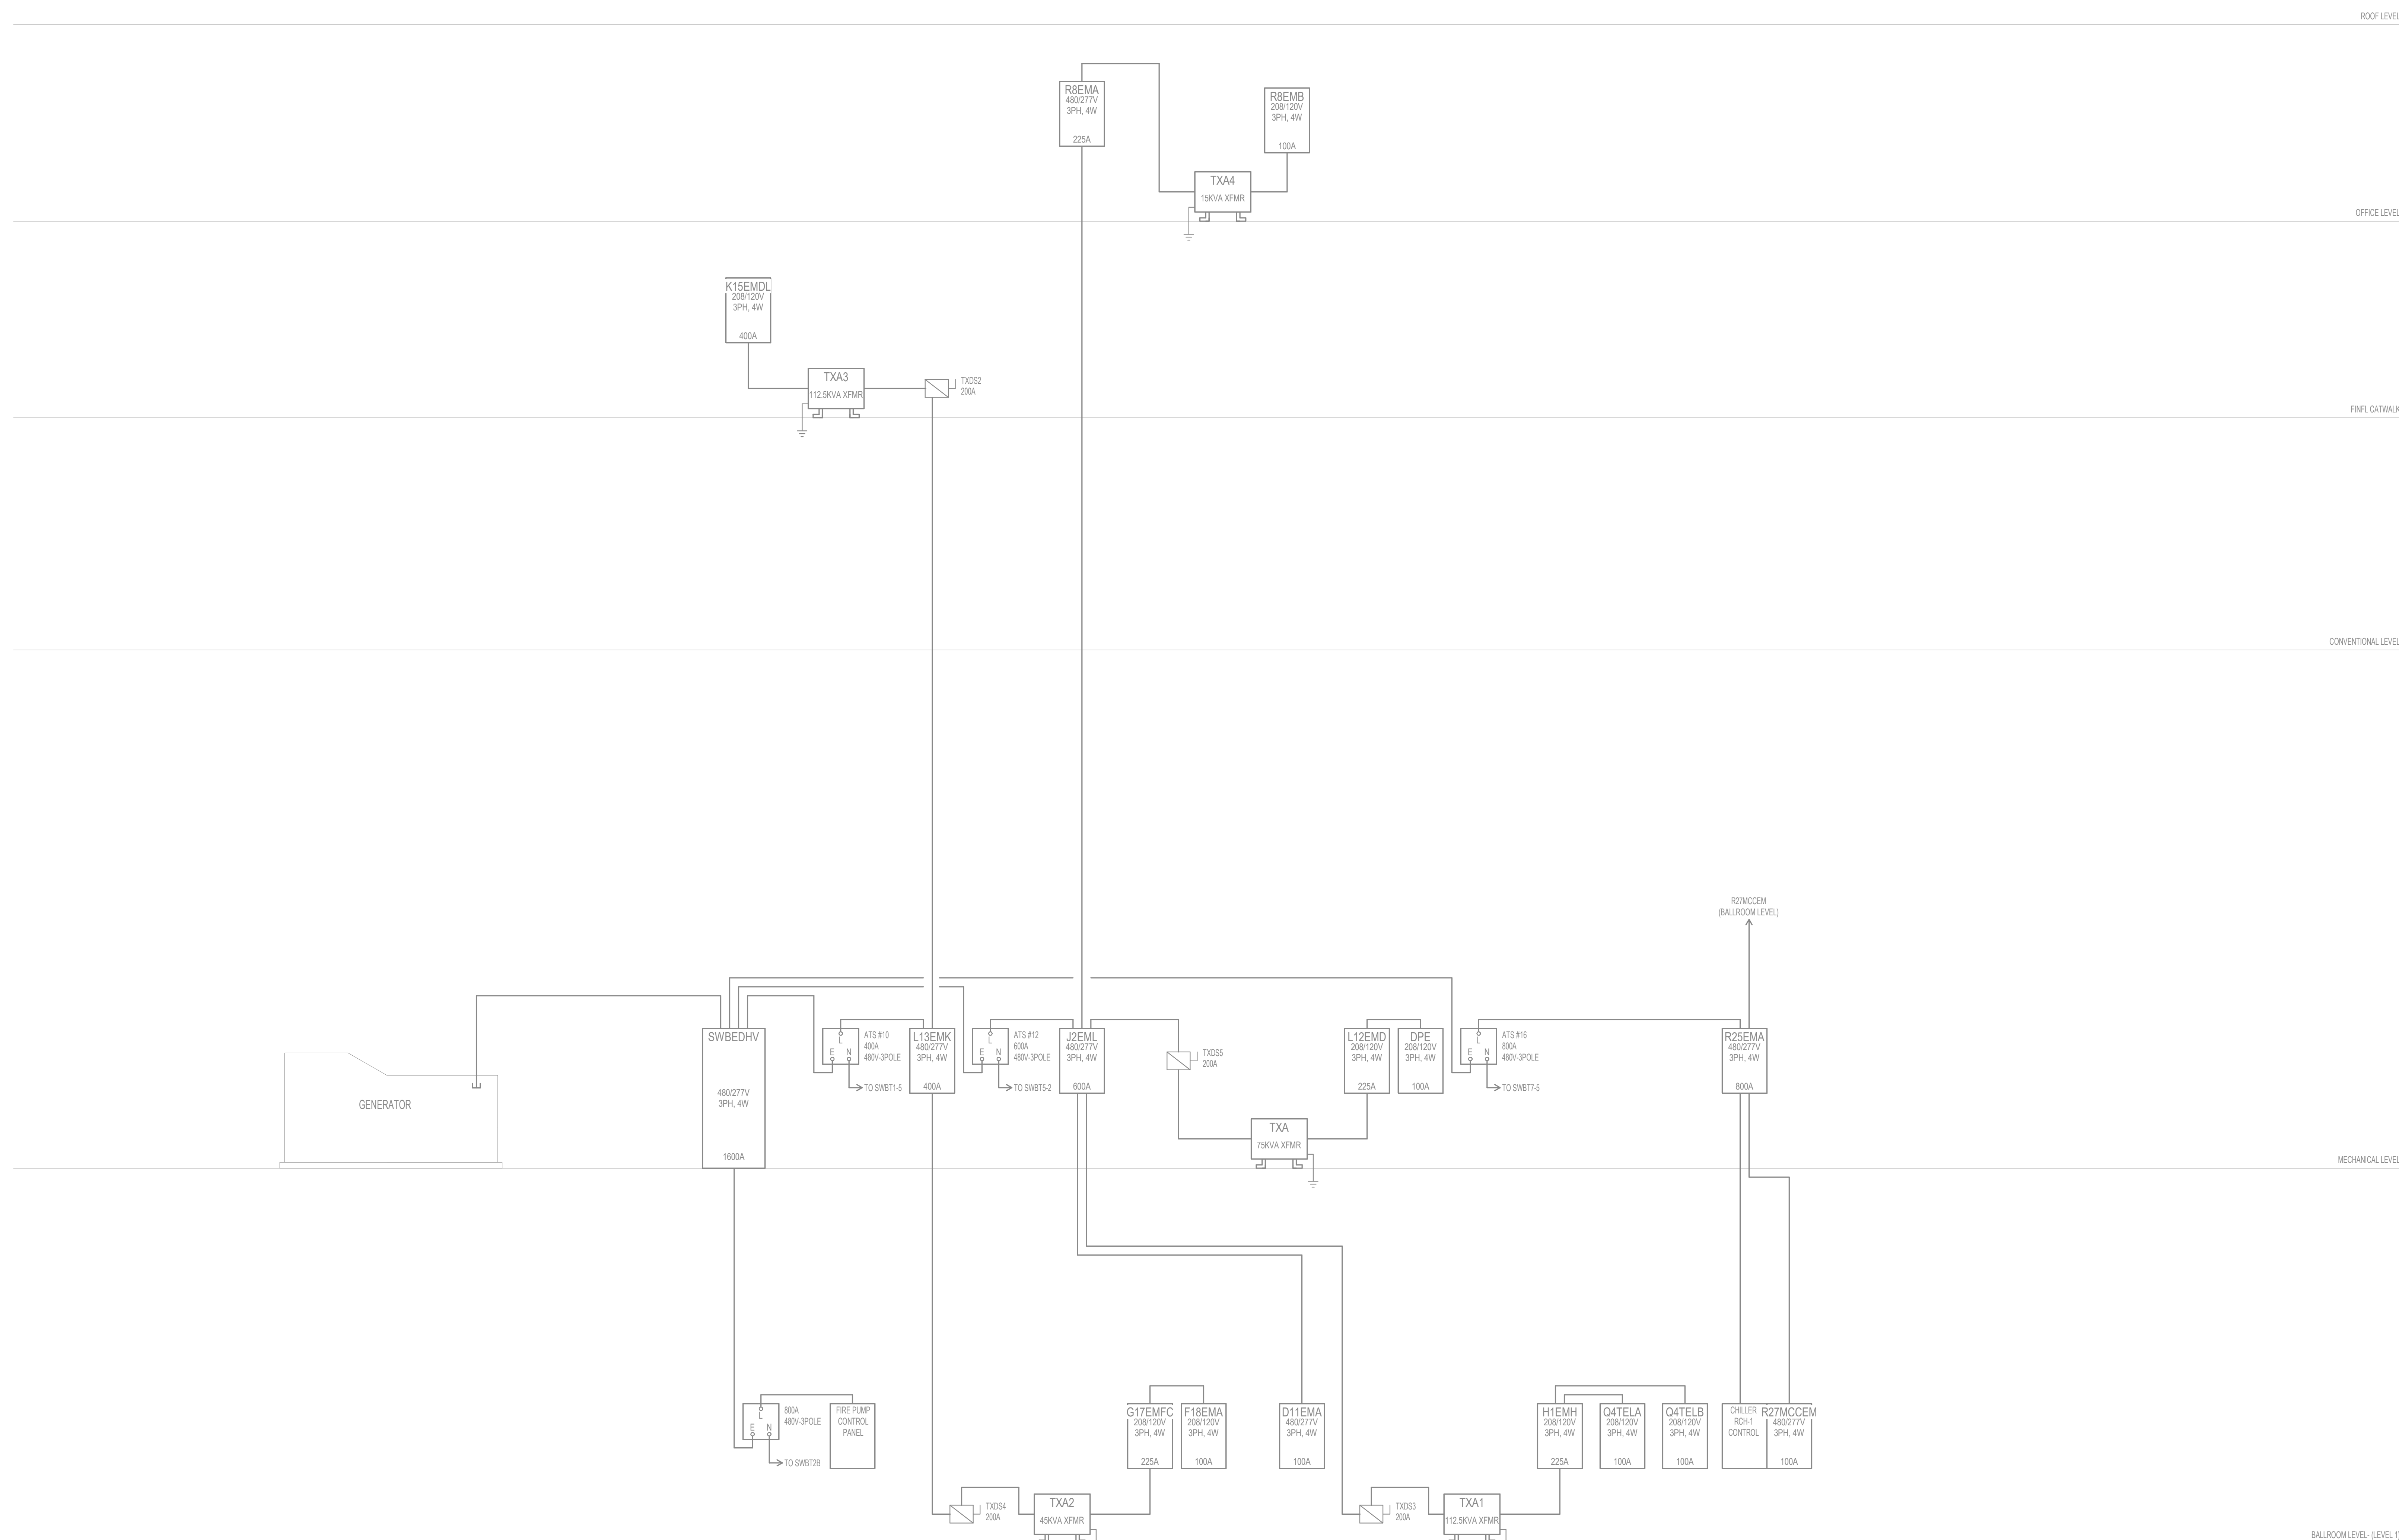

1 PARTIAL RISER DIAGRAM - SWBEDHV
12" = 1'-0"