

The Enclosed Document Is Provided For Your Convenience.

Please Email ALL Questions:
[MailTo:ContractAdministration@TampaGov.net](mailto:ContractAdministration@TampaGov.net)

Please Let Us Know If You Plan To Bid

City of Tampa
Contract Administration Department
306 E. Jackson St. #280A4N
Tampa, FL 33602
(813)274-8456

CITY OF TAMPA
CONTRACT NUMBER 17-C-00024
WEST TAMPA WATER TANK
ILLUMINATION PROJECT

(2201 N. HIMES AVENUE, TAMPA FLORIDA 33607)

PREPARED FOR

City of Tampa Water Department

DRAWING SCHEDULE

COVER SHEET

E0.1 SITE LIGHTING PLAN

E0.2 SITE PICTURES


E1.1 DETAILS, LEGENDS & SCHEDULES

S0.1 LUMINAIRE MOUNTING PLAN

PREPARED BY

***L*YLE
*E*NGINEERING
*G*ROUP, INC.**

LOCATOR MAP

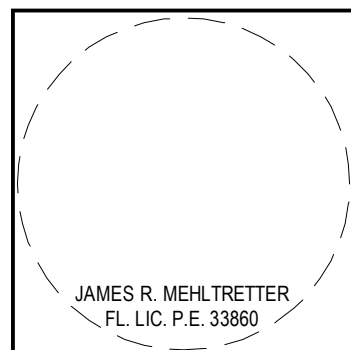


**MASTER
CONSULTING
ENGINEERS, INC.**




5523 WEST CYPRESS ST., #200
TAMPA, FLORIDA 33607
813.287.3600 FAX 813.287.3622
www.mcengineers.com

CA: 8426

CONSULTING ENGINEERS CA5380
8308 N. SAULRAY ST.
TAMPA, FLA. 33604
Phone: 813-935-5009
www.lyleengineeringgroup.com

DECEMBER 19, 2016

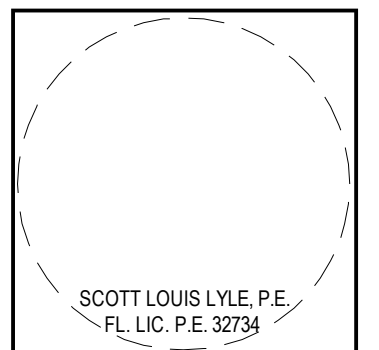

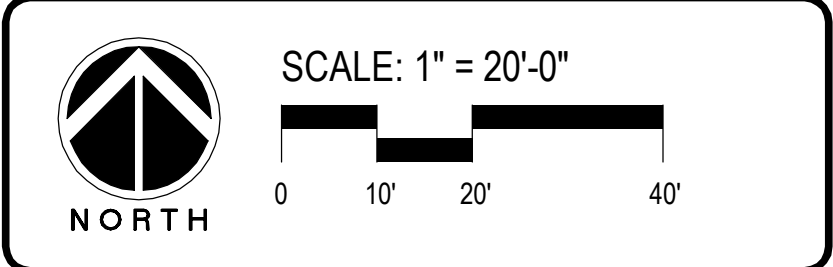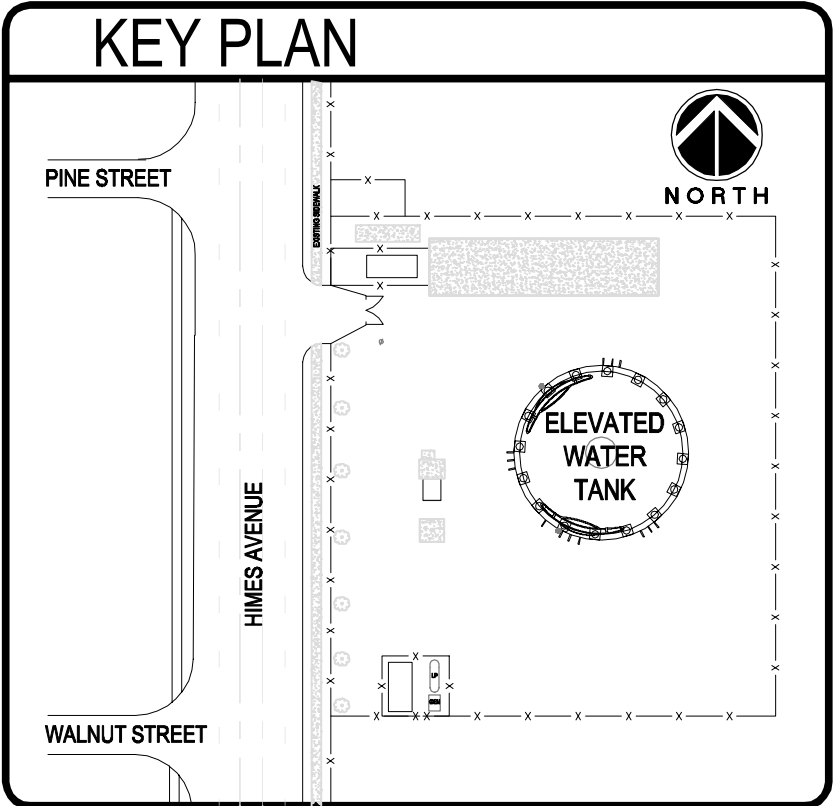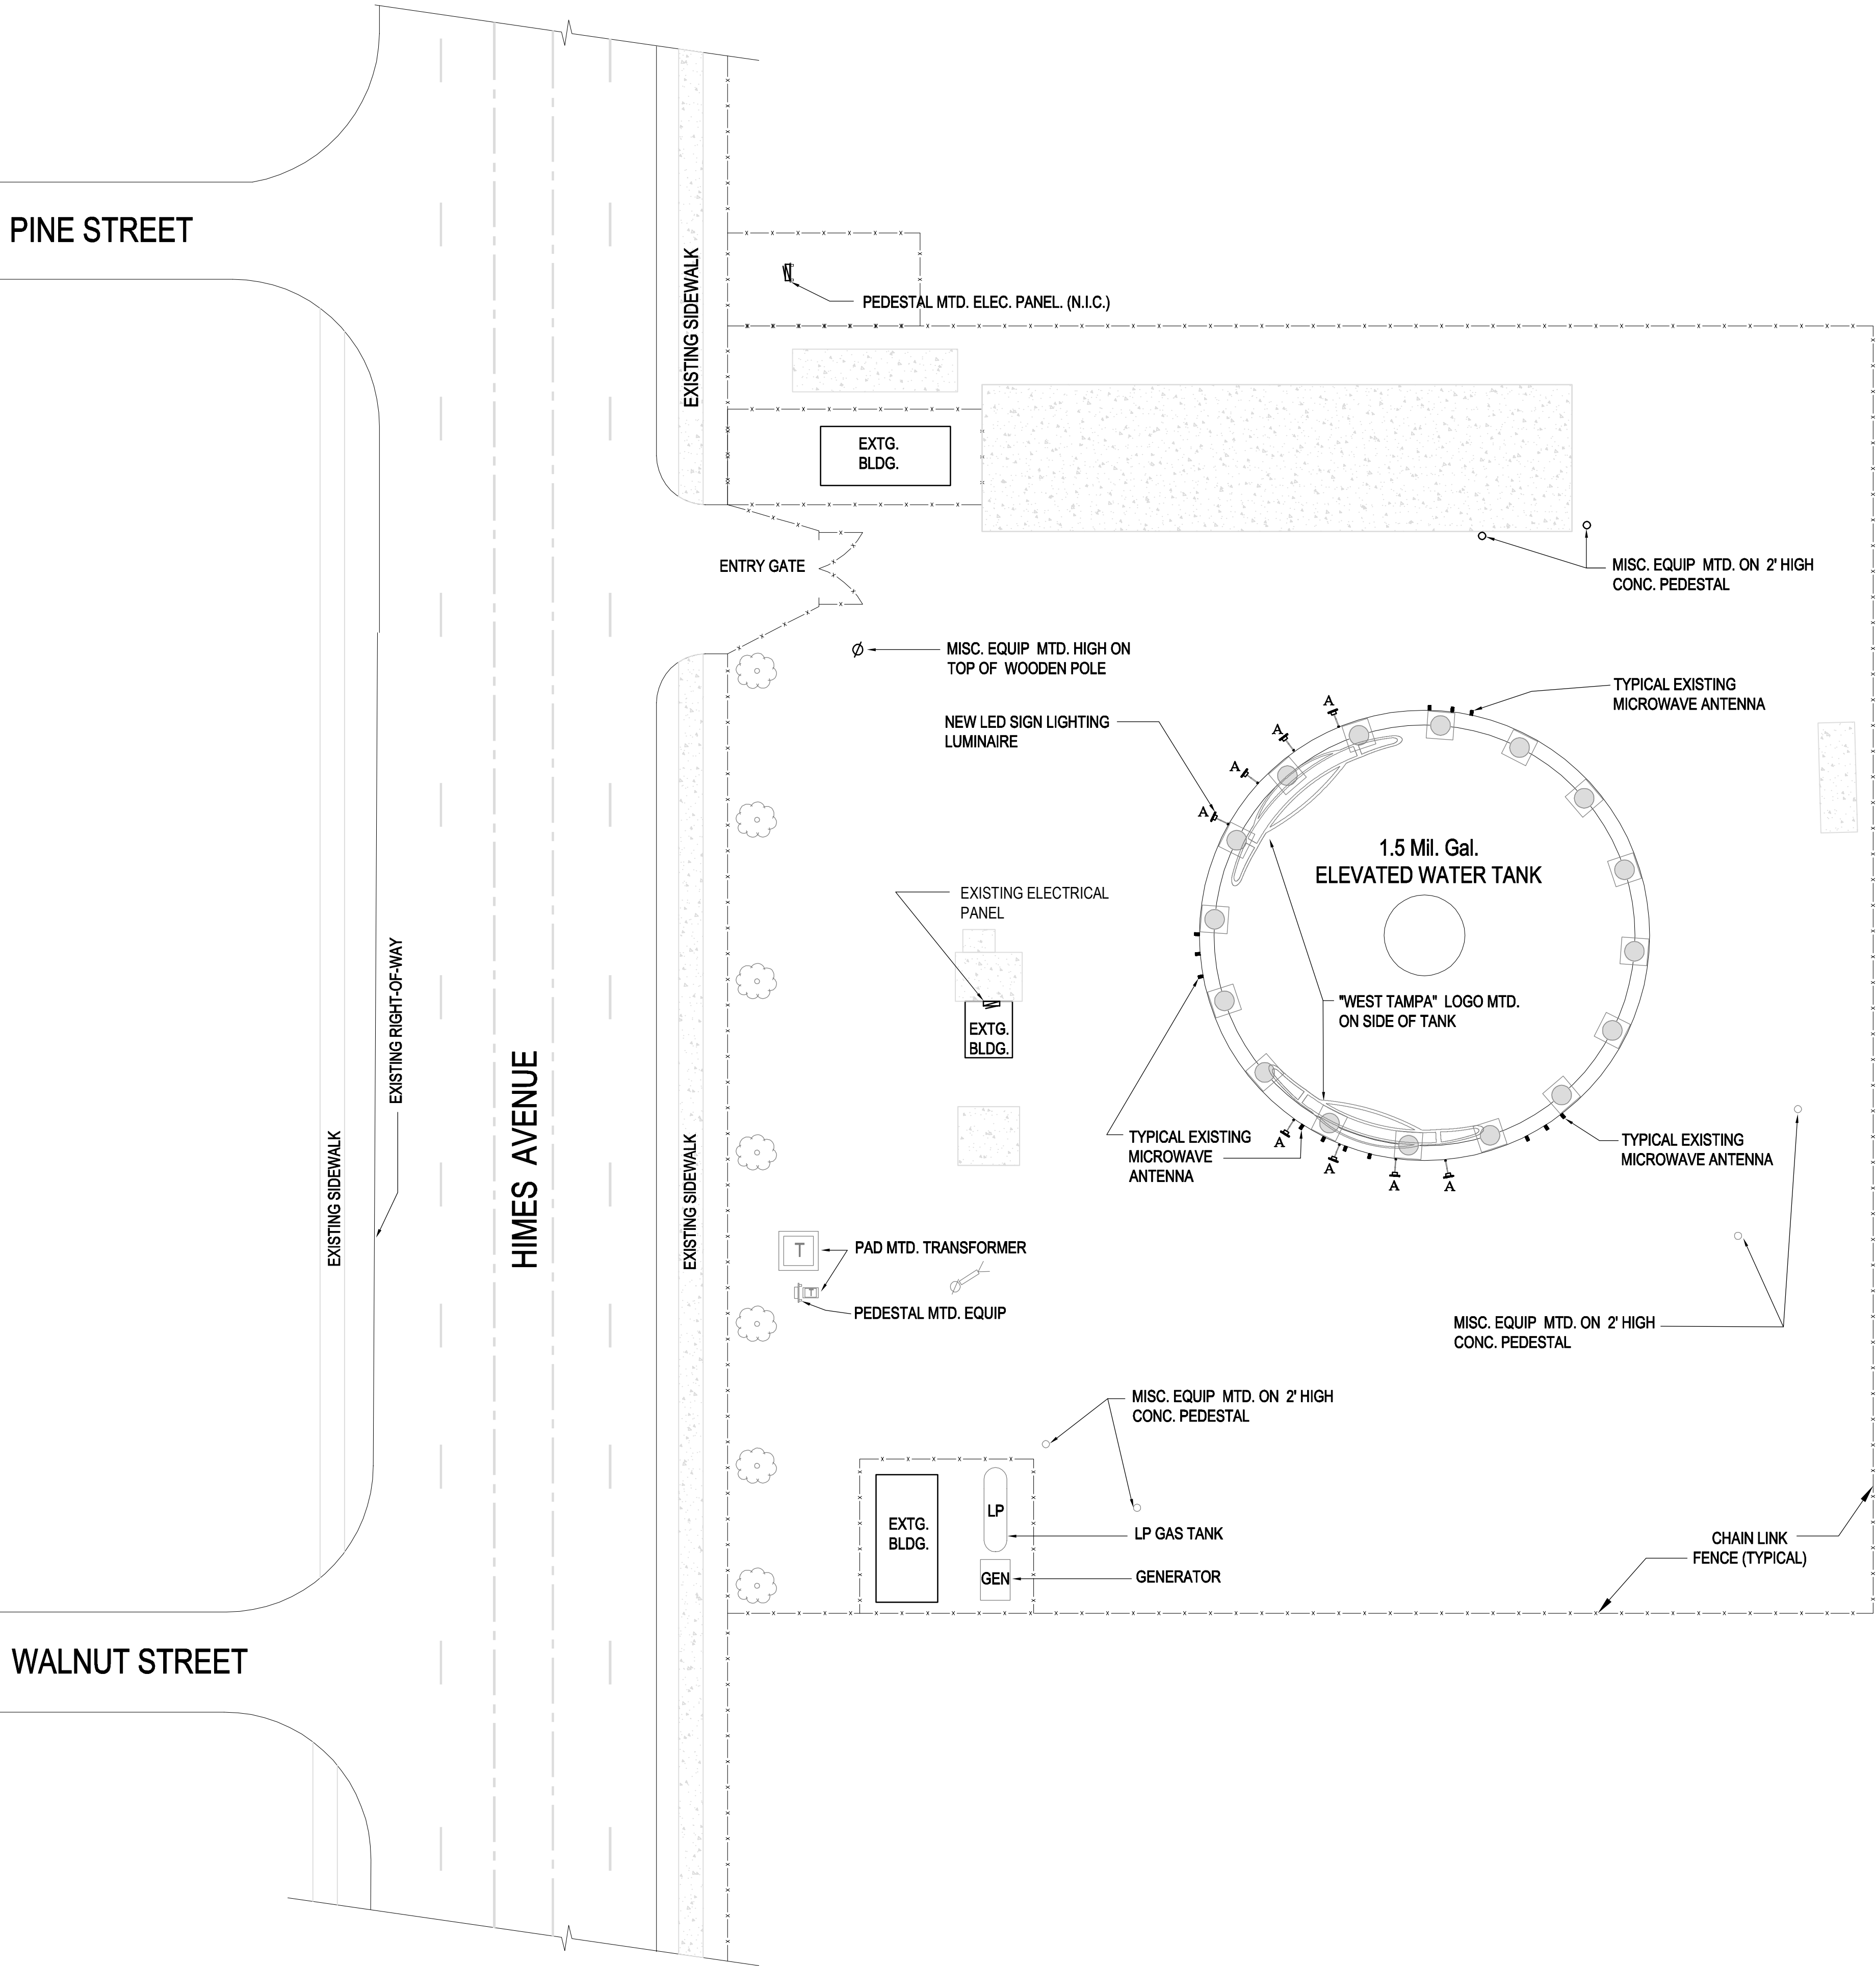

WEST TAMPA WATER TANK
SITE LIGHTING PLAN

THESE PLANS ARE THE PROPERTY OF LYLE ENGINEERING GROUP, INC. AND ARE NOT TO BE REPRODUCED, COPIED, OR TRANSMITTED IN ANY FORM OR BY ANY MEANS, WITHOUT THE WRITTEN APPROVAL OF LYLE ENGINEERING GROUP, INC. ANY CHANGES TO THESE PLANS SHALL BE MADE BY LYLE ENGINEERING GROUP, INC. THESE PLANS, WITHOUT THE EXPRESS APPROVAL OF LYLE ENGINEERING GROUP, INC., SHALL NOT BE USED FOR ANY OTHER PROJECT OR INTENT. LYLE ENGINEERING GROUP, INC. SHALL NOT BE RESPONSIBLE FOR ANY DAMAGE TO PERSONS OR PROPERTY, INCLUDING BUT NOT LIMITED TO, INJURY TO PERSONS OR PROPERTY, ARISING OUT OF THE USE OF THESE PLANS. IT IS THE RESPONSIBILITY OF THE USER OF THESE PLANS TO OBTAIN ALL NECESSARY PERMITS AND APPROVALS FROM THE APPROPRIATE AGENCIES. THESE PLANS ARE PROVIDED AS IS, WITHOUT WARRANTY OF ANY KIND, INCLUDING BUT NOT LIMITED TO, THE IMPLIED WARRANTIES OF MERCHANTABILITY AND FITNESS FOR A PARTICULAR PURPOSE. LYLE ENGINEERING GROUP, INC. SHALL NOT BE LIABLE FOR ANY SPECIAL, INCIDENTAL, OR CONSEQUENTIAL DAMAGES, INCLUDING BUT NOT LIMITED TO, LOSS OF PROFITS, BUSINESS, OR REPUTATION, ARISING OUT OF THE USE OF THESE PLANS. IT IS THE RESPONSIBILITY OF THE USER OF THESE PLANS TO OBTAIN ALL NECESSARY PERMITS AND APPROVALS FROM THE APPROPRIATE AGENCIES. THESE PLANS ARE PROVIDED AS IS, WITHOUT WARRANTY OF ANY KIND, INCLUDING BUT NOT LIMITED TO, THE IMPLIED WARRANTIES OF MERCHANTABILITY AND FITNESS FOR A PARTICULAR PURPOSE. LYLE ENGINEERING GROUP, INC. SHALL NOT BE LIABLE FOR ANY SPECIAL, INCIDENTAL, OR CONSEQUENTIAL DAMAGES, INCLUDING BUT NOT LIMITED TO, LOSS OF PROFITS, BUSINESS, OR REPUTATION, ARISING OUT OF THE USE OF THESE PLANS.

PROJECT NO.	215007
DRAWN BY:	PDR
DATE	12-30-2015
CHECKED BY:	SLL
DATE	12-30-2015

CONSTRUCTION DOCUMENTS	
ISSUE DATE	12/30/2015
NO.	REVISION
1	

TITLE:	WEST TAMPA WATER TANK SITE LIGHTING PLAN
PROJECT NAME:	CITY OF TAMPA WEST TAMPA WATER TANK TANK ILLUMINATION PROJECT 2201 N. HIMES AVENUE, TAMPA, FL 33607

SHEET NO:	E0.1
-----------	------

SCOTTLION LYLE P.E.
FL LIC. P.E. 2274

L
YLE

E
ENGINEERING

G
ROUP, INC.

CONSULTING ENGINEERS
1001 N. HAWTHORNE AVE., SUITE 100
TAMPA, FLA. 33604
www.lyleengineering.com

phone 813-935-5008
C4580

DESCRIPTION

The superior design and versatile construction of the Marquis LED sign and flood luminaire makes it an ideal option for new construction or a retrofit to achieve energy savings. Introducing mature LED technology to the sign light market means maintaining recommended light levels, reducing energy consumption over traditional sources and reducing maintenance costs. UL and cUL listed for wet locations.

Catalog #

Type

Project

Comments

Prepared by

Date

SPECIFICATION FEATURES

Construction

HOUSING: Rugged die-cast aluminum housing designed to optimize lumen output and enhance the natural cooling of the LEDs to maximize service life. Shallow housing profile is optimized for light distribution and to ensure minimal obstruction to billboard. Housing features a partition wall which isolates driver components for cooler operation. Monolithic heat sink provides superior heat transfer in +40°C ambient environments. DOOR: Door swings open and retained on the casting. GASKET: Continuous gasket provided to seal optical enclosure to housing. LENS: Premium quality glass lenses, including linear spread refractive prisms and Solite. Lenses are individually sealed to optical enclosure for IP66 rating. HARDWARE: Tool-less release latches are stainless steel construction and allows access to lead wires and mounting hardware.

Optics

DISTRIBUTION: Dedicated optical cavities for the array of 20 individual LEDs maximizes the efficiency and control of the distribution out of each module. Four or six total optical modules are optimally aimed to maximize

light collection and directional distribution onto the application area. Each reflector is specifically manufactured via injection molding and coated with a highly reflective optical coating via vacuum-metalization. Precisely engineered reflectors are coupled to the board media and sealed to an optically optimized premium glass lens. LEDs: Greater than 90% lumen maintenance expected at 60,000 hours per TM-21. Offered standard in 4000K (+/- 275K) CCT and 70 CRI nominal.

Electrical

DRIVER: LED drivers are potted and seal optical enclosure to housing and prolonged life. Standard drivers feature electronic universal voltage (120-277V/50-60Hz), greater than 0.8 power factor, less than 20% harmonic distortion and feature ambient temperature range of +40°C (104°F) down to minimum starting temperature of -40°C (22°F). Two standard drive currents are available (350mA or 700mA). Shipped standard with our proprietary circuit module designed to withstand 10kV of transient line surge. Options to control light levels, photocontrols and energy savings are available.

Warranty

Five-year warranty.

Finish

Housing is finished in super TGIC polyester powder coat paint, 2.5 mil nominal thickness for superior protection against fade and wear. Standard colors include black, bronze, grey, white, dark platinum and graphite metallic. RAL and custom color matches available. Consult Outdoor Architectural Colors brochure for a complete selection.

Mounting

INTERNAL MAST ARM: Mounting configuration available for arm to be supplied by others). Internal bolts guides and self-rising clamps allow easy positioning of fixture on mast arm during installation. SLIPFITTER WITH KNUCKLE: Slipfitter available for pole, mast arm or tenon mounting configurations (2-3/8" or 3" tenons are standard). DIRECT MOUNT DRILL PATTERN: Four-bolt pattern is available for direct or indirect mounting configuration.

MAQ MARQUIS LED

SIGN LIGHTING/
FLOOD LIGHTING

CERTIFICATION DATA

90°C Ambient Temperature Rating (UL and cUL Listed)
LM79 LMBD Compliant
IP66 Electrical Compartment
IP66 Optical Compartment
RoHS Compliant
ISO 9001
DreightLights Consortium® Qualified*

ENERGY DATA

Electronic LED Driver
≥0.8 Power Factor
≤20% Total Harmonic Distortion
120-277V/50 & 60Hz, 347V/60Hz, 480V/60Hz
90°C Minimum Temperature

EPA
Effective Projected Area (Sq. Ft.)
Luminaire size Arm 2.08

SHIPPING DATA

Approximate Net Weight:
Direct Mount 31 lbs. (14.09 kg)
Internal Mast Arm 31 lbs. (14.09 kg)
Slipfitter 34 lbs. (15.45 kg)

Dimensions

16-15/16" (380mm)

4-3/4" (146mm)

7-1/2" (190mm)

20-1/2" (521mm)

14-5/8" (372mm)

Cooper Lighting

by E.T-N

ADH101250

2014-08-21 15:48:12

www.designrights.org

MAQ MARQUIS LED

LIGHT CENTER (PHOTOMETRIC CENTER DIMENSIONS TO MOUNTING POSITION)

Direct Mount (DM)

Internal Mast Arm Mount (IM)

Slipfitter with Knuckle (FM)

Options

RD (Downlight Application)

Mounting Methods

DM (Direct Mount)

IM (Internal Mast Arm Mount)

FM (Slipfitter with Knuckle)

LUMENS AND POWER CHART

Number of LEDs	Drive Current	Distribution	Lumen Output	Wattage
120	350mA	Standard Narrow (SN)	11,548	120W
120	350mA	Standard Wide (SW)	11,368	120W
120	700mA	Standard Narrow (SN)	19,692	261W
120	700mA	Standard Wide (SW)	19,262	261W
90	350mA	Extra Wide (EX)	7,332	88W
90	700mA	Extra Wide (EX)	12,596	177W

LUMEN MULTIPLIER

Ambient Temperature	Lumen Multiplier
0°C	1.02
10°C	1.01
25°C	1.00
40°C	0.99
50°C	0.97

LUMEN MAINTENANCE

Ambient Temperature	TM-21 Lumen Maintenance (60,000 Hours)	Theoretical L70 (Hours)
25°C	> 94%	> 250,000
40°C	> 90%	> 250,000
50°C	> 90%	> 170,000

Cooper Lighting

by E.T-N

ADH101250

2014-08-21 15:48:12

www.designrights.org

MAQ MARQUIS LED

ORDERING INFORMATION

Sample Number: MAQ-B120-3-LED-347-SN-QM-QM

Product Family

LED Series

Drive Current

Lamp Type

Voltage

Distribution

Color

Mounting Method *

MAQ-Marquis

B120-3 LED's

3-350mA

LED-Solid State Light Emitting Diode

247-247V 480-480V Y

SN-Standard Narrow SW-Standard Wide EX-Extra Wide *

AP-Grey R2-Bronze BK-Black WH-White DR-Dark Platinum QM-Graphite Metallic

DM-Direct Mount IM-Internal Mast Arm FM-Slipfitter w/Knuckle Mount

Options (Add as Suffix)

Accessories (Order Separately)

RU-NEMA Twistlock Photocontrol Receptacle, Uplight Application
RA-NEMA Twistlock Photocontrol Receptacle, Downlight Application
SR-Screw Mount for Uplight Application
DM-10V Dimming Drivers

OA/RA1016-NEMA Twistlock Photocontrol - Multi-Tap
OA/RA1027-NEMA Twistlock Photocontrol - 480V
OA/RA1031-NEMA Twistlock Photocontrol - 247V
MA1253-10kV Circuit Module Replacement

Notes:

1. DreightLights Consortium® Qualified. Refer to www.designrights.org Qualified Products List under Family Models for details.
2. DM available with 5V distribution.
3. Not to be used with 5V photometric systems.
4. Only available with 100V.
5. Consult factory for listing NEMA Photocontrol receptacle.


Cooper Lighting

by E.T-N

ADH101250

2014-08-21 15:48:12

www.designrights.org

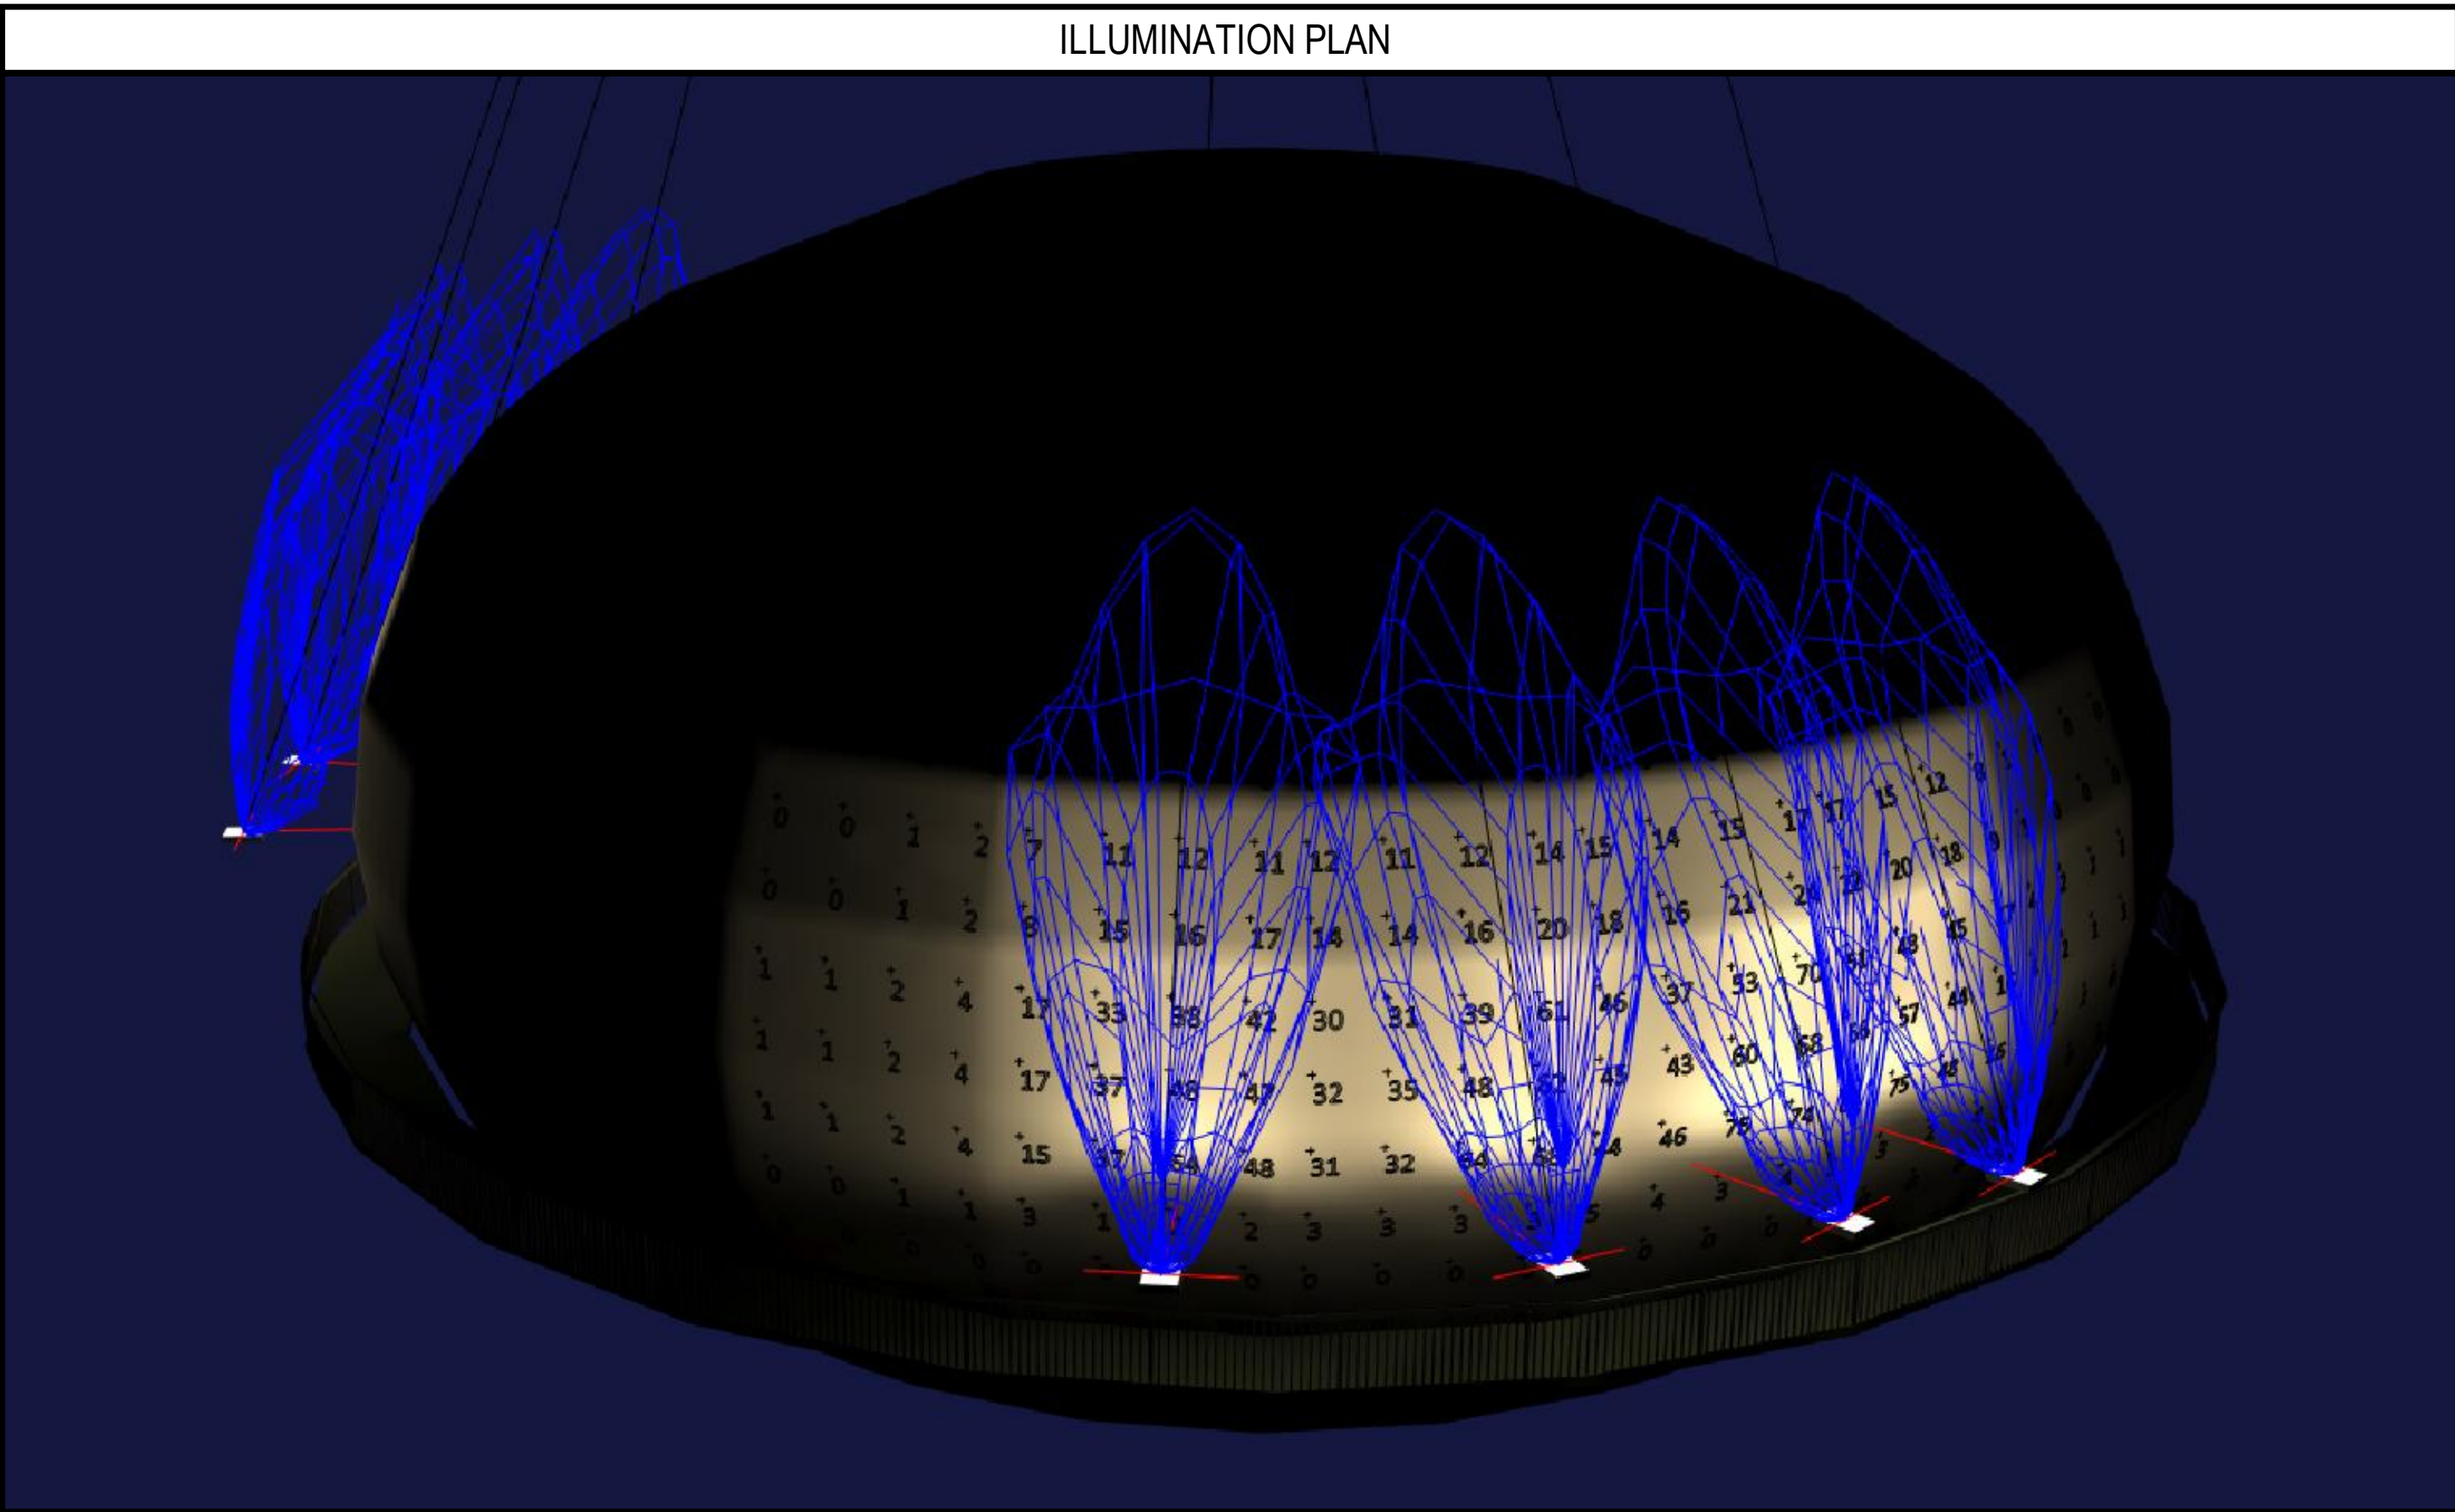

LUMINAIRE SCHEDULE							
SYM.	MANUFACT.	CATALOG NO.	LAMPS	VOLTS	WATTS	LOCATION/MTG.	REMARKS
A	McGRAW-EDISON	MAQ-B120-7-LED-E1-SW-BZ-FM	LED	120	261	POLE MTD.	.
NOTES:							

ELECTRICAL NOTES

A. ALL WORK TO CONFORM WITH THE LATEST REQUIREMENTS OF NATIONAL, STATE, AND LOCAL ELECTRICAL CODES.

B. ALL SERVICE EQUIPMENT TO CONFORM TO REQUIREMENTS OF LOCAL POWER COMPANY.

C. PROVIDE LABOR, MATERIAL AND EQUIPMENT NECESSARY TO FURNISH COMPLETE ELECTRICAL SYSTEM(S).

D. ALL CONDUCTORS SHALL BE SOLID COPPER, 600 VOLT WITH MINIMUM SIZE OF #12 AWG. THWN UNLESS OTHERWISE SPECIFIED. WIRE SIZES OF #8 AND LARGER SHALL BE STRANDED

E. ALL EQUIPMENT SHALL BE RATED FOR MAXIMUM AVAILABLE VOLTAGE AND GROUND FAULT CURRENT. ALL EQUIPMENT SHALL BE U.L. LISTED.

F. CONTRACTOR SHALL MAINTAIN A COMPLETE TEMPORARY POWER AND LIGHTING SYSTEM DURING CONSTRUCTION.

G. CONTRACTOR SHALL GUARANTEE ALL MATERIALS AND WORKMANSHIP FOR ONE YEAR.

H. CONTRACTOR SHALL OBTAIN AND PAY FOR ALL ELECTRICAL PERMITS AND INSPECTIONS.

I. ALL WIRE SHALL BE INSTALLED IN CONDUIT. ALL EXPOSED CONDUIT SHALL BE RIGID GALVANIZED STEEL CONDUIT INSTALLED BELOW SLAB, ON GRADE OR UNDERGROUND MAY BE SCHEDULE 40 PVC (3/4" MINIMUM). EMT MAY BE USED IN WALLS, CEILINGS OR WHERE NOT SUBJECT TO DAMAGE (1/2" MINIMUM). EMT CONNECTORS SHALL BE COMPRESSION TYPE WHERE SUBJECT TO MOISTURE. ALL CONDUIT SHALL BE CONCEALED WHERE POSSIBLE.

J. PROVIDE ALL REQUIRED SUPPORTS FOR MATERIAL AND EQUIPMENT.

K. PROVIDE GREEN GROUND WIRE IN EACH RACEWAY. SIZE WIRE IN ACCORDANCE WITH TABLE 250.122 OF THE NATIONAL ELECTRICAL CODE.

L. PANELBOARDS, CIRCUIT BREAKERS, DISCONNECT SWITCHES, STARTERS, TIMECLOCKS, OR OTHER ELECTRICAL APPARATUS INSTALLED FOR THE OPERATION OF ANY EQUIPMENT SHALL BE PROPERLY IDENTIFIED WITH ENGRAVED LAMINATED PLASTIC NAMEPLATES ATTACHED TO EQUIPMENT BY TWO PART EPOXY.

M. ALL WIREWAYS, PULLBOXES, OUTLET AND JUNCTION BOXES SHALL BE PROPERLY SIZED PER THE NATIONAL ELECTRICAL CODE, PULL AND OUTLET BOXES SHALL HAVE ALL WIRING TAGGED TO INDICATED PANEL AND CIRCUIT NUMBERS.

N. ALL FUSES WHEN REQUIRED SHALL BE BUSMANN SIZED PER EQUIPMENT REQUIREMENTS.

O. PROVIDE BACKBOX AND CONDUIT DISTRIBUTION SYSTEMS AS INDICATED ON THE DRAWINGS. VERIFY ALL LOCATIONS WITH THE TELEPHONE COMPANY. WHERE INDIVIDUAL OUTLETS ARE SHOWN PROVIDE FLUSH OUTLET BOX WITH BLANK COVER (MOUNTED AT 18" A.F.F.) AND A 3/4" CONDUIT INSTALLED IN WALL FROM THE BOX TO A POINT ABOVE THE CEILING.

P. CONTRACTOR SHALL VISIT JOB SITE PRIOR TO BID AND BE FAMILIAR WITH ALL EXISTING CONDITIONS.

SPECIAL CONDITIONS

PROVIDE (2) TWO COPIES OF TECHNICAL DATA FOR ALL ELECTRICAL EQUIPMENT FURNISHED.

PROVIDE RECORD DRAWINGS UPON COMPLETION OF WORK. PRESENT THE OWNER WITH (3) THREE RECORD SETS OF RECORD DRAWINGS. RECORD DRAWINGS SHALL BE UPDATED DAILY.

PROVIDE THE OWNER WITH INSTRUCTION IN THE OPERATION OF ALL ELECTRICAL SYSTEMS.

PROVIDE THE OWNER WITH (2) TWO SETS OF MAINTENANCE AND OPERATIONS MANUAL FOR ALL ELECTRICAL EQUIPMENT.

phone 813-935-5008

LVEENGINEERING

GROUP, INC.

CONSULTING ENGINEERS

1101 N. Himes Avenue, Suite 200
Tampa, FL 33604

www.lveengineering.com

CAS90

SCOTTLIONS LVE P.E.

FL LIC. P.E. 2724

THESE PLANS ARE THE PROPERTY OF LVE ENGINEERING AND ARE TO BE USED ONLY FOR THE PROJECT AND SITE SPECIFICALLY IDENTIFIED HEREON. ANY CHANGES TO THESE PLANS ARE THE RESPONSIBILITY OF THE USER. WITHOUT THE WRITTEN APPROVAL OF LVE ENGINEERING, THESE PLANS SHALL NOT BE REPRODUCED, COPIED, OR OTHERWISE USED FOR ANY OTHER PROJECT. LVE ENGINEERING GROUP, INC. SHALL NOT BE RESPONSIBLE FOR ANY DAMAGE, LOSS, OR INJURY RESULTING FROM THE USE OF THESE PLANS. IT IS THE USER'S RESPONSIBILITY TO OBTAIN ALL NECESSARY PERMITS AND TO FOLLOW ALL APPLICABLE CODES AND REGULATIONS. IF ANY DISCREPANCY OR CONFLICT EXISTS BETWEEN THESE PLANS AND ANY OTHER DOCUMENTS, THESE PLANS SHALL PREVAIL. IT IS THE USER'S RESPONSIBILITY TO VERIFY THE ACCURACY OF ALL INFORMATION PROVIDED HEREON.

PROJECT NO. 215007

DATE 12-30-2015

CHECKED BY SLL

DATE 12-30-2015

CONSTRUCTION DOCUMENTS


ISSUE DATE 12/30/2015

NO. DATE REVISION


TITLE: DETAILS, LEGENDS, AND SCHEDULES

PROJECT NAME: CITY OF TAMPA
WEST TAMPA WATER TANK
TANK ILLUMINATION WATER PROJECT
2201 N. HIMES AVENUE, TAMPA, FL 33607

SHEET NO: E1.1

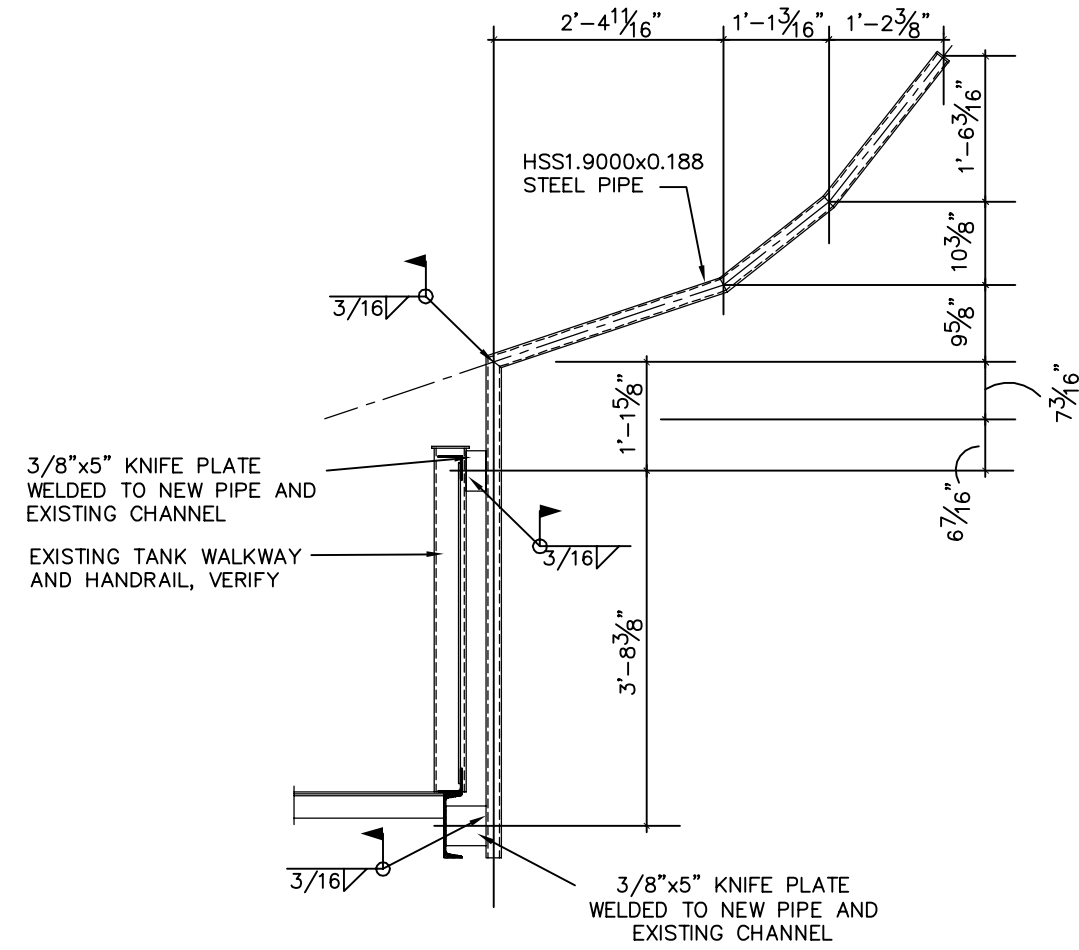



 
LUMINAIRE MOUNTING DETAIL
SCALE: 1/2" = 1'-0"



WIND DESIGN DATA:
CODE: FLORIDA BUILDING CODE 5TH EDITION (2014)
ASCE 7-10
EXPOSURE CATEGORY: C
RISK CATEGORY: IV
BASIC WIND SPEED: 150 MPH (UH)
ENCLOSURE CLASSIFICATION: OPEN
WIND PRESSURE: 60 PSF (ASD)




WEST TAMPA WATER TANK
SIDE ELEVATION

 SCALE: 1/16" = 1'-0"

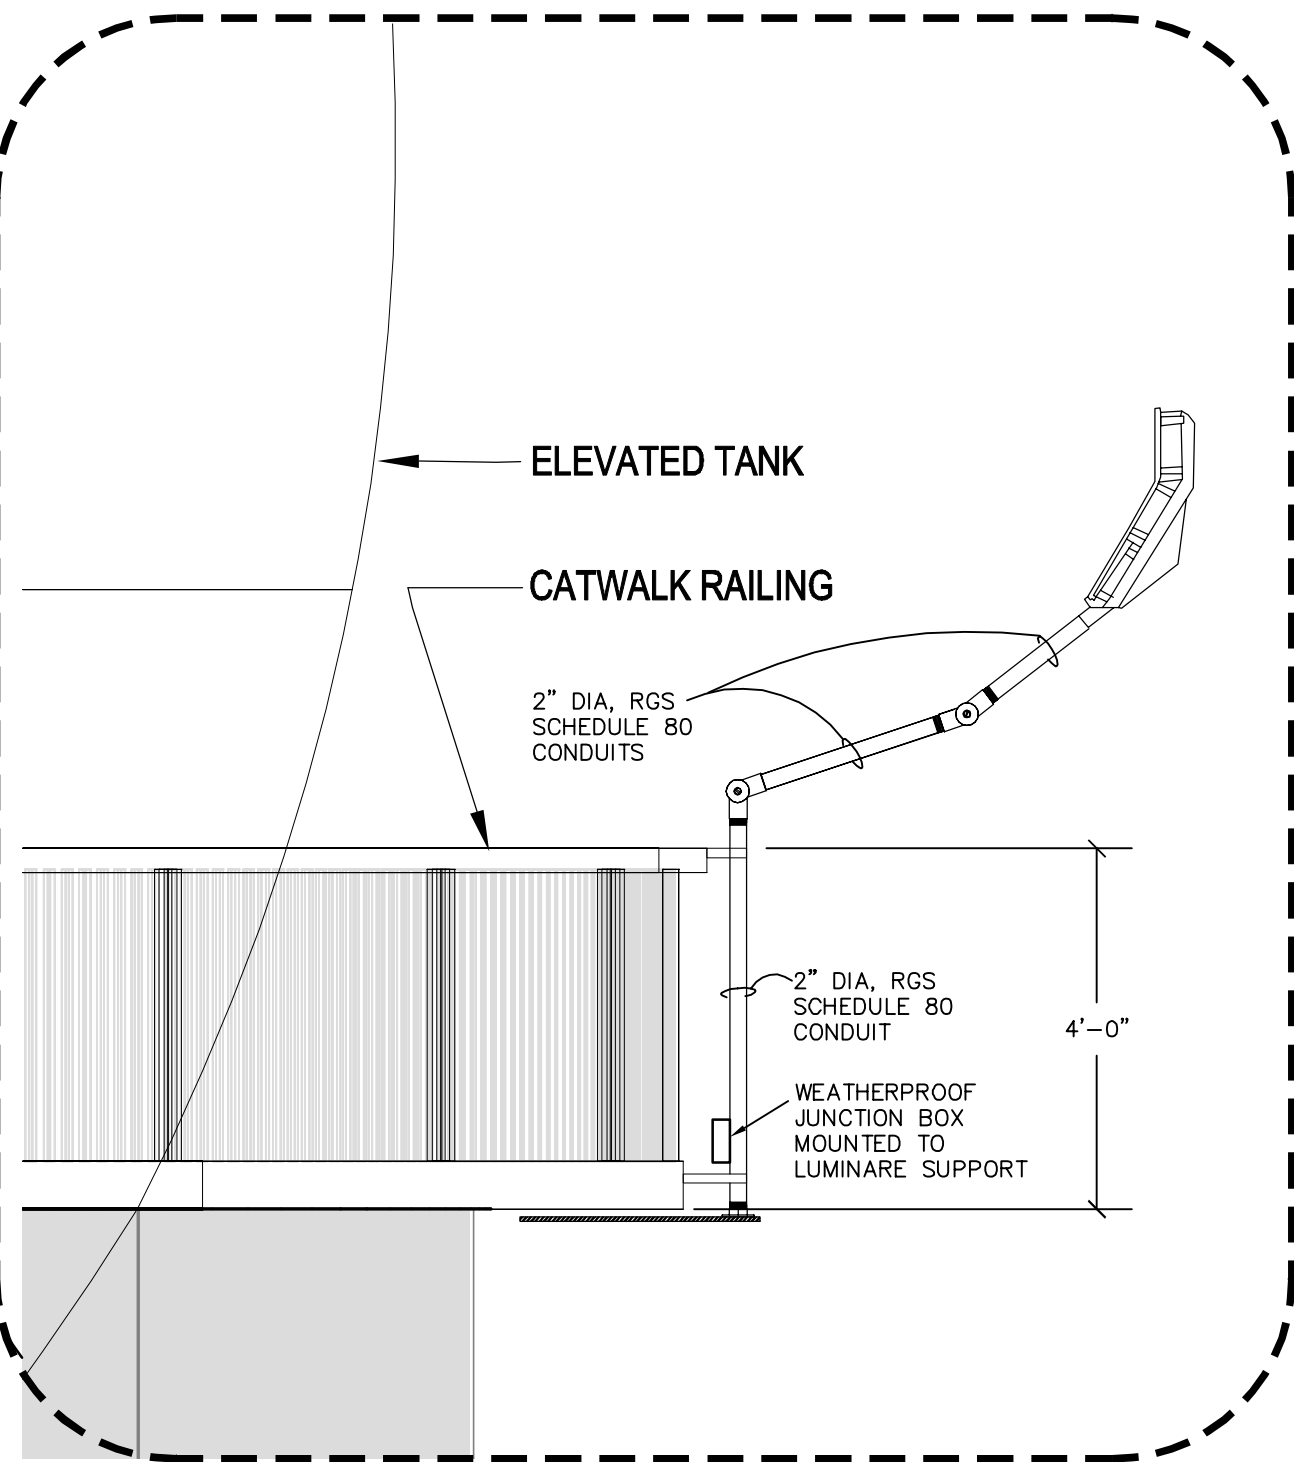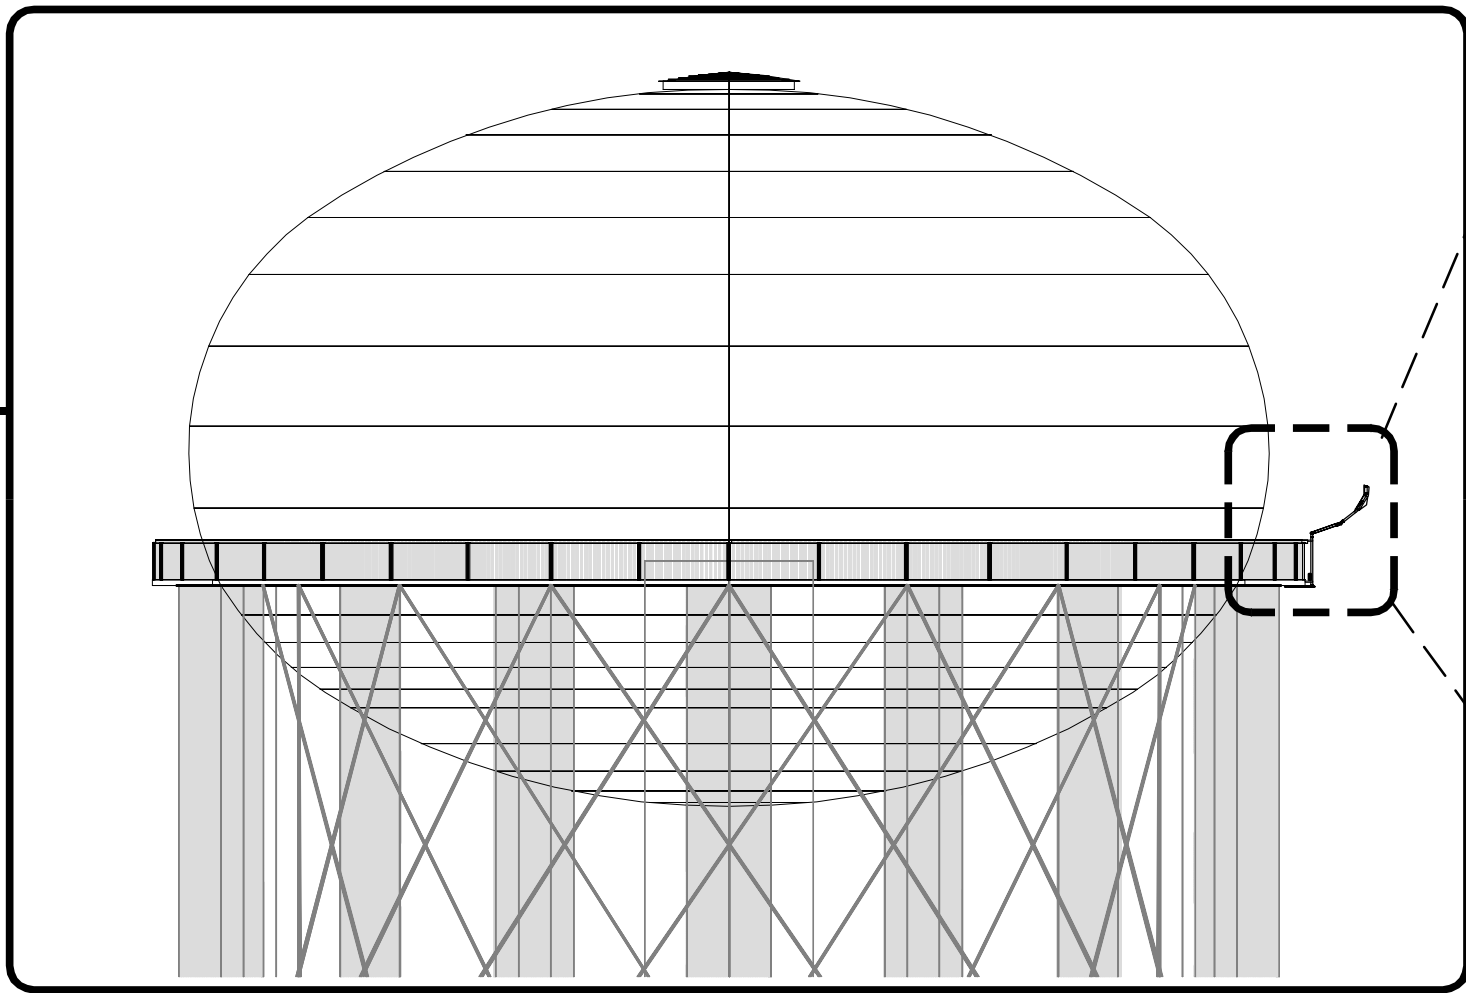

WEST TAMPA WATER TANK
ENLARGED SECTION

SCALE: 1/2" = 1'-0"

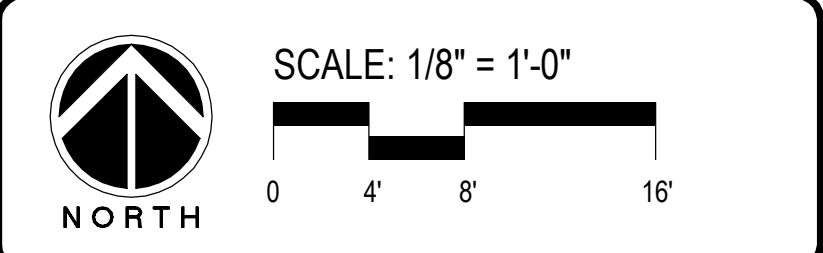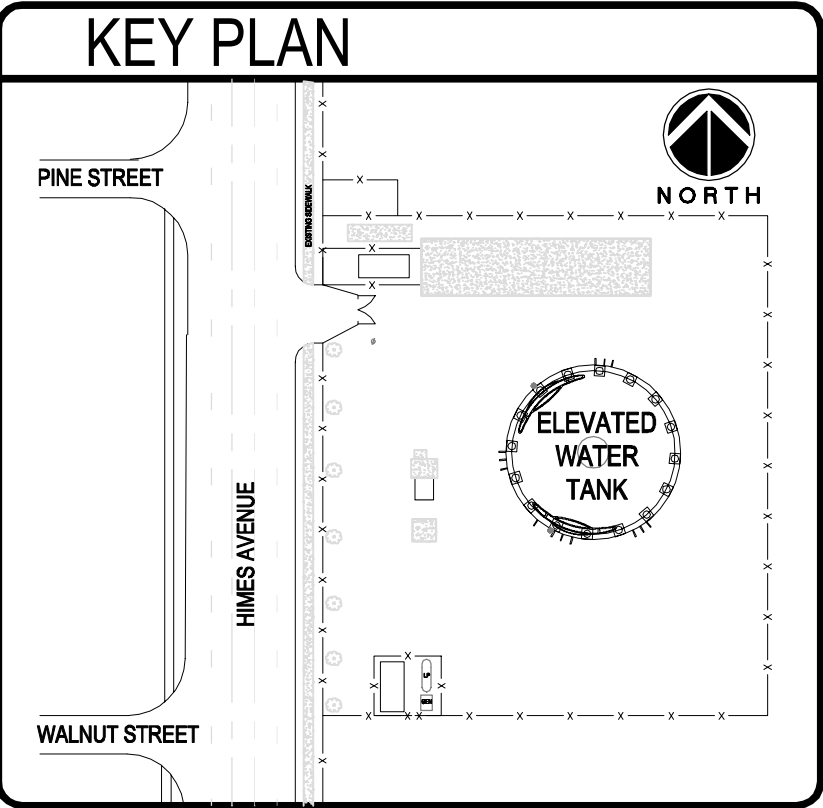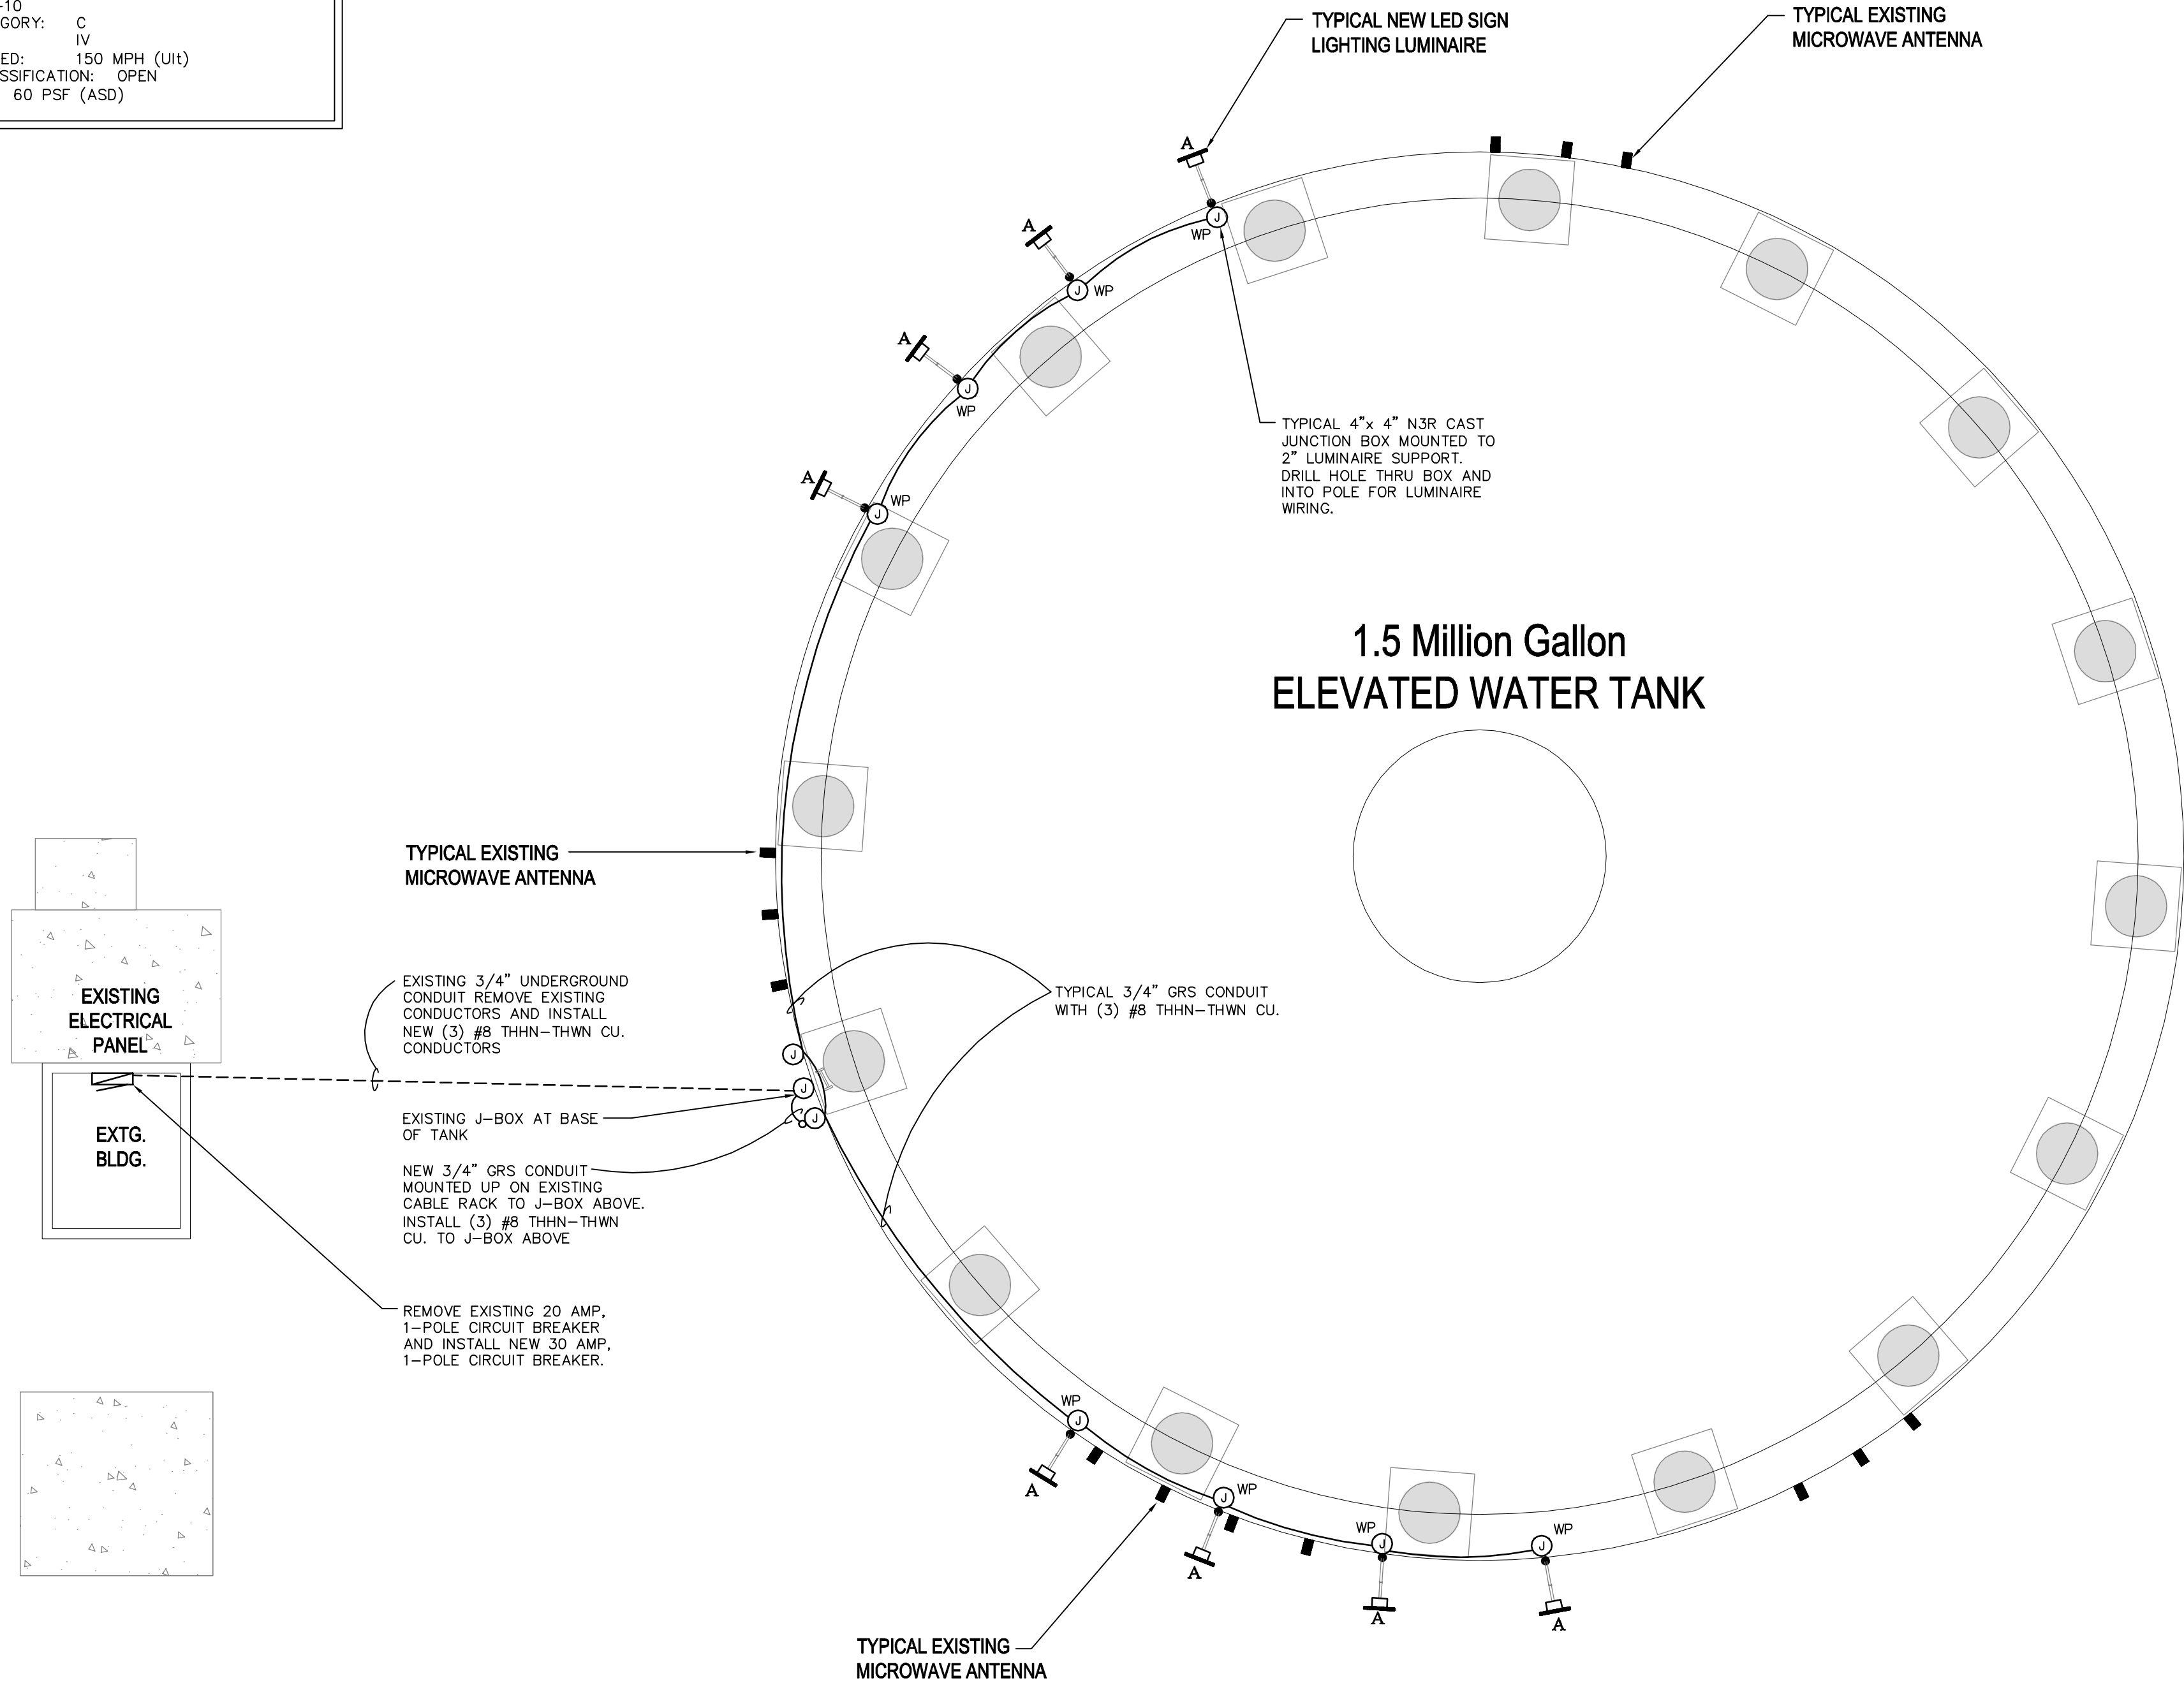

WEST TAMPA WATER TANK
FLOOR PLAN